

ELGIN PARK REDEVELOPMENT PROJECT

265 - 327 ELGIN STREET
COBOURG, ONTARIO

DRAWING LIST

ARCHITECTURAL

- A001 OBC MATRIX
- A002 OBC MATRIX
- A101 OVERALL SITE PLAN
- A102 SITE PLAN PARTS A & B
- A103 SITE DETAILS
- A104 SITE DEMOLITION PLAN PARTS A & B
- A201 BUILDING 1, BASEMENT & GROUND FLOOR PLAN
- A202 BUILDING 1, 2ND FLOOR & ROOF PLAN
- A203 BUILDING 2, BASEMENT & GROUND FLOOR PLAN
- A204 BUILDING 2, 2ND FLOOR & ROOF PLAN
- A205 BUILDING 3, BASEMENT & GROUND FLOOR PLAN
- A206 BUILDING 3, 2ND FLOOR & ROOF PLAN
- A207 BUILDING 4, BASEMENT & GROUND FLOOR PLAN
- A208 BUILDING 4, 2ND FLOOR & ROOF PLAN
- A209 BUILDING 5, FLOOR PLAN & ROOF PLAN
- A301 BUILDING 1 ELEVATIONS & SECTIONS
- A302 BUILDING 2 ELEVATIONS & SECTIONS
- A303 BUILDING 3 ELEVATIONS & SECTIONS
- A304 BUILDING 4 ELEVATIONS & SECTIONS
- A305 BUILDING 5 ELEVATIONS & SECTIONS

CIVIL

- CV-1 EROSION AND SSEDIMENT CONTROL PLAN
- CV-2 SERVICING PLAN
- CV-3 GRADING PLAN
- CV-4 DETAILS PLAN 1
- CV-5 DETAILS PLAN 2

LANDSCAPE

- L1 LANDSCAPE PLAN
- L2 LANDSCAPE DETAILS
- TP1 TREE PRESERVATION PLAN

ELECTRICAL

- SL SITE LIGHTING PHOTOMETRICS



ELGIN STREET PERSPECTIVE



KEY PLAN

No.	ISSUES	DATE	BY
1	ISSUED FOR REZONING	20/06/30	
2	ISSUED FOR SPA	20/12/07	


ELGIN PARK REDEVELOPMENT PROJECT

265 - 327 ELGIN STREET
COBOURG, ONTARIO

Project No. 19284

A000

ARCHITECTURAL/STRUCTURAL:

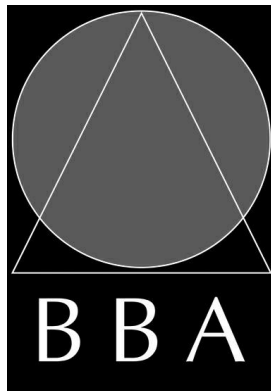

**BARRY BRYAN
ASSOCIATES**

*Architects
Engineers*

Project Managers
201-250 Water St.
Whitby, Ontario L1N 0G5
Tel: (905) 666-5252
Fax: (905) 666-5256
e-mail: bba@bbs-archeng.com

CIVIL:




CONSULTING INC
Consulting Engineering & Project Management
555 Industrial Drive
Suite 201
Milton, Ontario
L9T 5E1
Tel: (905) 567-9678
Fax: (905) 575-1339
Email: mgm@mgm.on.ca
www.mgm.on.ca

MECHANICAL/ELECTRICAL:




D.G. Biddle & Associates Limited
consulting engineers and planners
96 KING STREET EAST OSHAWA, ON L1H 1B6
PHONE (905) 576-8500 • FAX (905) 576-9730
info@dgbiddle.com

LANDSCAPE:

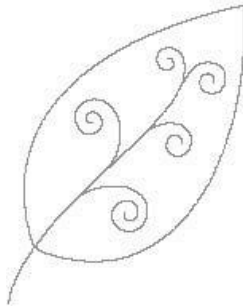

NewLeaf Landscape Architecture Ltd.
T: 905-373-5015 E: info@newleaf.pro

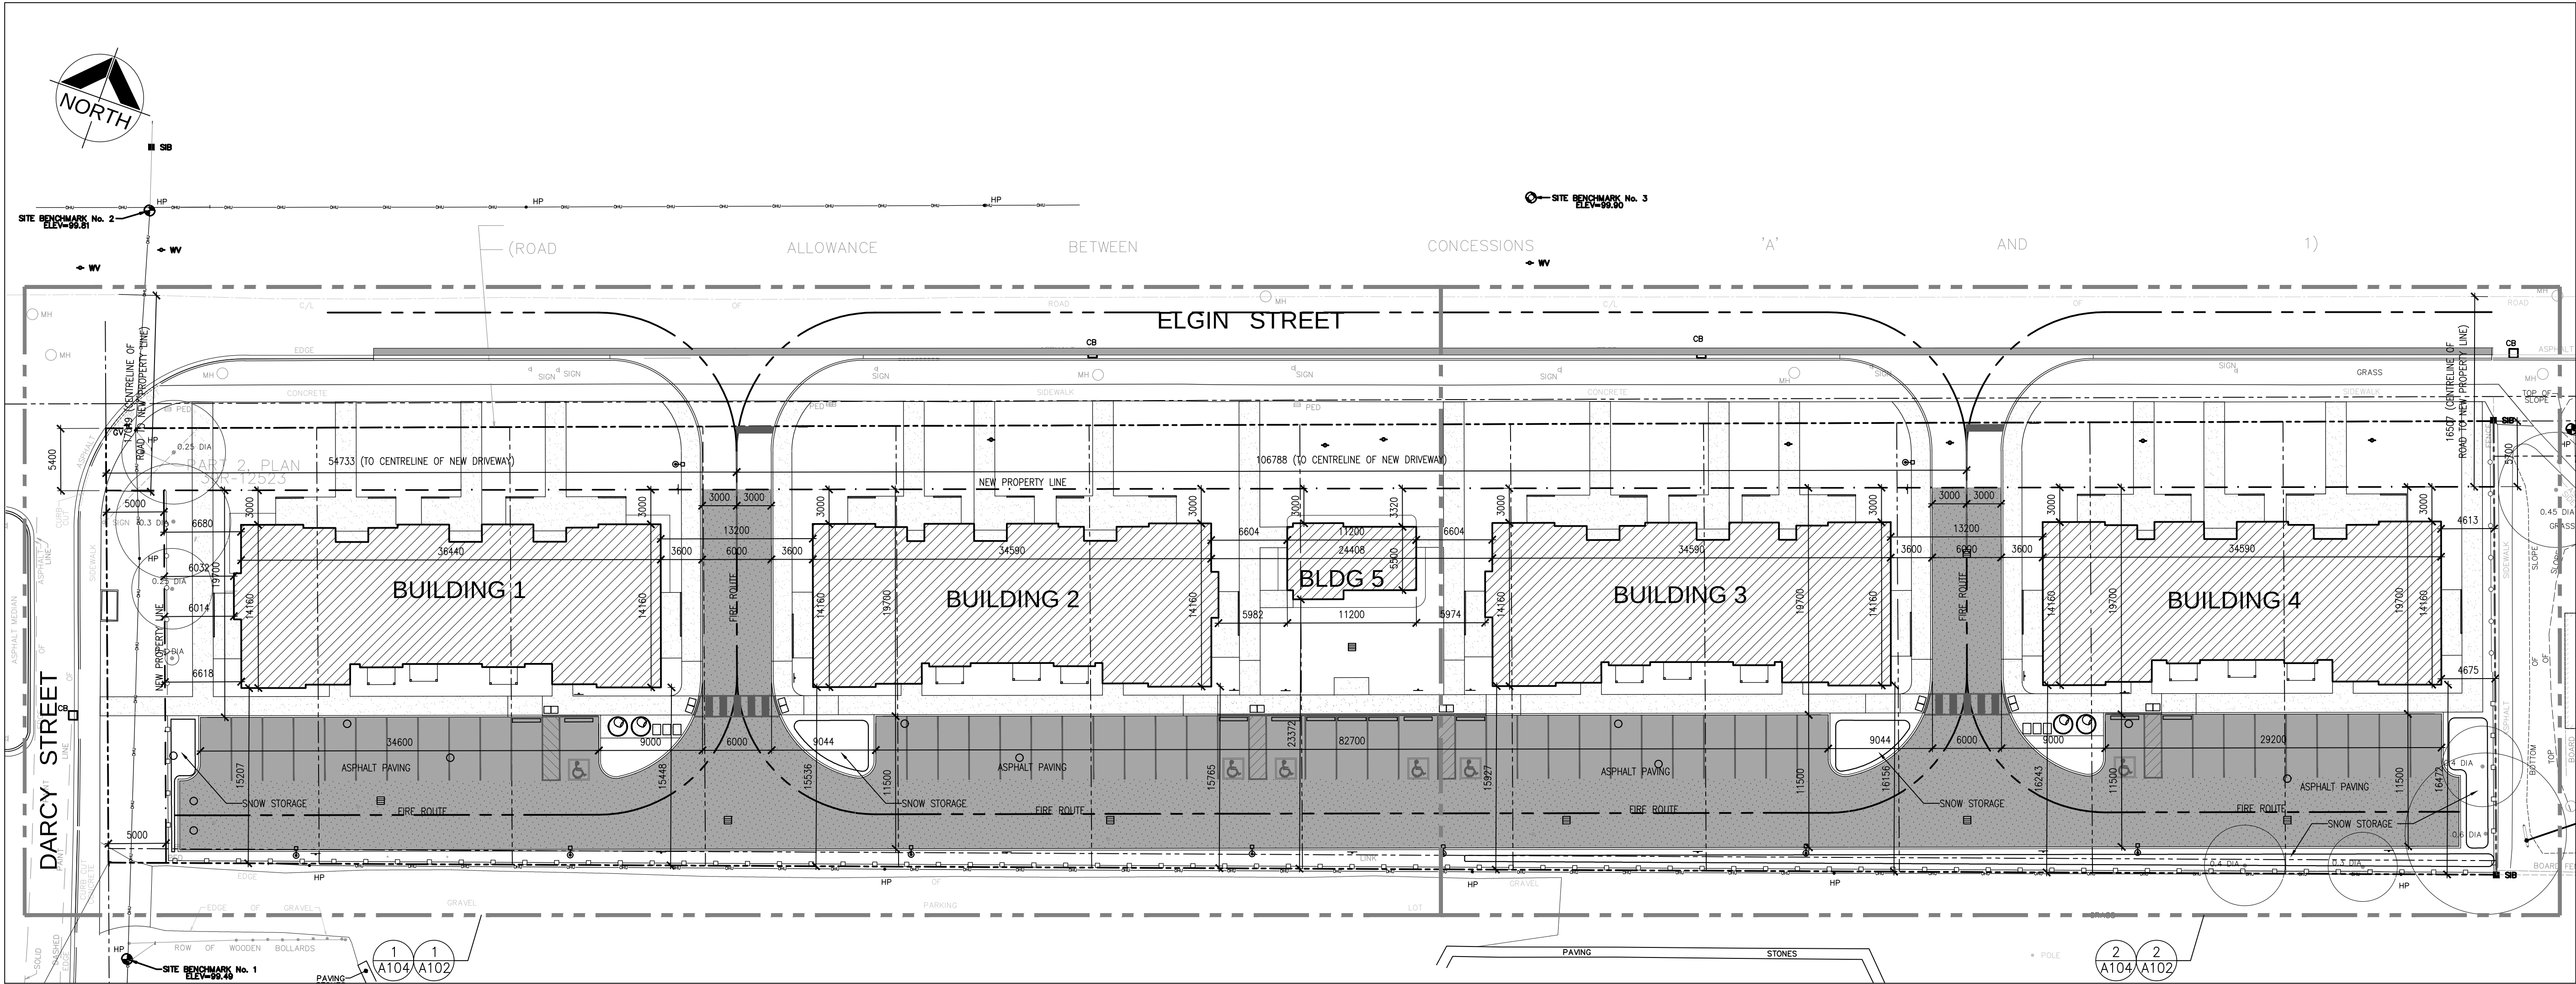

1 OVERALL SITE PLAN
1:300

SITE STATISTICS

Site Area: 6675.1 s.m. (excludes municipal road widening areas)		Zoning: R4 (Multi-Residential) Re-zoning application in process.	
New Building Areas:			
Building 1=	467.34 sq.m.		
Building 2=	446.93 sq.m.		
Building 3=	446.93 sq.m.		
Building 4=	444.31 sq.m.		
Building 5=	66.42 sq.m.		
Total=	1,871.93 sq.m.		
Total Building Area: 1,871.93 s.m.		Building Coverage: 28.04%	
Paved Area: 2,368.5 s.m.		Paving Percentage: 35.48%	
Landscape Area: 2434.67 s.m.		Landscape Percentage: 36.48%	
Building Height:		Required TBD	
		Provided 2 storeys (---m)	
Setbacks:			
Front Yard (N)	Required 3.00m	Actual: 3.000m	
Exterior Side Yard (W)	Required 6.00m	Actual: 6.014m	
Interior Side Yard (E)	Required 3.50m	Actual: 4.615m	
Rear Yard (S)	Required TBD	Actual: 15.207m	
Bldg 1	Required TBD	Actual: 15.536m	
Bldg 2	Required TBD	Actual: 15.927m	
Bldg 3	Required TBD	Actual: 16.243m	
Bldg 4	Required TBD	Actual: 23.372m	
Bldg 5	Required TBD		
Parking: (Include B/F stall)		Required TBA	
		Provided: 52	
Stall Size:		Required 2.7m x 5.5m	
		Provided 2.7m x 5.5m	
B/F Stall Size:		Required: 6	
TYPE A= 3.4m x 5.5m		Provided: 6	
TYPE B = 2.4M x 5.5m			

SITE ABBREVIATIONS

AD	AREA DRAIN
ANC	ANCHOR
BF	BARRIER FREE PARKING SIGN. (AS PER ONTARIO TRAFFIC MANUAL)
BL	BOLLARD LIGHT. REFER TO ELECT. DWGS.
BOL	BOLLARD (REFER TO DETAIL 8/A102)
BP	BELL POLE
CB	CATCH BASIN
FH	FIRE HYDRANT
FR	FIRE ROUTE SIGN.
GM	REFER TO DETAIL 3/A102
HP	GAS METER
MH	HYDRO POLE
MH	MAN HOLE
WV	WATER VALVE

NOTES:

1. ALL EXISTING SITE INFORMATION DERIVED FROM SURVEY.
DRAWING 20-25-815-00 BY J.D. BARNES DATED MAY 14, 2020.


DO NOT SCALE THE DRAWINGS.
CHECK AND VERIFY ALL DIMENSIONS AT THE SITE.
ALL DRAWINGS, SPECIFICATIONS AND RELATED DOCUMENTS ARE THE COPYRIGHT PROPERTY OF THE CONSULTANT AND MUST BE RETURNED UPON REQUEST. REPRODUCTION OF DRAWINGS IN PART OR WHOLE WITHOUT THE PERMISSION OF THE CONSULTANT IS FORBIDDEN.
DRAWINGS ARE NOT TO BE USED FOR CONSTRUCTION UNTIL SIGNED AND SEALED BY THE CONSULTANT.

NO.	ISSUES	DATE	BY
1	ISSUED FOR SITE PLAN APPROVAL	DEC. 07, 2020	BBA

NO.	REVISIONS	DATE	BY
-----	-----------	------	----

PROJECT:
ELGIN PARK REDEVELOPMENT PROJECT
265-327 ELGIN STREET
COBOURG, ON
NORTHUMBERLAND COUNTY


DRAWING:
OVERALL SITE PLAN

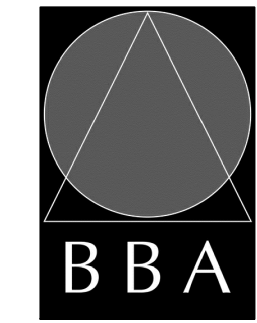


BARRY BRYAN ASSOCIATES
Architects
Engineers
Project Managers
250 Water Street
Suite 201
Whitby, Ontario
L1N 0G5
Tel: (905) 666-5252
Fax: (905) 666-5256
e-mail: bba@bba-archeng.com

DESIGN BY: BBA	DOC. CONTROL: DATE:
DRAWN BY: CM	% COMPLETE:
CHECKED BY: NS	INITIAL:
DATE: NOV. 2020	
SCALE: 1:300	
FILE:	

PROJECT NO: 19284	DRAWING NO: A101
-----------------------------	----------------------------

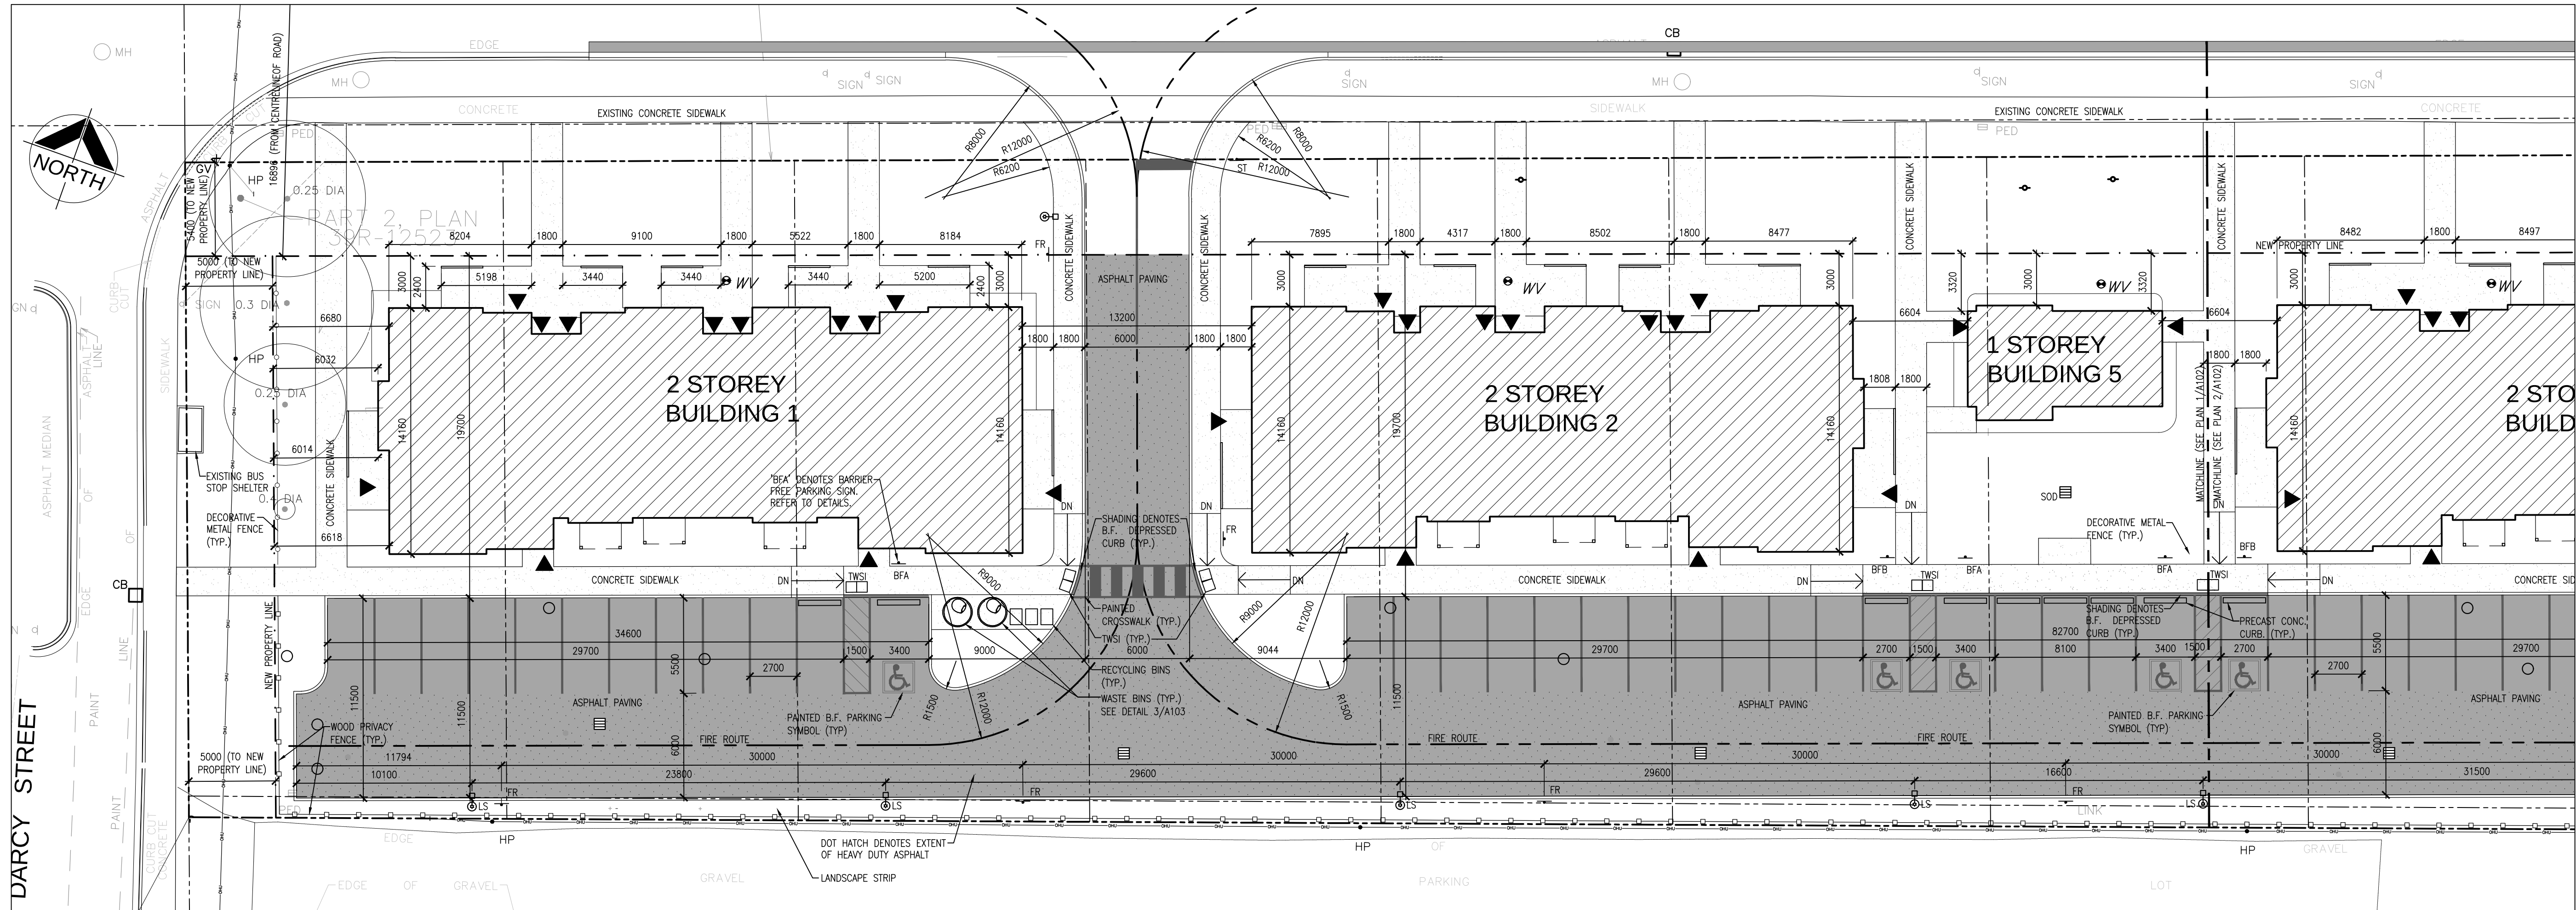

1 SITE PLAN - PART A
1:200

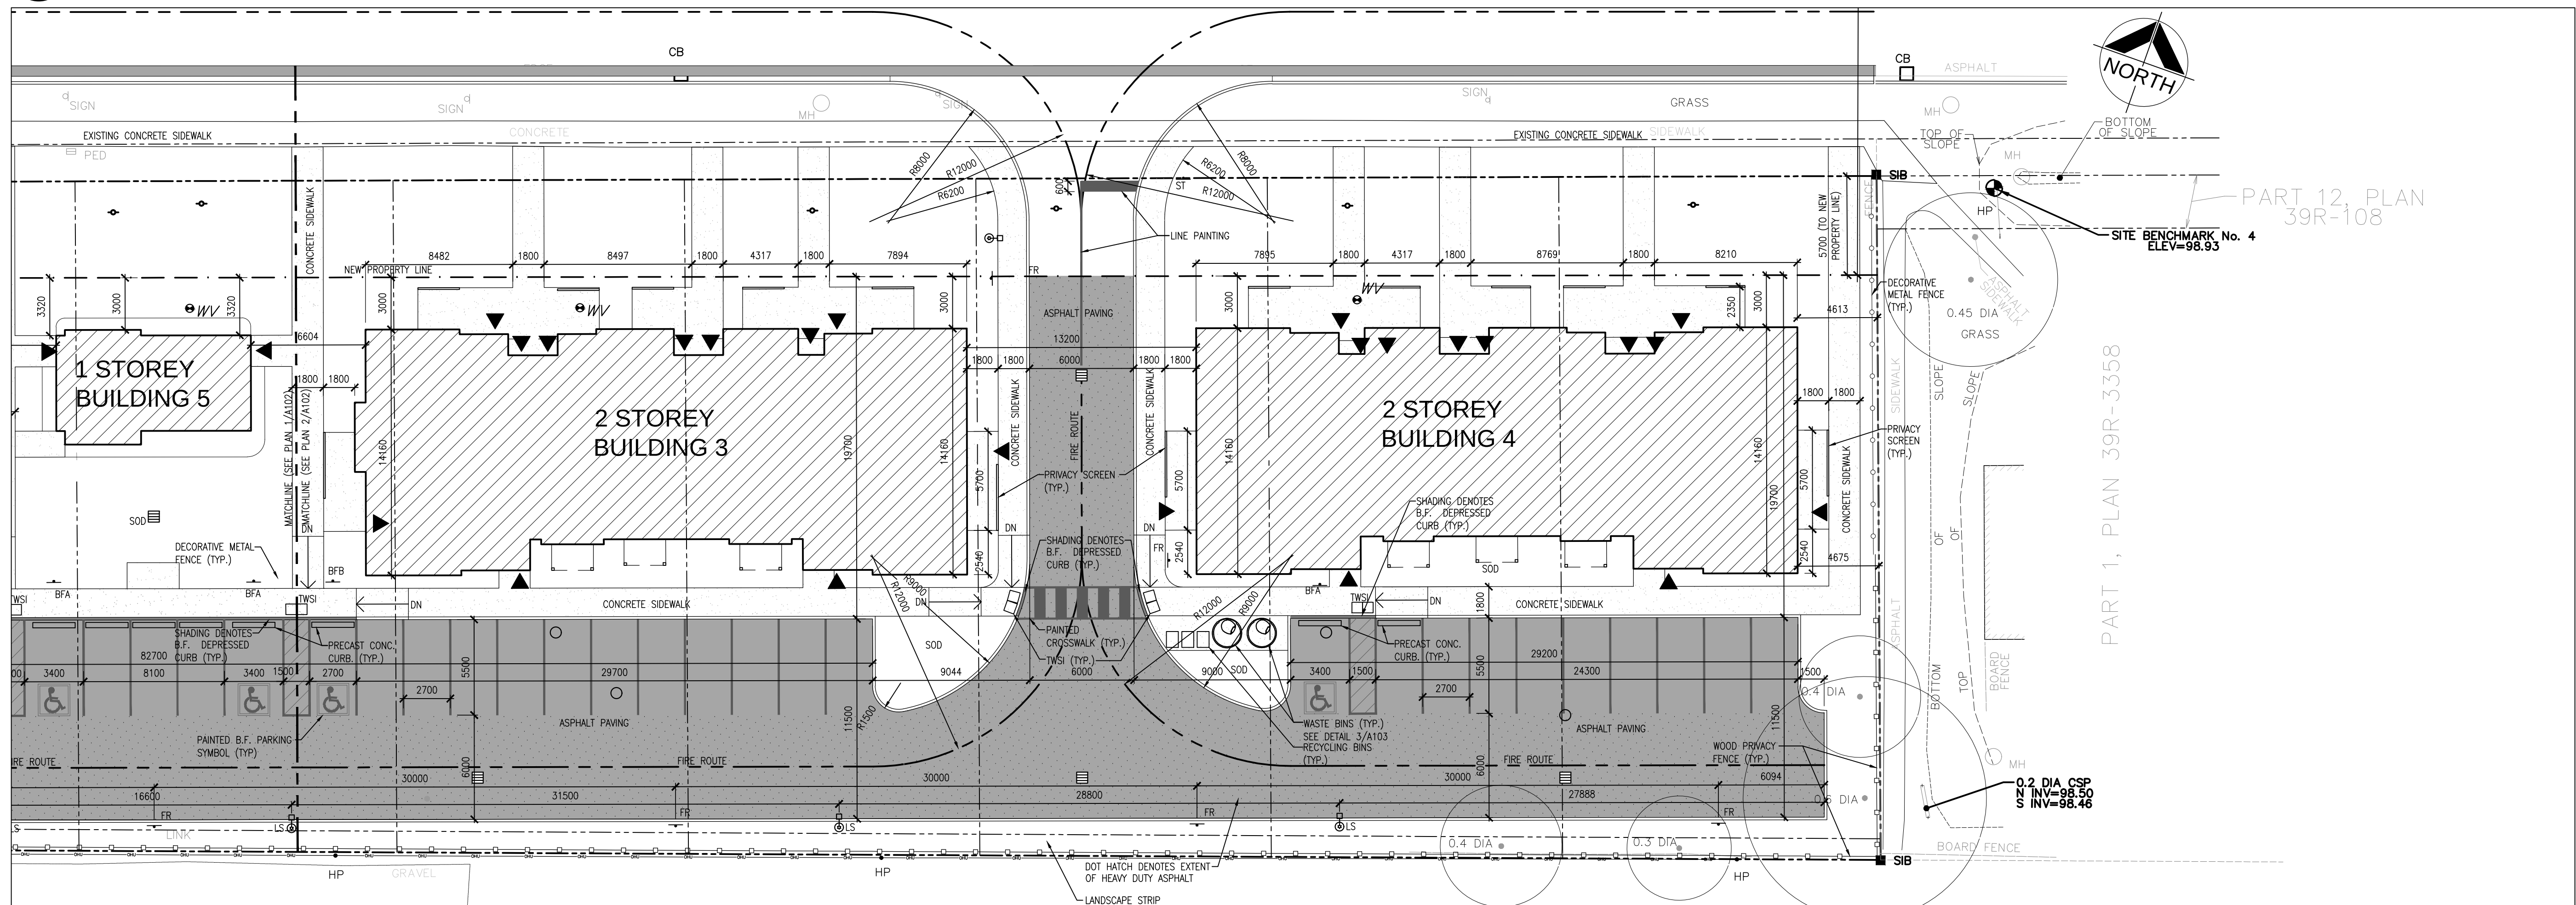

2 SITE PLAN - PART B
1:200


DO NOT SCALE THE DRAWINGS.
CHECK AND VERIFY ALL DIMENSIONS AT THE SITE.
ALL DRAWINGS, SPECIFICATIONS AND RELATED DOCUMENTS ARE THE COPYRIGHT PROPERTY OF THE CONSULTANT AND MUST BE RETURNED UPON REQUEST. REPRODUCTION OF DRAWINGS IN PART OR WHOLE WITHOUT THE PERMISSION OF THE CONSULTANT IS FORBIDDEN.
DRAWINGS ARE NOT TO BE USED FOR CONSTRUCTION UNTIL SIGNED AND SEALED BY THE CONSULTANT.

NO.	ISSUES	DATE	BY
1	ISSUED FOR SITE PLAN APPROVAL	DEC. 7, 2020	BBA

NO.	REVISIONS	DATE	BY
-----	-----------	------	----

PROJECT:
ELGIN PARK REDEVELOPMENT PROJECT
265-327 ELGIN STREET
COBOURG, ON
NORTHUMBERLAND COUNTY


DRAWING:
SITE PLAN PARTS A & B

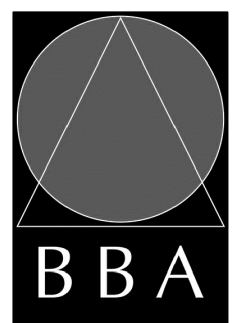


BARRY BRYAN ASSOCIATES
Architects
Engineers
Project Managers
250 Water Street
Suite 201
Whitby, Ontario
L1N 0G5
Tel: (905) 666-5252
Fax: (905) 666-5256
e-mail: bba@bba-archeng.com

DESIGN BY: BBA	DOC. CONTROL: DATE:
DRAWN BY: CM	% COMPLETE:
CHECKED BY:	INITIAL:
DATE: NOV. 2020	SCALE: 1:200
FILE:	


PROJECT NO:
19284
DRAWING NO:
A102

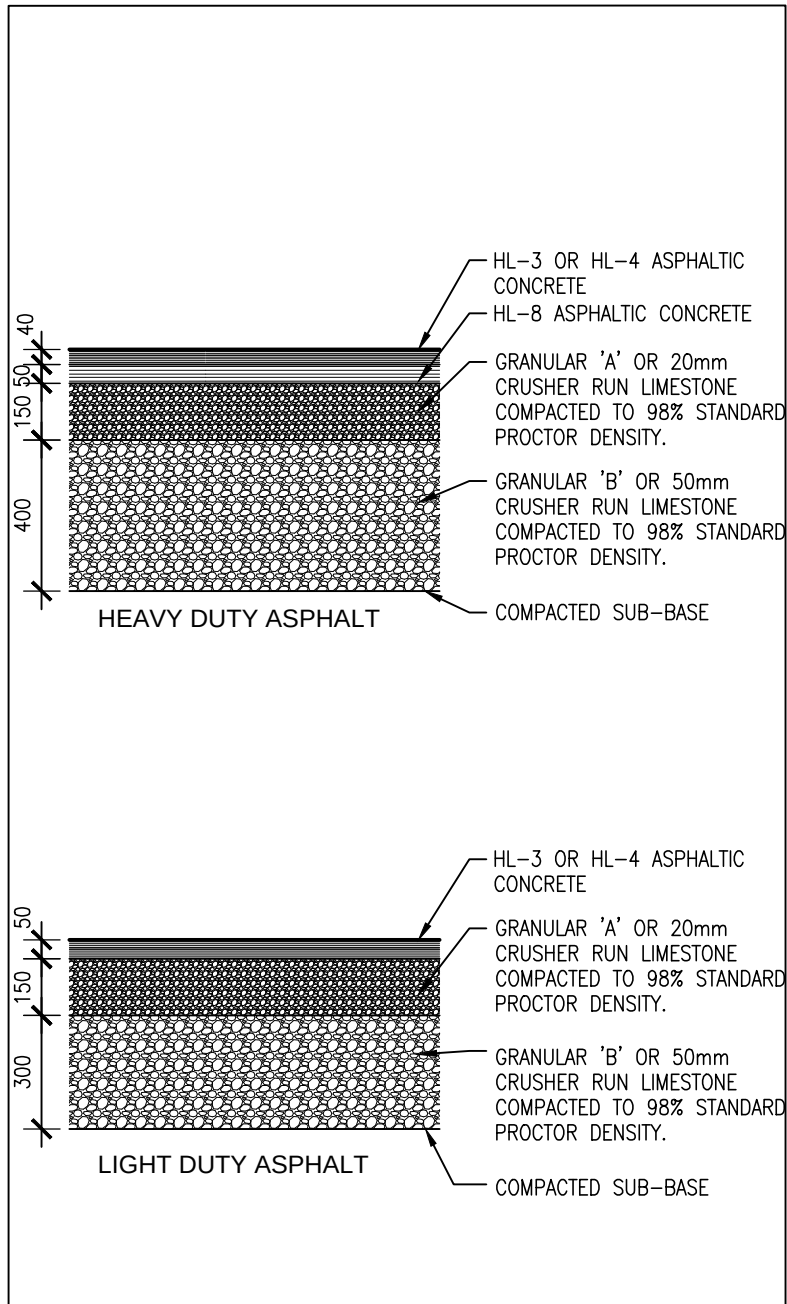


9
A103
ASPHALT COMPOSITION
1:20

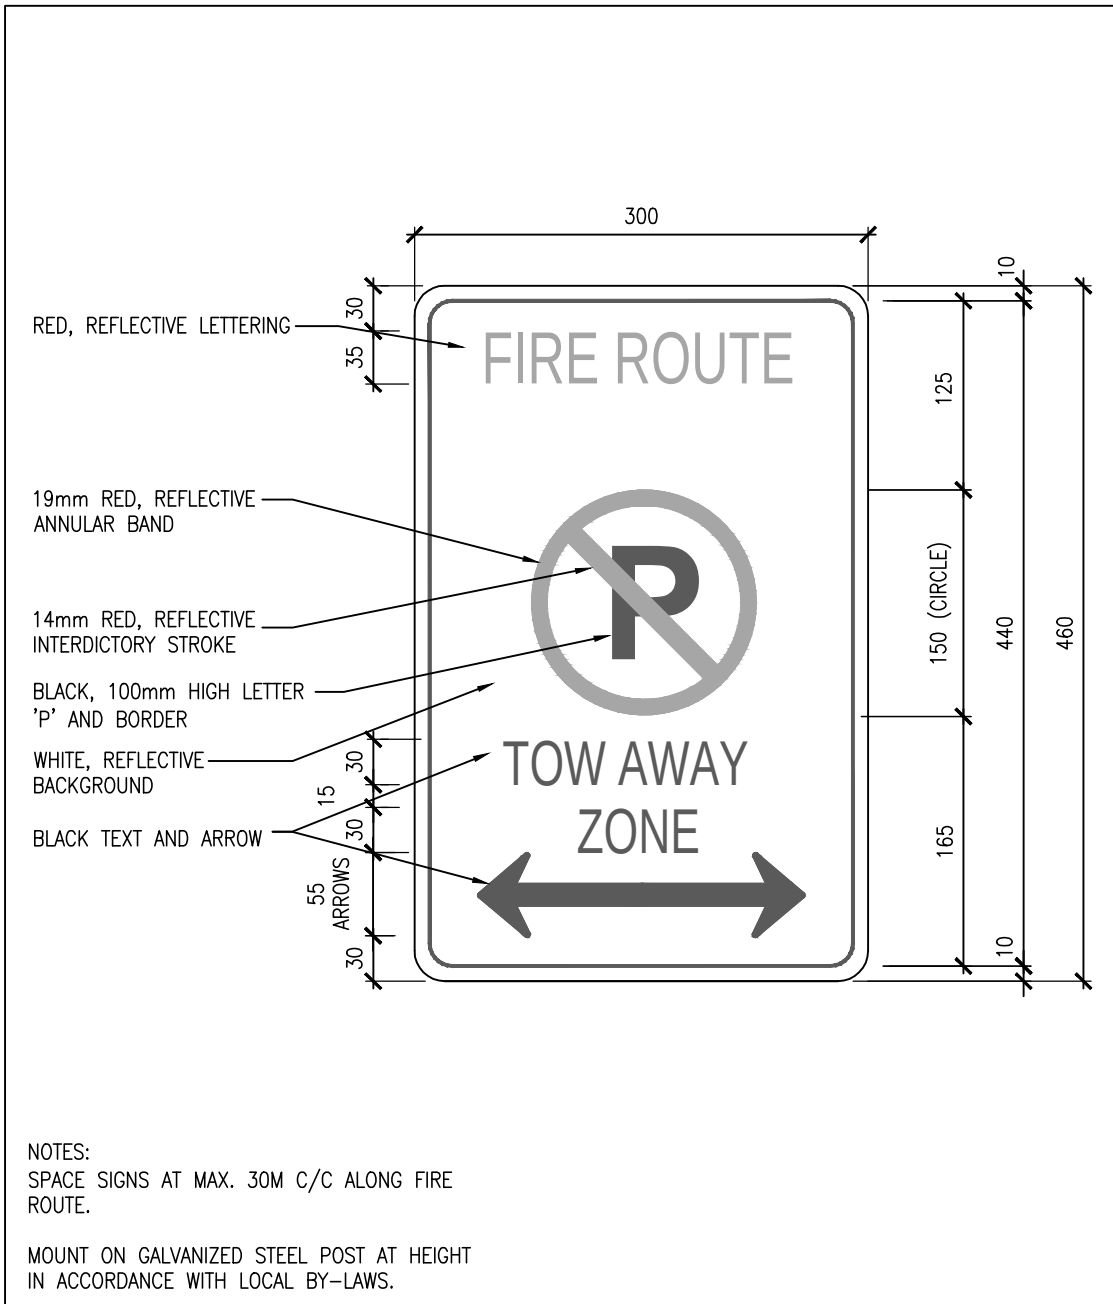


7
A103
FIRE ROUTE SIGN "FR"
1:5

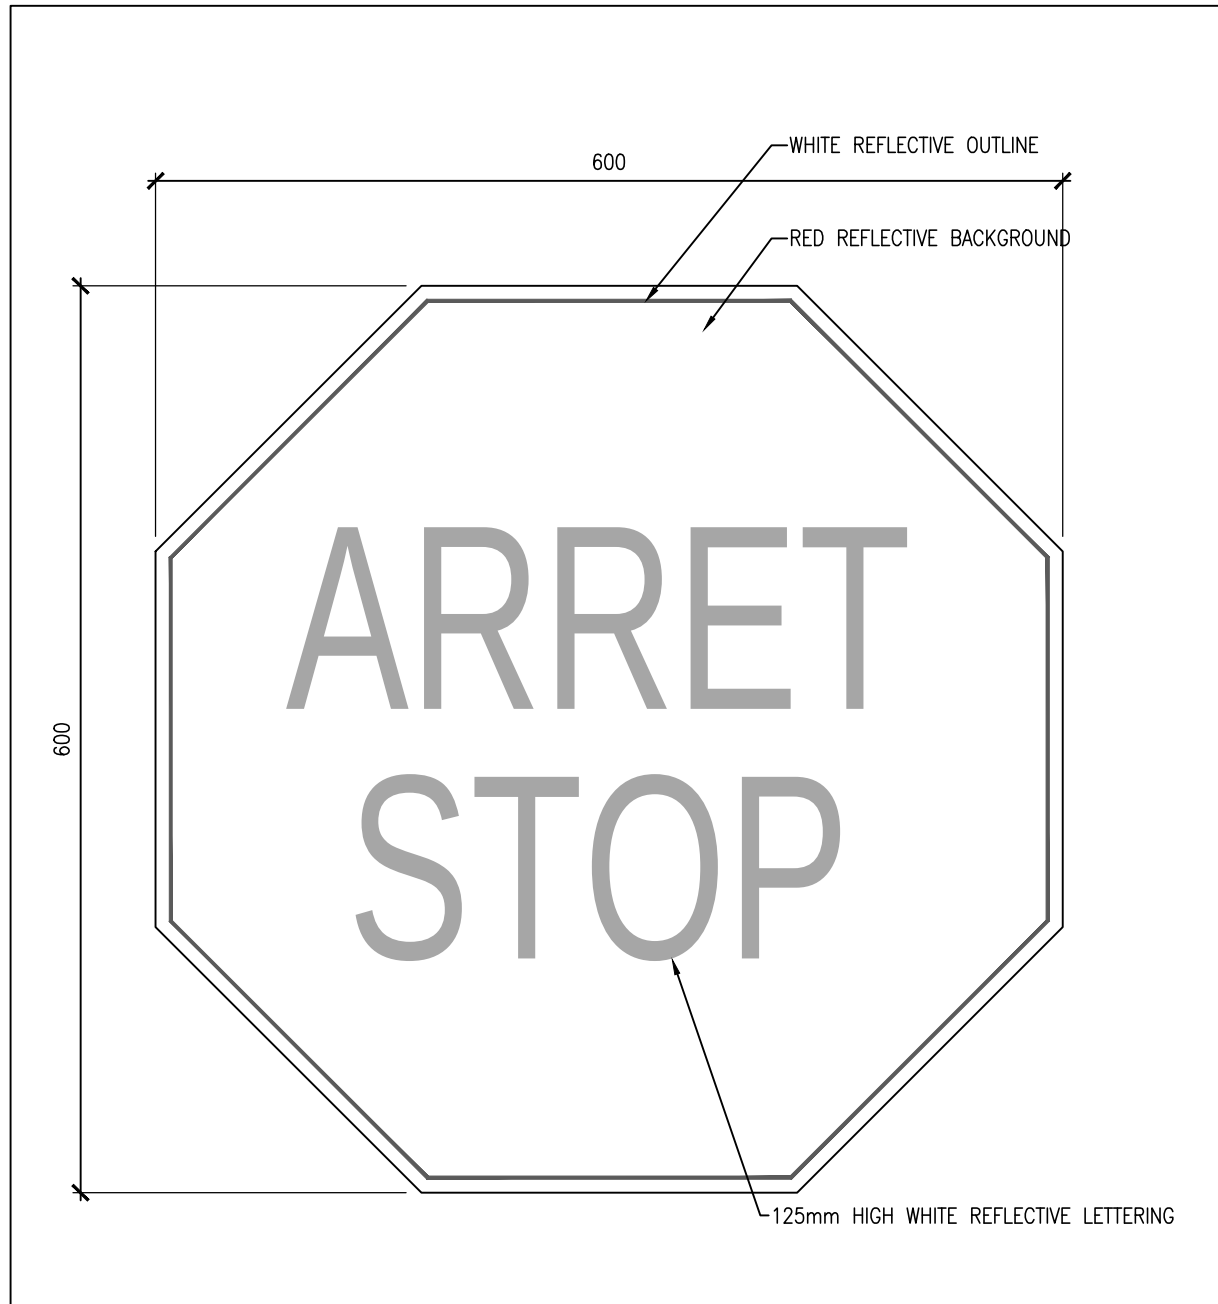


6
A103
STOP SIGN "ST"
1:5

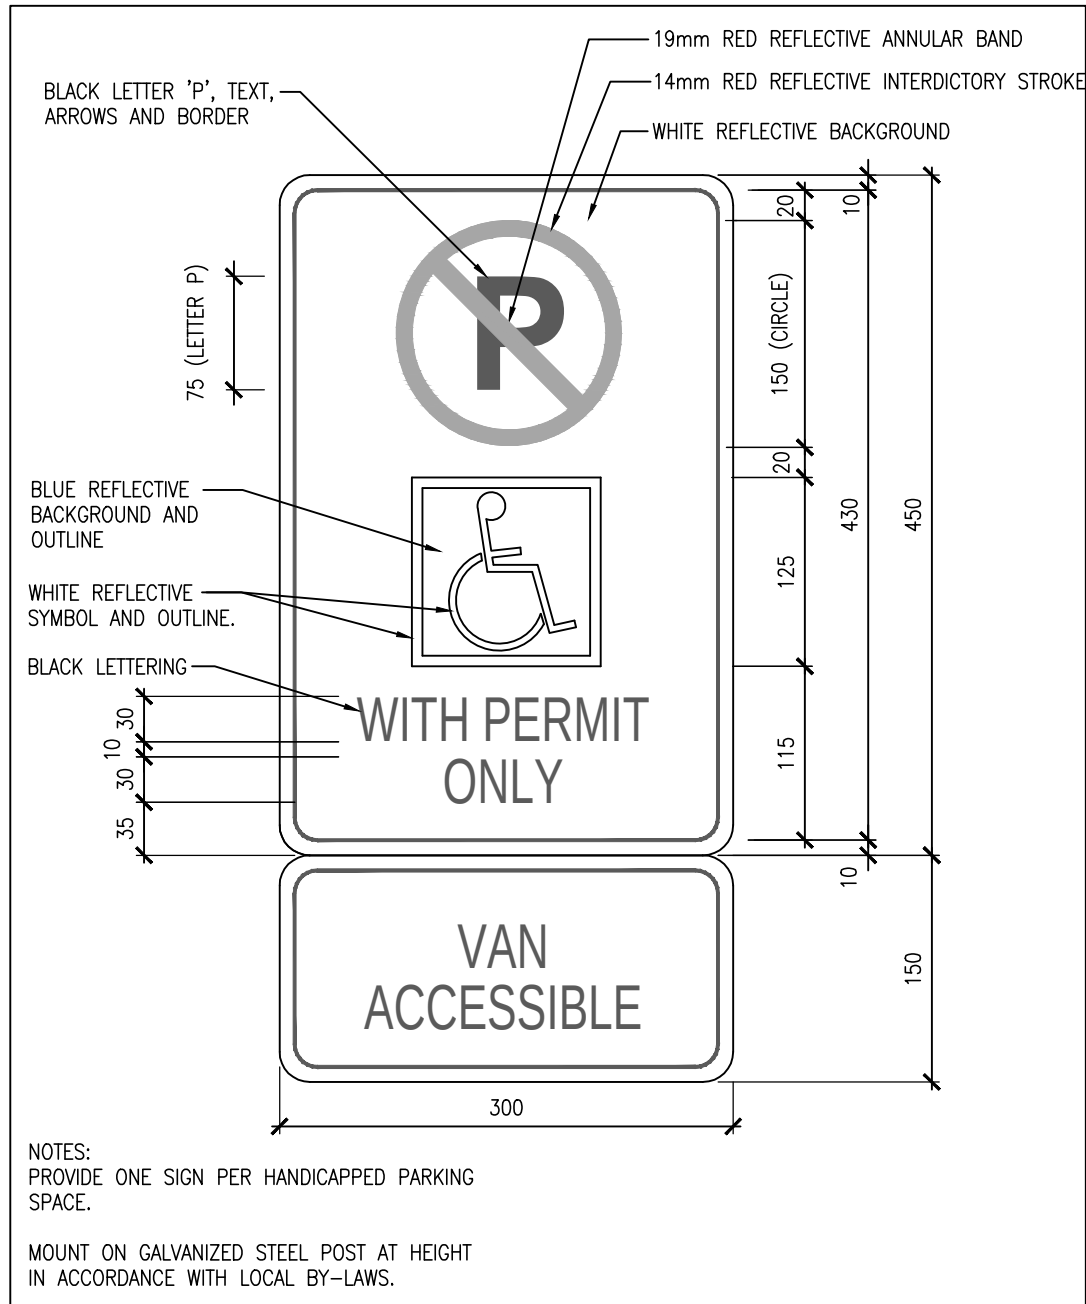


5
A103
BARRIER FREE PARKING SIGN "BF-A"
1:5

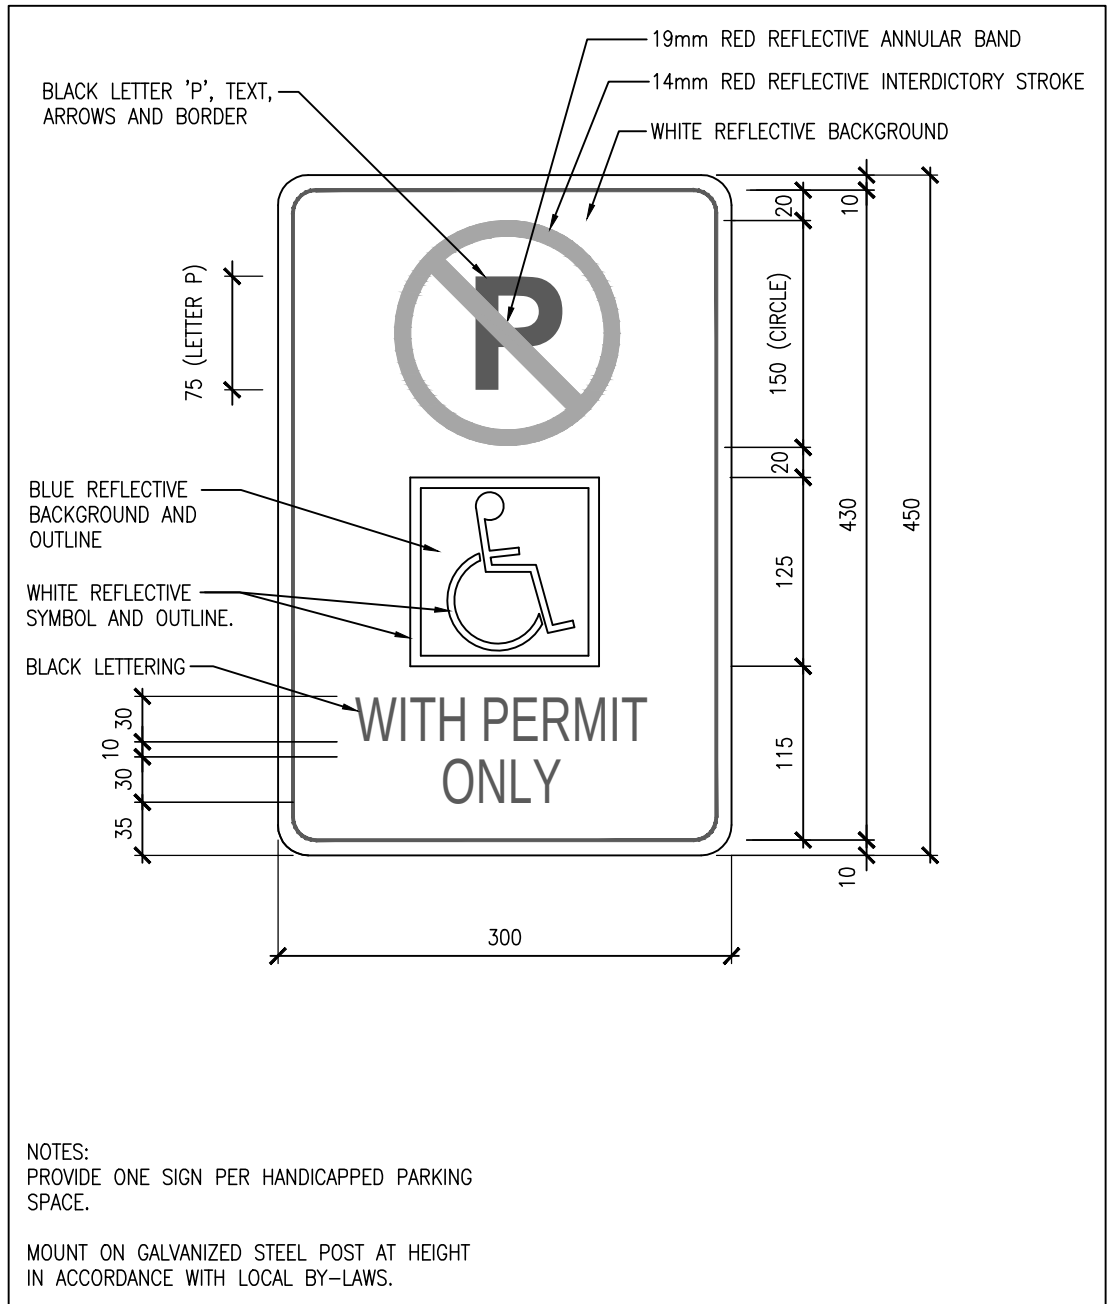


4
A103
BARRIER FREE PARKING SIGN "BF-B"
1:5

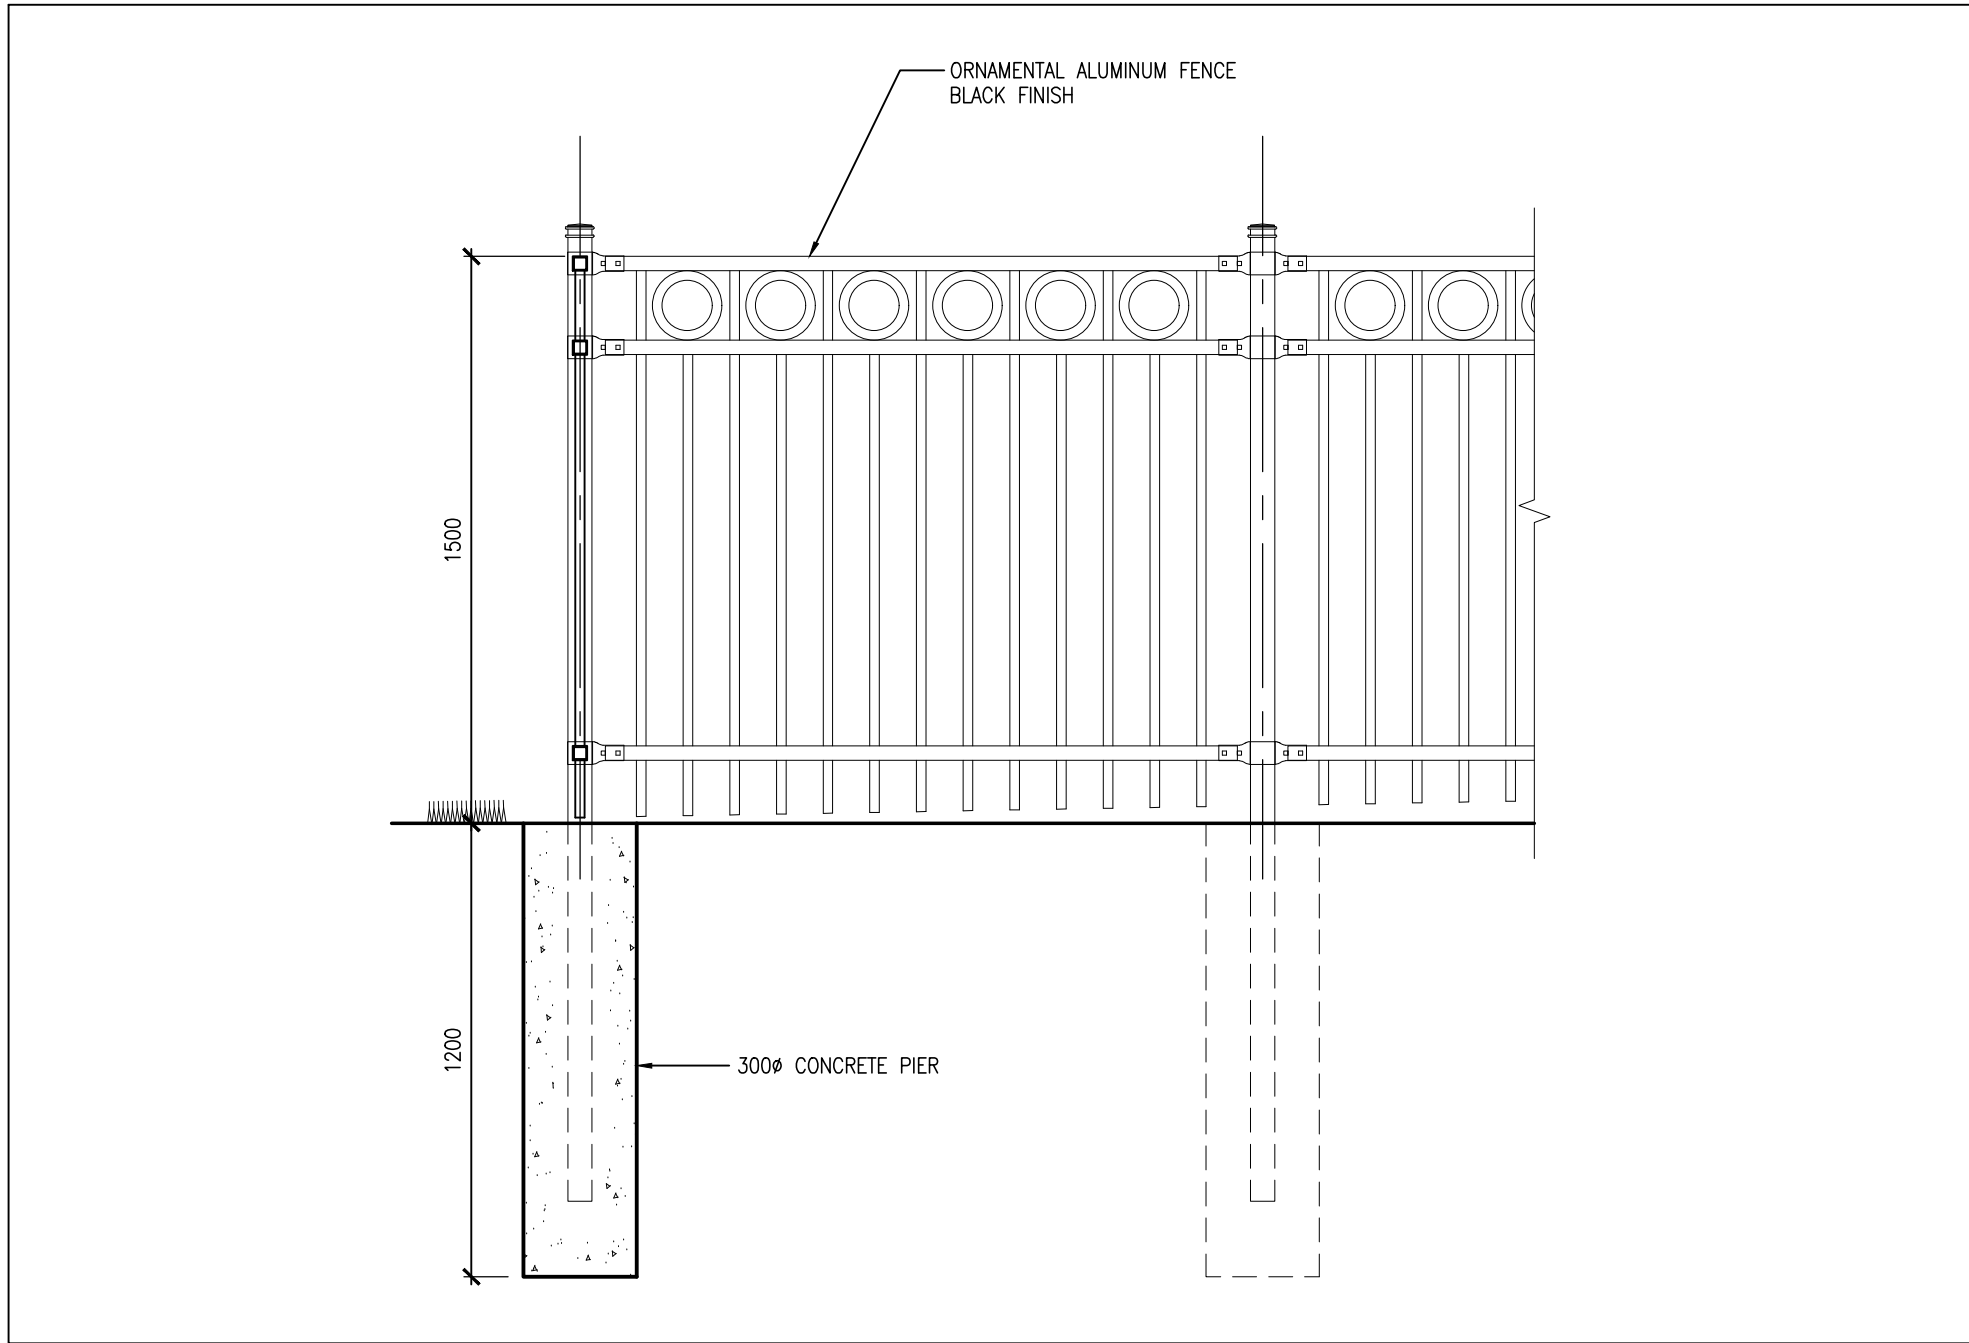


8
A103
ORNAMENTAL FENCE
1:20

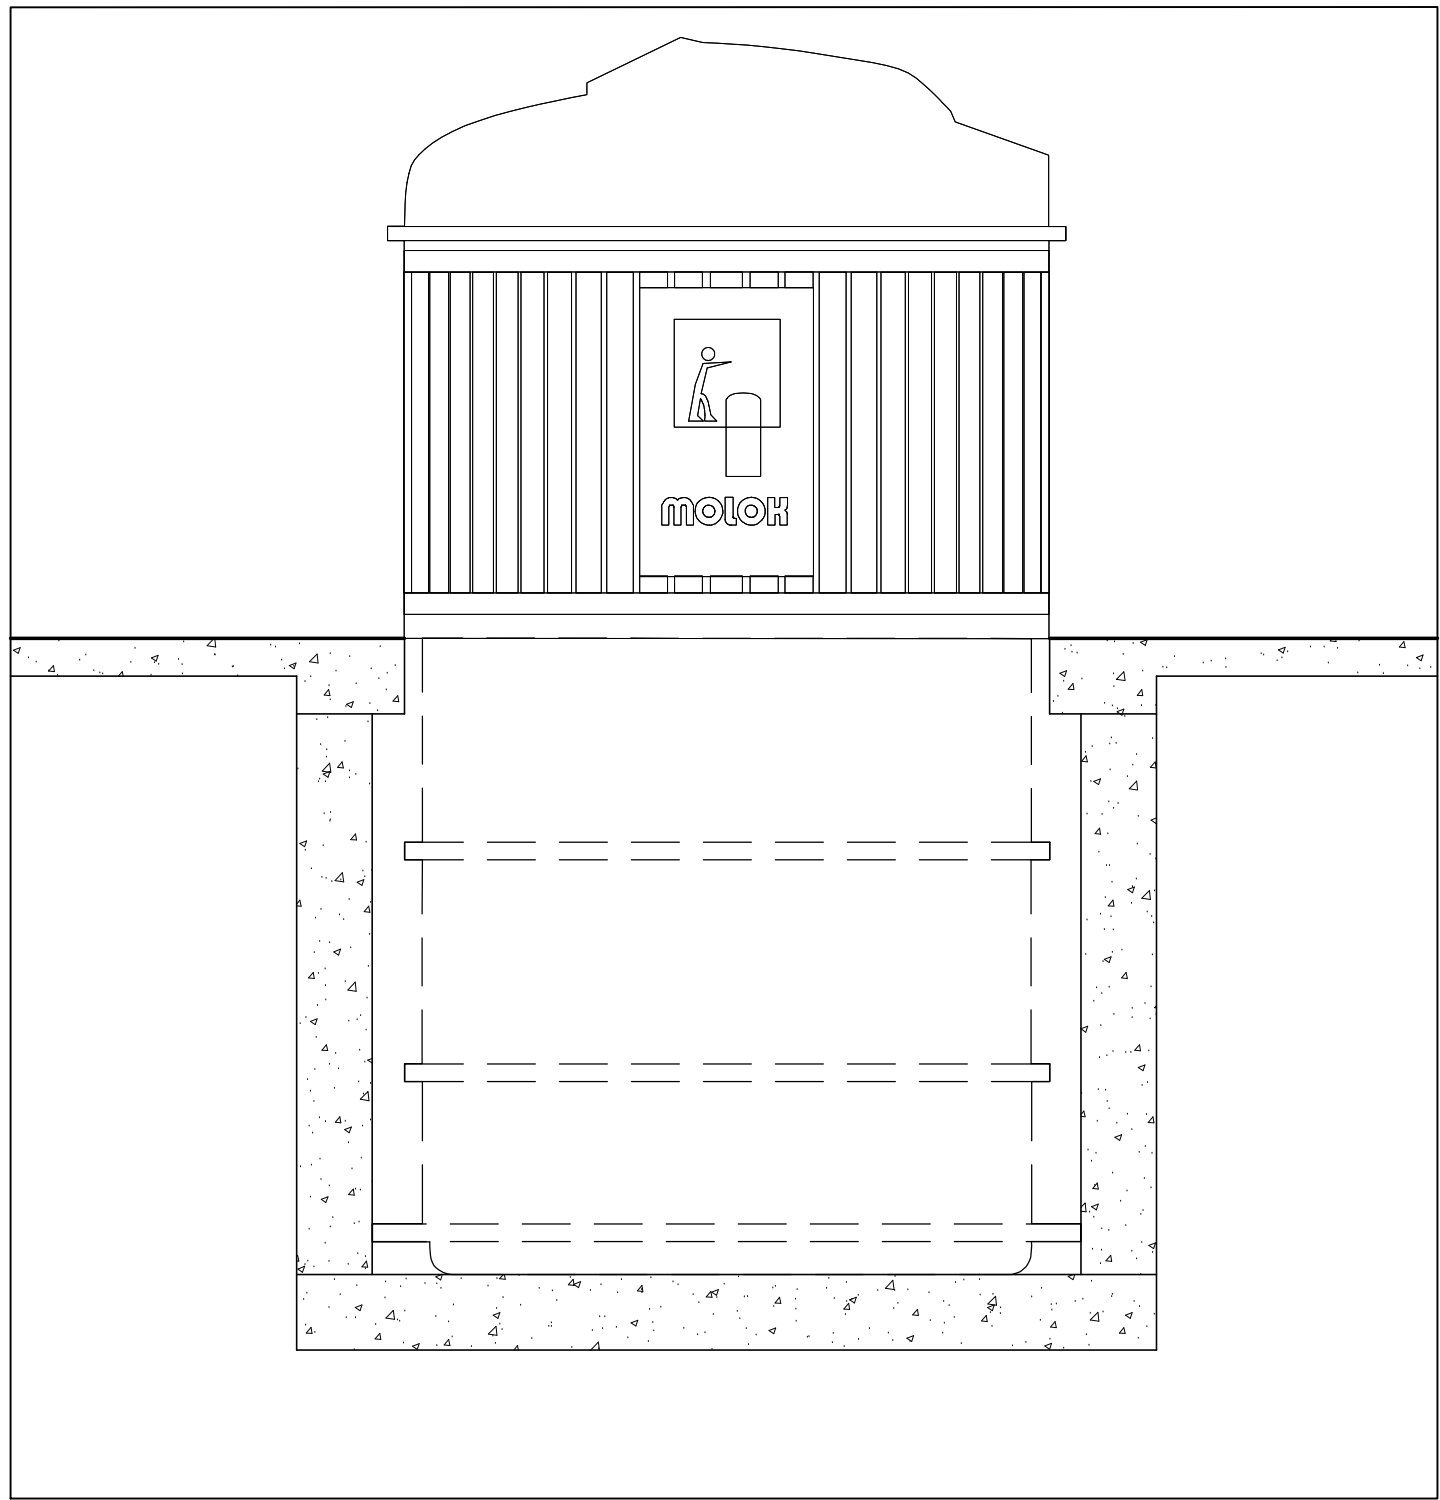

3
A103
GARBAGE BIN
1:20

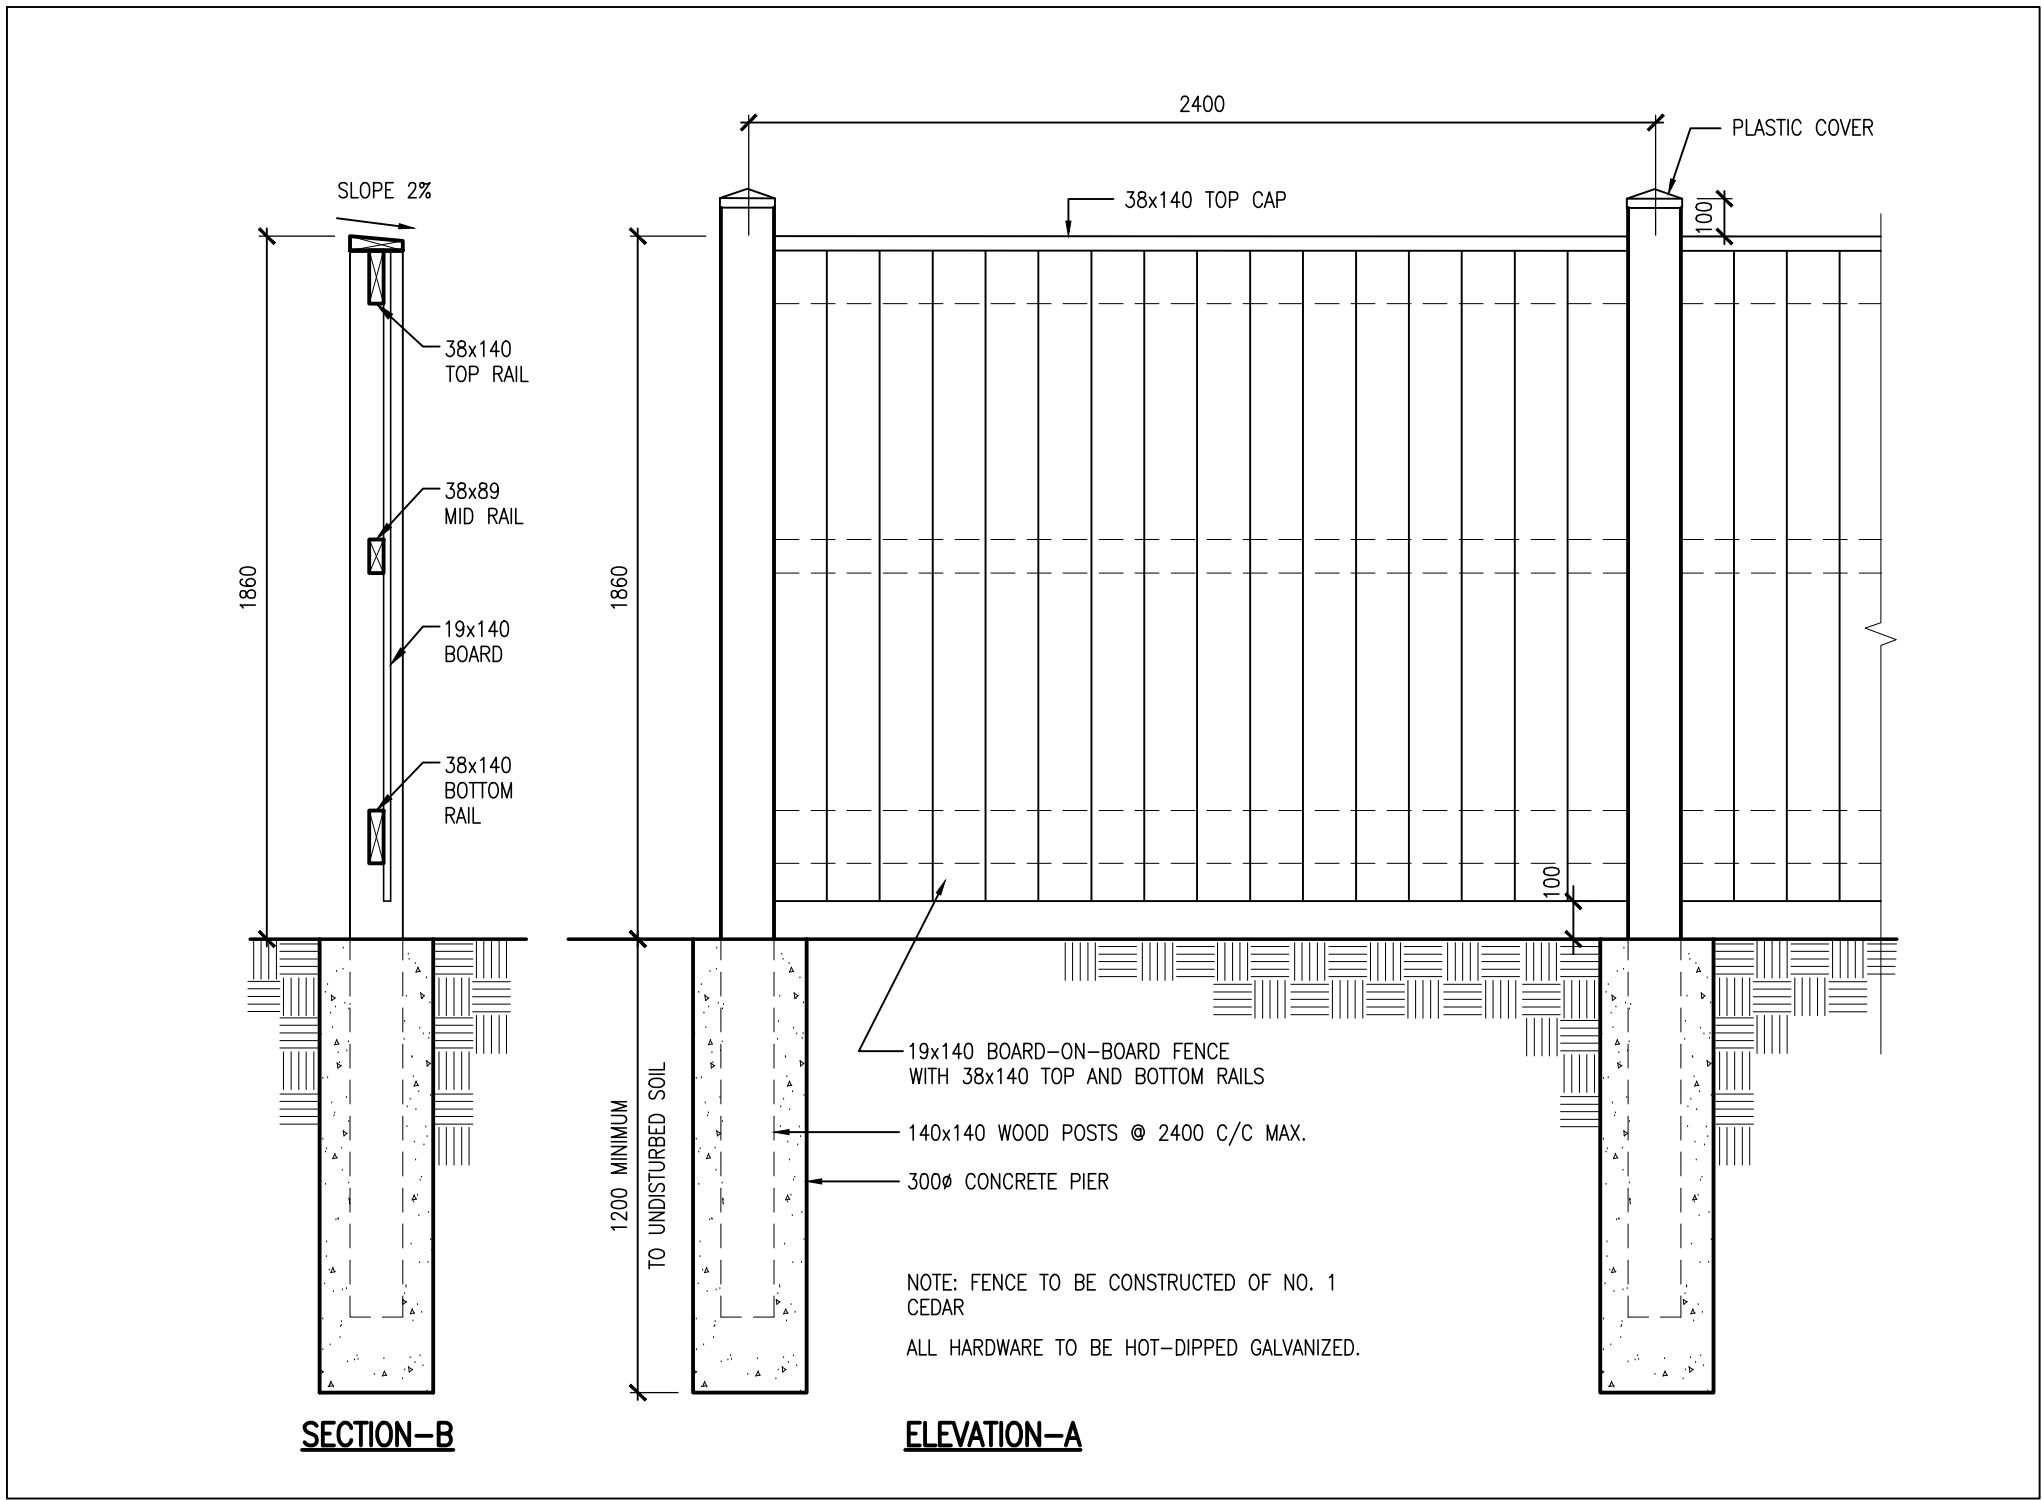

2
A103
WOOD FENCE DETAILS
1:20

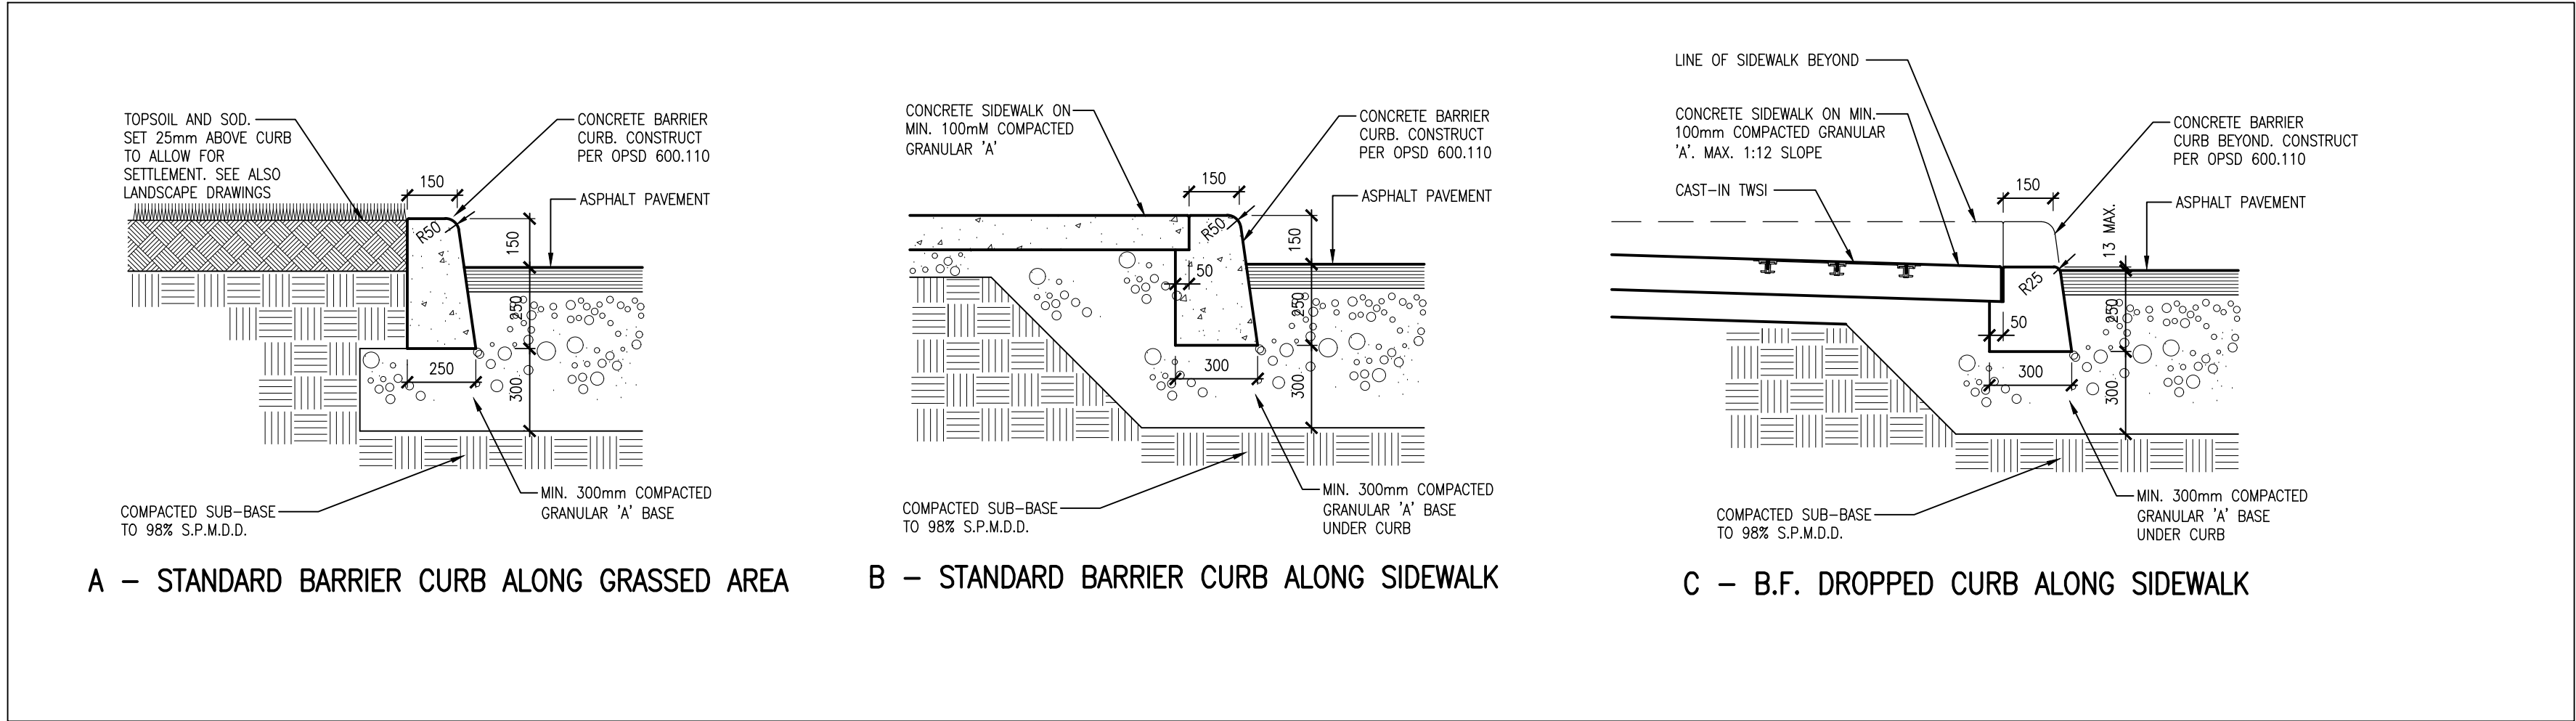

1
A103
TYPICAL CONCRETE CURB DETAILS
1:20


DO NOT SCALE THE DRAWINGS.
CHECK AND VERIFY ALL DIMENSIONS AT THE SITE.
ALL DRAWINGS, SPECIFICATIONS AND RELATED DOCUMENTS ARE THE COPYRIGHT PROPERTY OF THE CONSULTANT AND MUST BE RETURNED UPON REQUEST. REPRODUCTION OF DRAWINGS IN PART OR WHOLE WITHOUT THE PERMISSION OF THE CONSULTANT IS FORBIDDEN.
DRAWINGS ARE NOT TO BE USED FOR CONSTRUCTION UNTIL SIGNED AND SEALED BY THE CONSULTANT.

NO.	ISSUES	DATE	BY
1	ISSUED FOR SITE PLAN APPROVAL	DEC. 07, 2020	BBA

NO.	REVISIONS	DATE	BY
-----	-----------	------	----

PROJECT:
ELGIN PARK REDEVELOPMENT PROJECT
265-327 ELGIN STREET
COBOURG, ON
NORTHUMBERLAND COUNTY

DRAWING:
SITE DETAILS

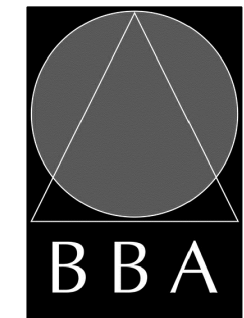

BARRY BRYAN ASSOCIATES
Architects
Engineers
Project Managers
250 Water Street
Suite 201
Whitby, Ontario
L1N 0G5
Tel: (905) 666-5252
Fax: (905) 666-5256
e-mail: bba@bba-archeng.com

DESIGN BY: BBA	DOC. CONTROL: DATE:
DRAWN BY: CM	% COMPLETE:
CHECKED BY:	INITIAL:
DATE: NOV. 2020	SCALE: AS NOTED
FILE:	

PROJECT NO: 19284	DRAWING NO: A103
-----------------------------	----------------------------

19284

Elgin Park

BARRY BRYAN ASSOCIATES
Architects, Engineers, Project Managers
250 Water Street, Whitby, ON
(905) 666-5252
E-mail:

Elgin Park Development - Total Unit Breakdown											
Unit Types	Number of Beds	Accessible/ Accessible Ready	Area m²	Area sqft	Level	Building 1	Building 2	Building 3	Building 4		Totals/ Number of Bedroom
1 Bedroom											Total 1 Bed
1A	1 Bed	Accessible	53 m²	571	Ground	103	202		403		
1A-1(R)	1 Bed	Accessible	53 m²	571	Ground			305			
1B	1 Bed	NO	60m²	646	Second	108	208		408		
1B-1(R)	1 Bed	NO	60m²	646	Second			308			
1C	1 Bed	NO	46.8m²	502	Ground		203		404	3	Accessible
1C-1(R)	1 Bed	NO	46.8m²	502	Ground			304		1	Accessible Ready
1D	1 Bed	NO	52.3m²	561	Second		208		408	10	Non Accessible
1D-1(R)	1 Bed	NO	52.3m²	561	Second			308		14	1 Bed Units
2 Bedroom											Total 2 Bed
2A	2 Bed	Accessible	70.4m²	758	Ground	105	204		405		
2A-1(R)	2 Bed	Accessible	70.4m²	758	Ground			303		2	Accessible
2B	2 Bed	NO	70.4m²	758	Ground	104				2	Accessible Ready
2C	2 Bed	NO	80m²	861	Second	108, 110	210		410	6	Non Accessible
2C-1(R)	2 Bed	NO	80m²	861	Second			307		10	2 Bed Units
3 Bedroom											Total 3 Bed
3A-TH	3 Bed	NO	88.6m²	965	Townhome	102		302	402		
3A-1 - TH(R)	3 Bed	NO	88.6m²	965	Townhome	108	205		408		
3B	3 Bed	Accessible	95m²	1023	Flat		201			2	Accessible
3B-1(R)	3 Bed	Accessible	95m²	1023	Flat			308		0	Accessible Ready
3C	3Bed	NO	112m²	1205	Flat		207			8	Non Accessible
3C-1(R)	3Bed	NO	112m²	1205	Flat			310		10	3 Bed Units
4 Bedroom											Total 4 Bed
4A-TH	4 Bed	Accessible	108.1m²	1164	Townhome			301		2	Accessible
4A-1-TH(R)	4 Bed	Accessible	108.1m²	1164	Townhome		208			0	Accessible Ready
4B-TH	4 Bed	Accessible	108.1m²	1164	Townhome	101		301	401	4	Non Accessible
4B-1-TH(R)	4 Bed	Accessible	108.1m²	1164	Townhome	107	208		407	6	Total Units

Legend

Non Accessible Unit
Accessible Unit
Accessible Ready Unit

NAME OF CONSULTANT : BARRY BRYAN ASSOCIATES
CERTIFICATE OF PRACTICE NUMBER : 5192
250 WATER STREET, SUITE 901
WHITBY, ONTARIO, CANADA L1N 0G5
TEL : (905) 666 - 5252
(Toronto) (905) 427 - 4495
FAX : (905) 666 - 5258

NAME OF PROJECT :
ELGIN PARK REDEVELOPMENT
BUILDING 5

LOCATION OF PROJECT :
265 - 327 ELGIN STREET,
COBOURG, ONTARIO

DATE :
NOVEMBER 6, 2020

	Ontario Building Code Data Matrix Part 9 Housing and Small Buildings	OBC Reference
9.00	Building Code Version: O_Reg_332/12 Last Amendment: O_Reg_191/14	
9.01	Project Type: ☒ New ☐ Addition ☐ Renovation ☐ Change of use ☐ Addition and Renovation	[A] 1.1.2.
9.02	Major Occupancy Classification: <u>Occupancy D</u> Use <u>BUSINESS AND PERSONAL SERVICES</u>	9.10.2
9.03	Superimposed Major Occupancies: ☐ Yes ☒ No	9.10.2.3
9.04	Building Area (m²) Description Existing New Total Total=	[A] 1.4.1.2.
9.05	Gross Area (m²) Description GROUND FLOOR Existing New Total Total=	[A] 1.4.1.2.
9.06	Mezzanine Area (m²) Description N/A Existing New Total Total=	9.10.4.1
9.07	Building Height <u>1</u> Storeys above grade (m) Above grade Storeys below grade	[A] 1.4.1.2 & 9.10.4. 9.10.4.
9.08	Number of streets/ fire fighter access: <u>1</u> street(s)	
9.09	Sprinkler System ☐ Required ☒ Not Required Proposed: ☐ entire building ☐ selected compartments ☐ selected floor areas ☐ basement ☐ in lieu of roof rating ☒ none	9.10.8.2.4
9.10	Fire Alarm System ☐ Required ☒ Not Required	9.10.18
9.11	Water Service/ Supply is Adequate ☒ Yes ☐ No	
9.12	Construction Type: Restriction: ☒ Combustible Permitted ☐ Non-combustible Required Actual: ☐ Combustible ☐ Non-combustible ☒ Combination Heavy Timber Construction ☒ No ☐ Yes	9.10.6
9.13	Post-disaster Building ☒ No ☐ Yes	[A] 1.1.2.2.(2)
9.14	Occupant Load: <u>Floor Level/ Area</u> Occupancy Type Based On Occup. Load GROUND FLOOR <u>14</u>	3.1.17
9.15	Barrier-free Design: ☒ Yes ☐ No Explanation	9.5.2
9.16	Hazardous Substances ☐ Yes ☒ No Explanation	9.10.1.3
9.17	Required Fire Resistance Ratings: Horizontal Assembly Rating Supporting Assembly (ft) Non combustible in lieu of rating? Floors over basement ☐ No ☐ Yes ☐ N/A Floors ☐ No ☐ Yes ☐ N/A Mezzanine ☐ No ☐ Yes ☐ N/A Roof ☐ No ☐ Yes ☐ N/A	9.10.8
9.18	Spatial Separation: Wall EBF Area L.D. (m) L/H or Permitted Max. % of Openings Proposed % of Openings Cladding Type SOUTH 41 20 - N/A 18% ☐ Noncombustible ☐ Noncombustible NORTH 41 16 - N/A 27% ☐ Noncombustible ☐ Noncombustible WEST 28 3 - 23% 14% ☐ Noncombustible ☐ Noncombustible EAST 28 3 - 23% 14% ☐ Noncombustible ☐ Noncombustible Insert additional lines as needed	9.10.14., 9.10.15
9.19	Plumbing Fixture Requirements: Ratio: Male/Female = 50:50 Except as noted otherwise Floor level/ Area Occupant Load OBC Reference Fixtures Required Fixtures Provided SINK 1 LAVATORY 1 WATER CLOSET 1 Insert additional lines as needed	9.31 & 3.7.4
9.20	Energy Efficiency: Category: Residential Compliance Option: ☐ SB-10 Prescriptive (Div. 4) ☐ SB-10 Performance (Div. 2) ☐ SB-10 Prescriptive (Div. 2) Non-Residential Compliance Option: ☐ SB-12 Prescriptive Compliance Packages ☐ SB-12 Performance Compliance ☐ SB-12 Other: Energy Star for New Homes ☐ EnerGuide for New Houses Project Design Conditions: Climatic Zone: _____ Fenestration Gross Above Grade Wall or Roof Area (m²) Gross Fenestration Area (m²) Fenestration Ratio Vertical (W+D) _____ Skylights _____ Space Heating Fuel ☐ Natural Gas ☐ Oil ☐ Electricity ☐ Propane ☐ Solid fuel ☐ Earth energy Heating Equipment Efficiency ☐ ≥90% AFUE ☐ ≥78% - ≥90% AFUE Other Conditions ☐ ICF Basement ☐ ICF Above Grade ☐ Walk-out Basement ☐ Slab-on-Ground ☐ Log/Post & Beam ☐ Blow-in Insulation Above Grade Wall ☐ Spray-applied Foam Insulation Above Grade Wall ☐ Drain Water Heat Recovery Unit Provide Compliance Package _____	12.2.1
3.25	Notes:	

DO NOT SCALE THE DRAWINGS
CHECK AND VERIFY ALL DIMENSIONS AT THE SITE.

ALL DRAWINGS, SPECIFICATIONS AND RELATED DOCUMENTS ARE THE
COPYRIGHT PROPERTY OF THE CONSULTANT AND MUST BE RETURNED
UPON REQUEST. REPRODUCTION OF DRAWINGS IN PART OR WHOLE
WITHOUT THE PERMISSION OF THE CONSULTANT IS FORBIDDEN.

DRAWINGS ARE NOT TO BE USED FOR CONSTRUCTION UNTIL SIGNED
AND SEALED BY THE CONSULTANT.

No.	ISSUES	DATE	BY
1	ISSUED FOR REZONING	20/06/30	BBA
2	ISSUED FOR SPA	20/12/07	BBA

No.	REVISIONS	DATE	BY
-----	-----------	------	----

PROJECT:

ELGIN PARK REDEVELOPMENT PROJECT

265 - 327 ELGIN STREET
COBOURG, ONTARIO
NORTHUMBERLAND COUNTY

DRAWING:

OBC MATRIX



BARRY BRYAN
ASSOCIATES

Architects
Engineers
Project Managers

201-250 Water Street
Whitby Ontario L1N 0G5
Tel: (905) 666-5252
Fax: (905) 666-5258
e-mail: bba@bba-archeng.com

DESIGN BY: BBA

DRAWN BY: NV

CHECKED BY: NS

DATE: 11/04/20

SCALE: 1 : 5


FILE:

PROJECT NO:


19284

DRAWING NO:

A002

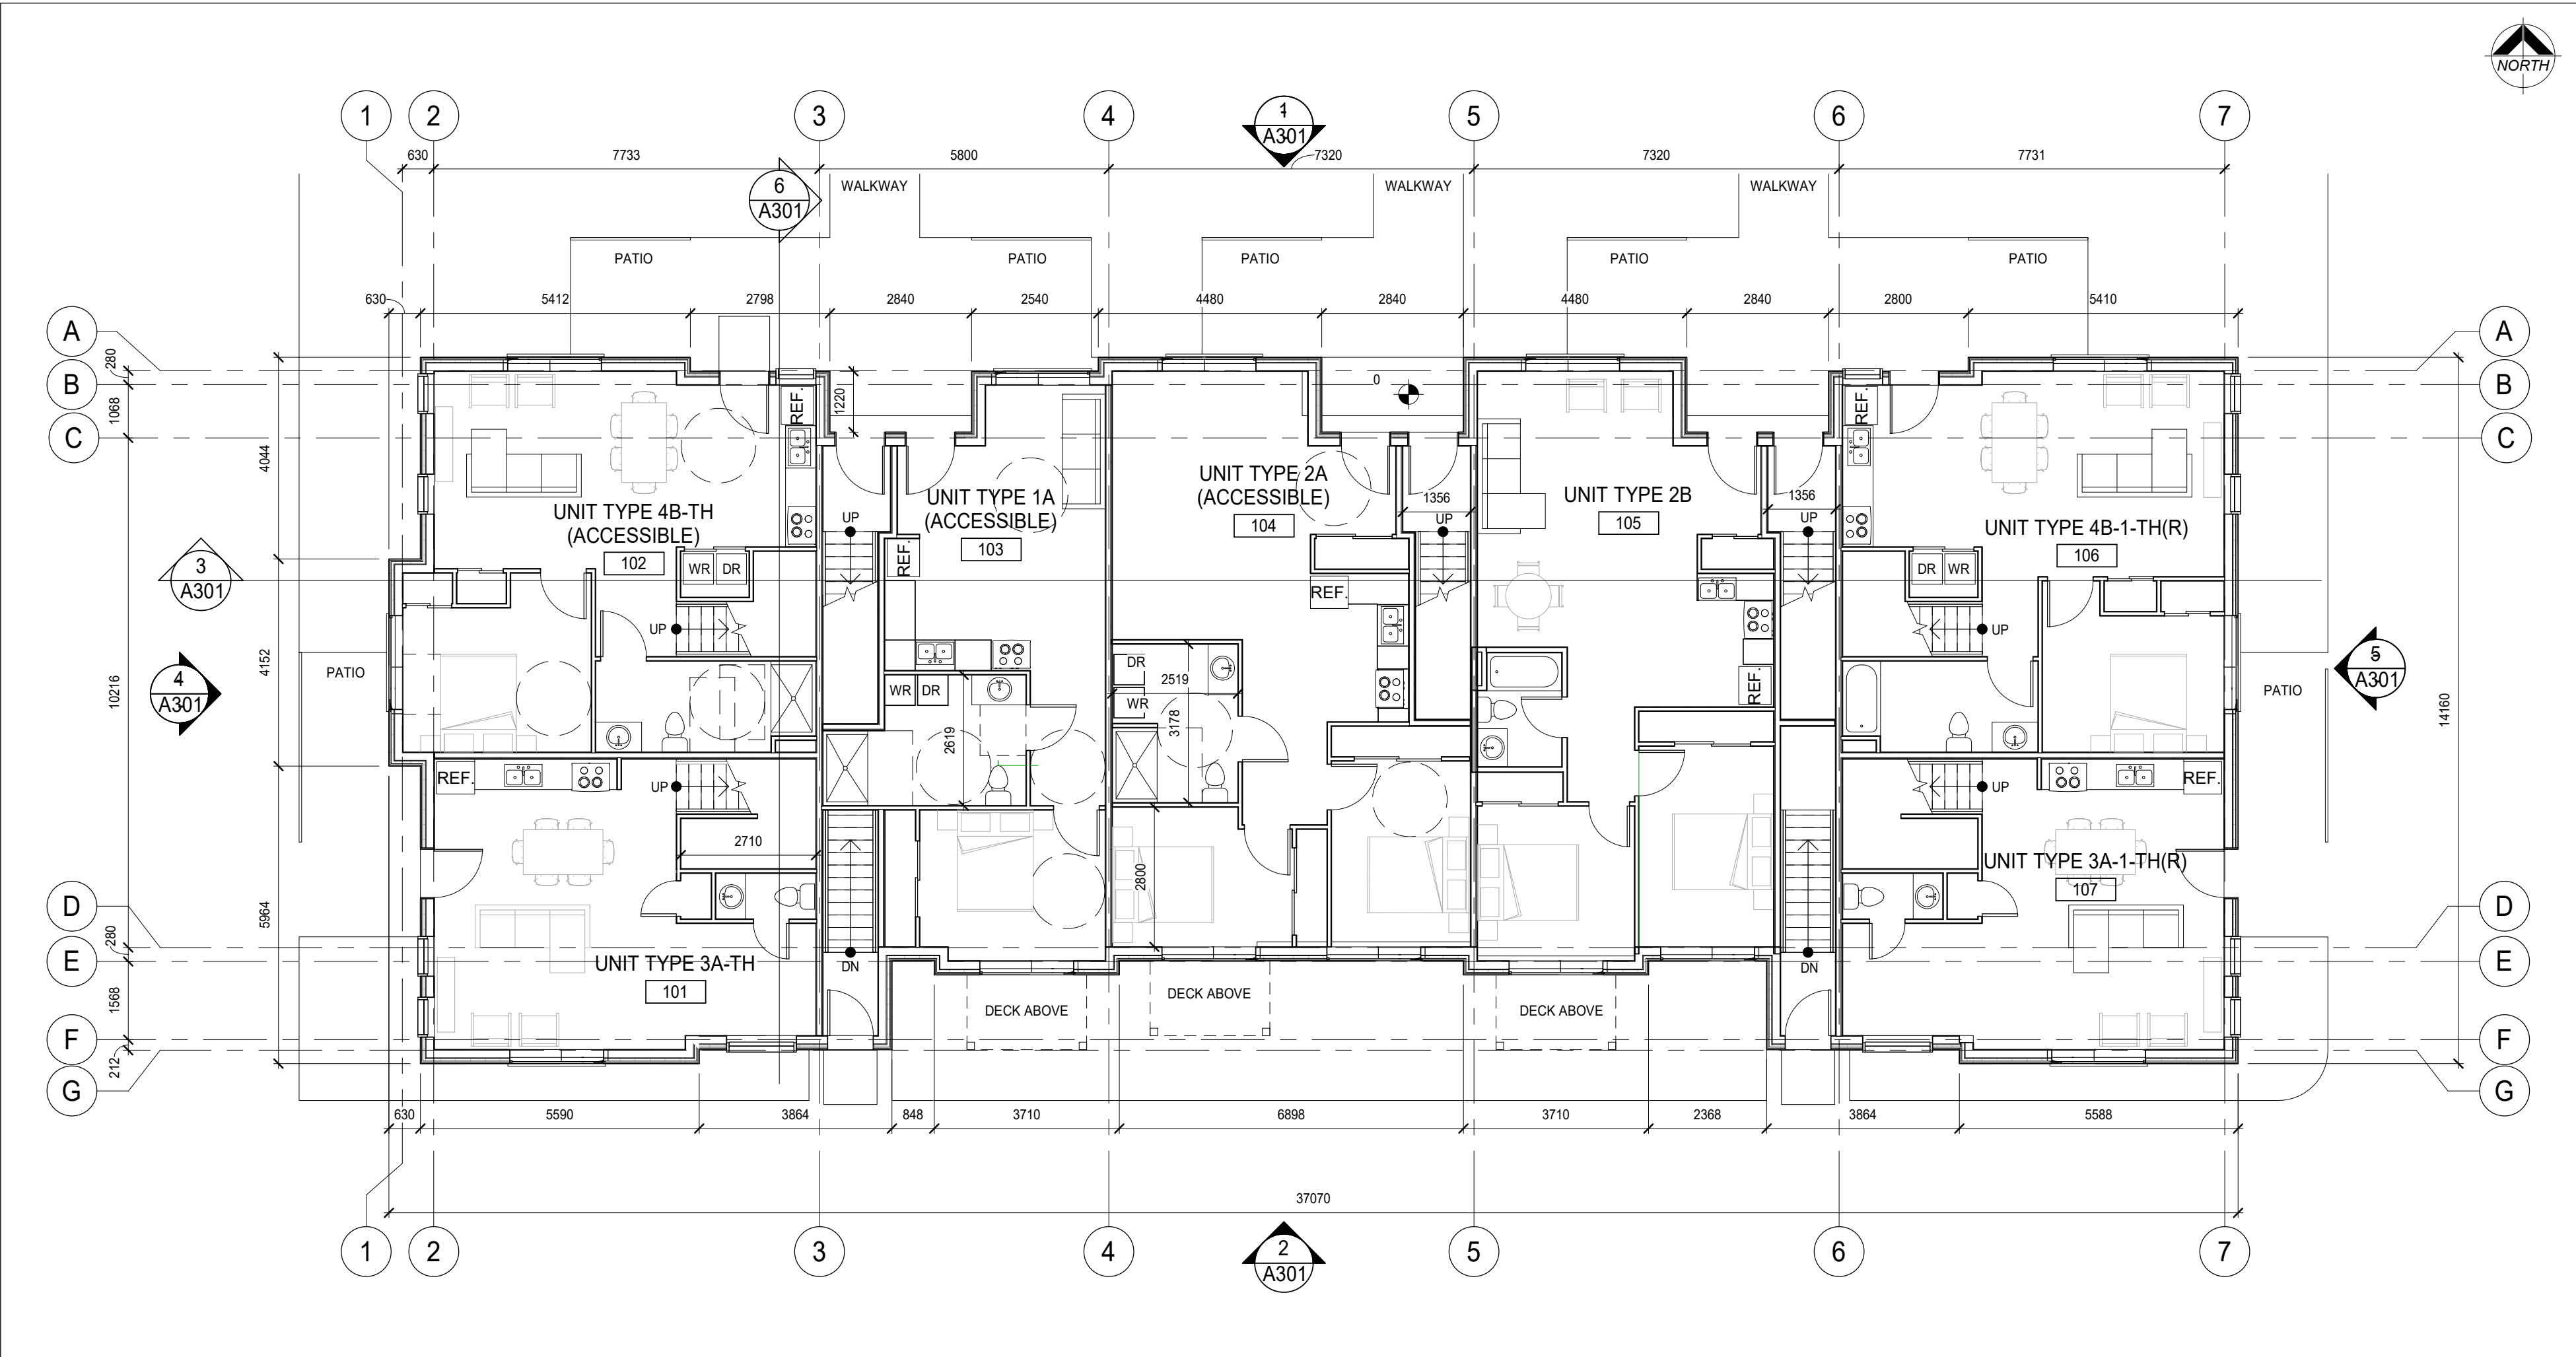

2 BUILDING 1 GROUND FLOOR
1:100

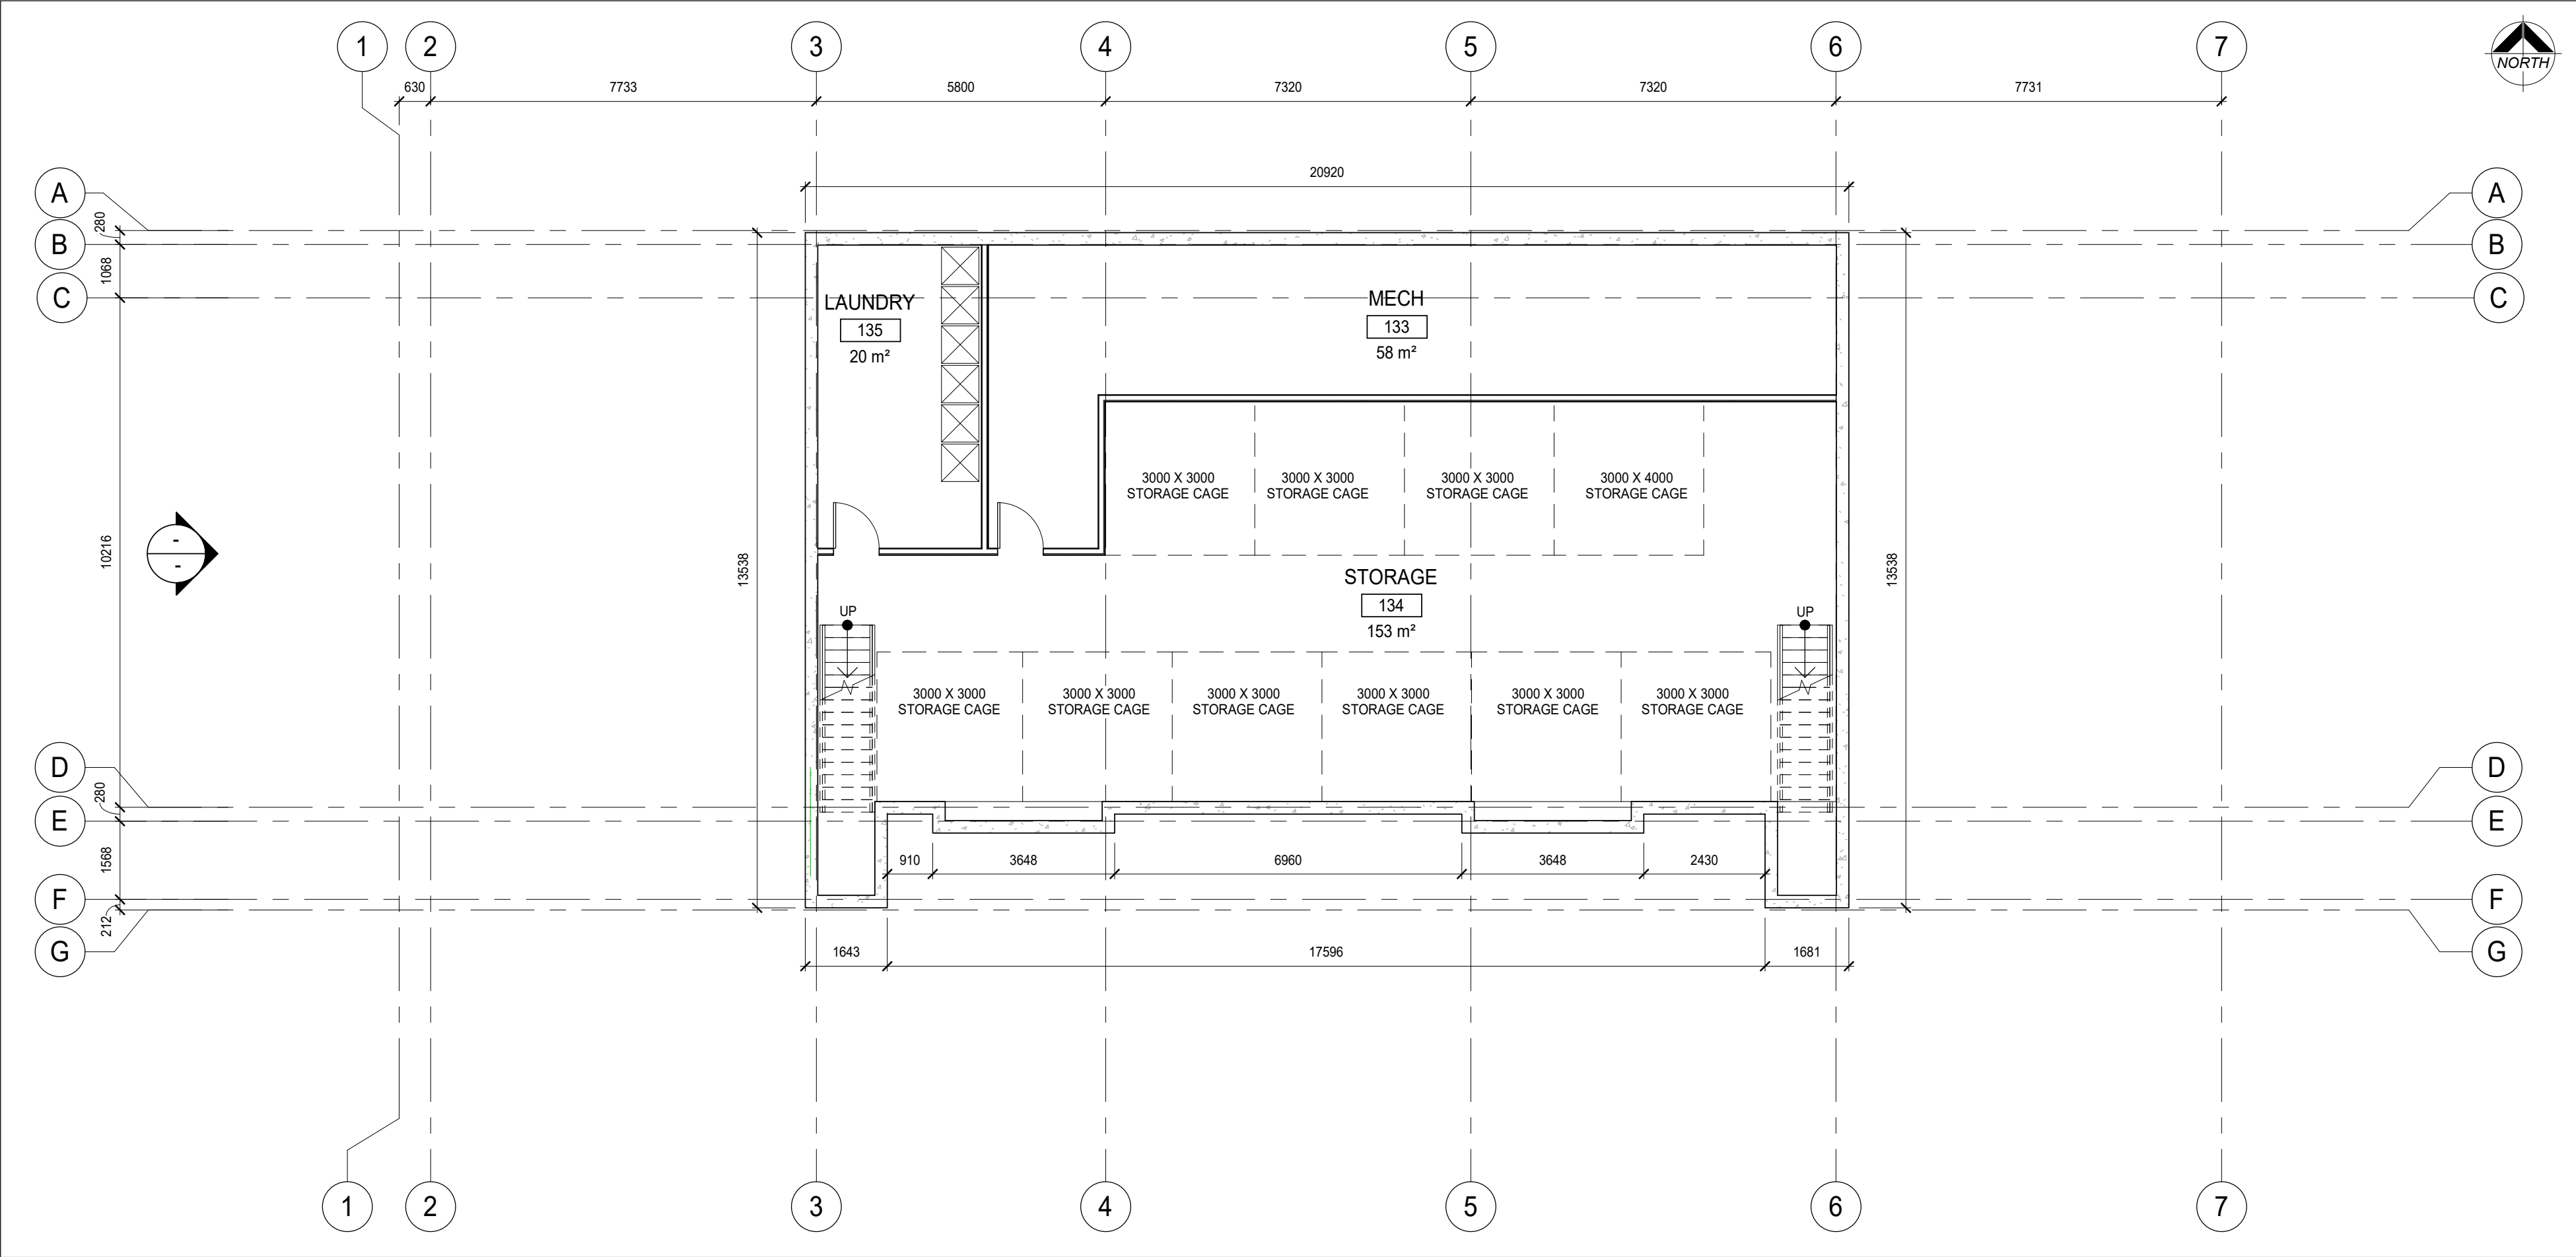

1 BUILDING 1 BASEMENT FLOOR
1:100

DO NOT SCALE THE DRAWINGS
CHECK AND VERIFY ALL DIMENSIONS AT THE SITE.
ALL DRAWINGS, SPECIFICATIONS AND RELATED DOCUMENTS ARE THE
COPYRIGHT PROPERTY OF THE CONSULTANT AND MUST BE RETURNED
UPON REQUEST. REPRODUCTION OF DRAWINGS IN PART OR WHOLE
WITHOUT THE PERMISSION OF THE CONSULTANT IS FORBIDDEN.
DRAWINGS ARE NOT TO BE USED FOR CONSTRUCTION UNTIL SIGNED
AND SEALED BY THE CONSULTANT.

NO.	ISSUES	DATE	BY
1	ISSUED FOR REZONING	20/06/30	BBA
2	ISSUED FOR SPA	20/12/07	BBA

NO.	REVISIONS	DATE	BY

PROJECT:
**ELGIN PARK
REDEVELOPMENT
PROJECT**

265 - 327 ELGIN STREET
COBOURG, ONTARIO
NORTHUMBERLAND COUNTY

DRAWING:
**BUILDING 1, BASEMENT
& GROUND FLOOR PLAN**




**BARRY BRYAN
ASSOCIATES**

*Architects
Engineers
Project Managers*


DESIGN BY: BBA	DOC CONTROL DATE:
DRAWN BY: NV	% COMPLETE:
CHECKED BY: NS	INITIAL:
DATE: 10/26/20	SCALE: 1 : 100
201-250 Water Street Whitby Ontario L1N 0G5 Tel: (905) 666-5252 Fax: (905) 666-5256 e-mail: bba@bba-archeng.com	FILE:

PROJECT NO:
19284

DRAWING NO:
A201

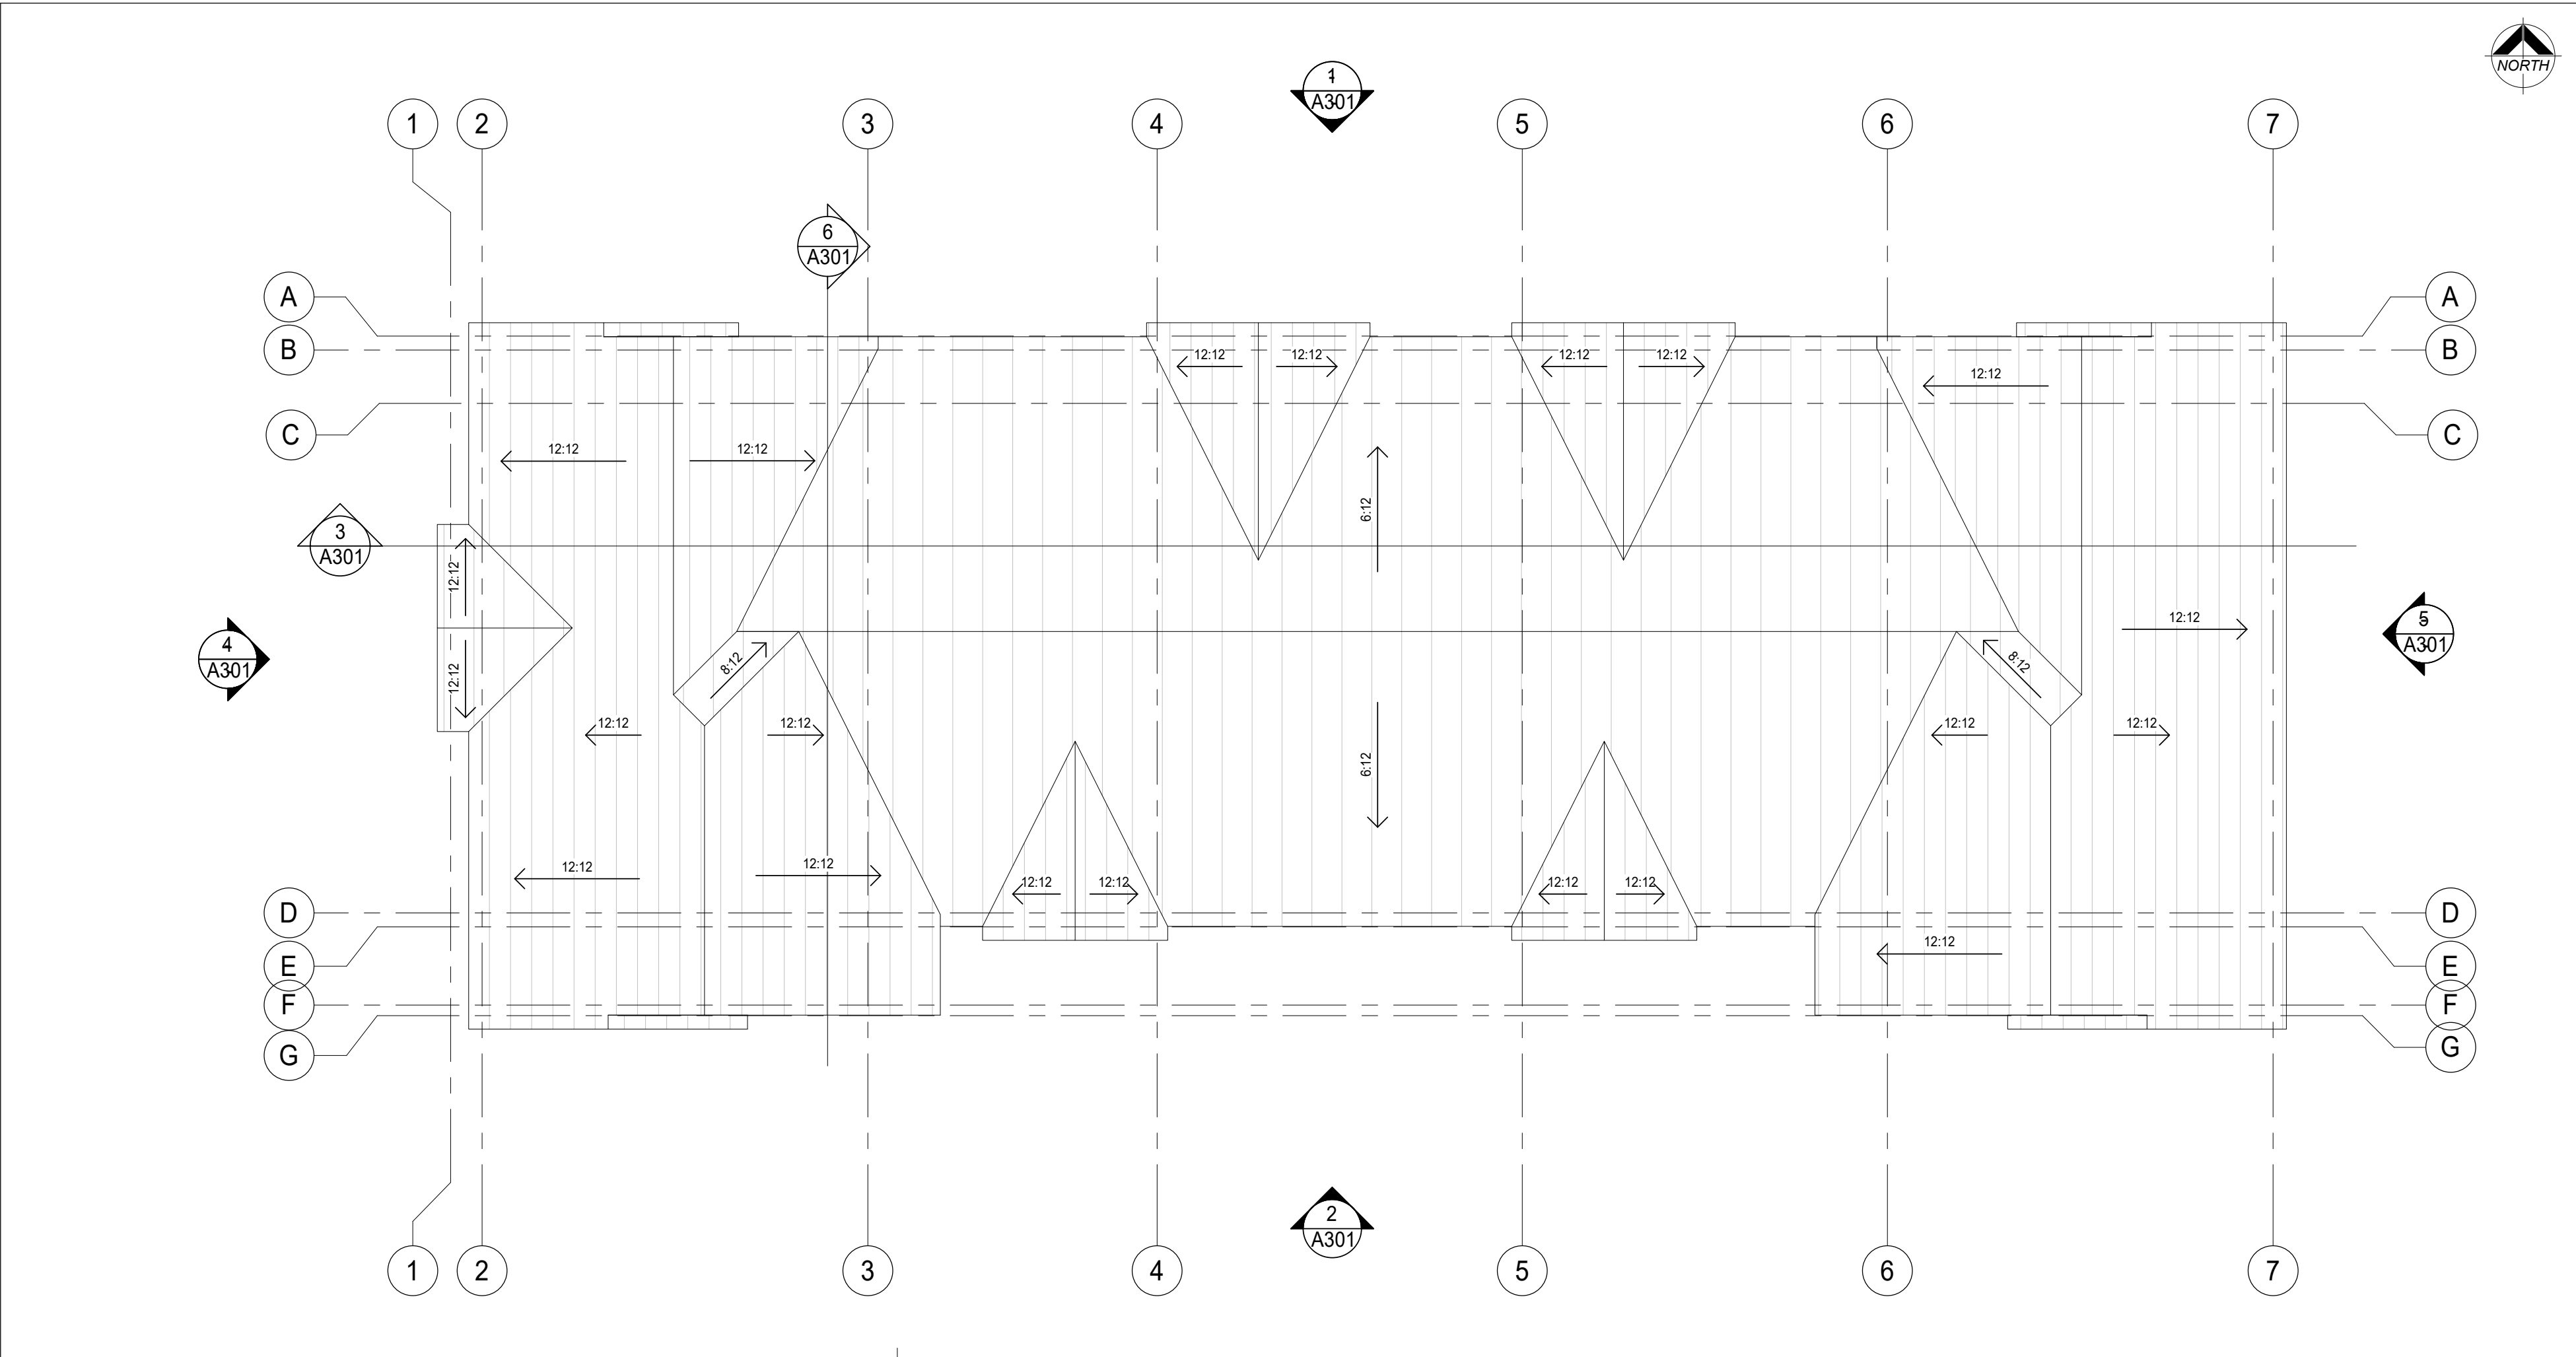

2 BUILDING 1 ROOF
1:100

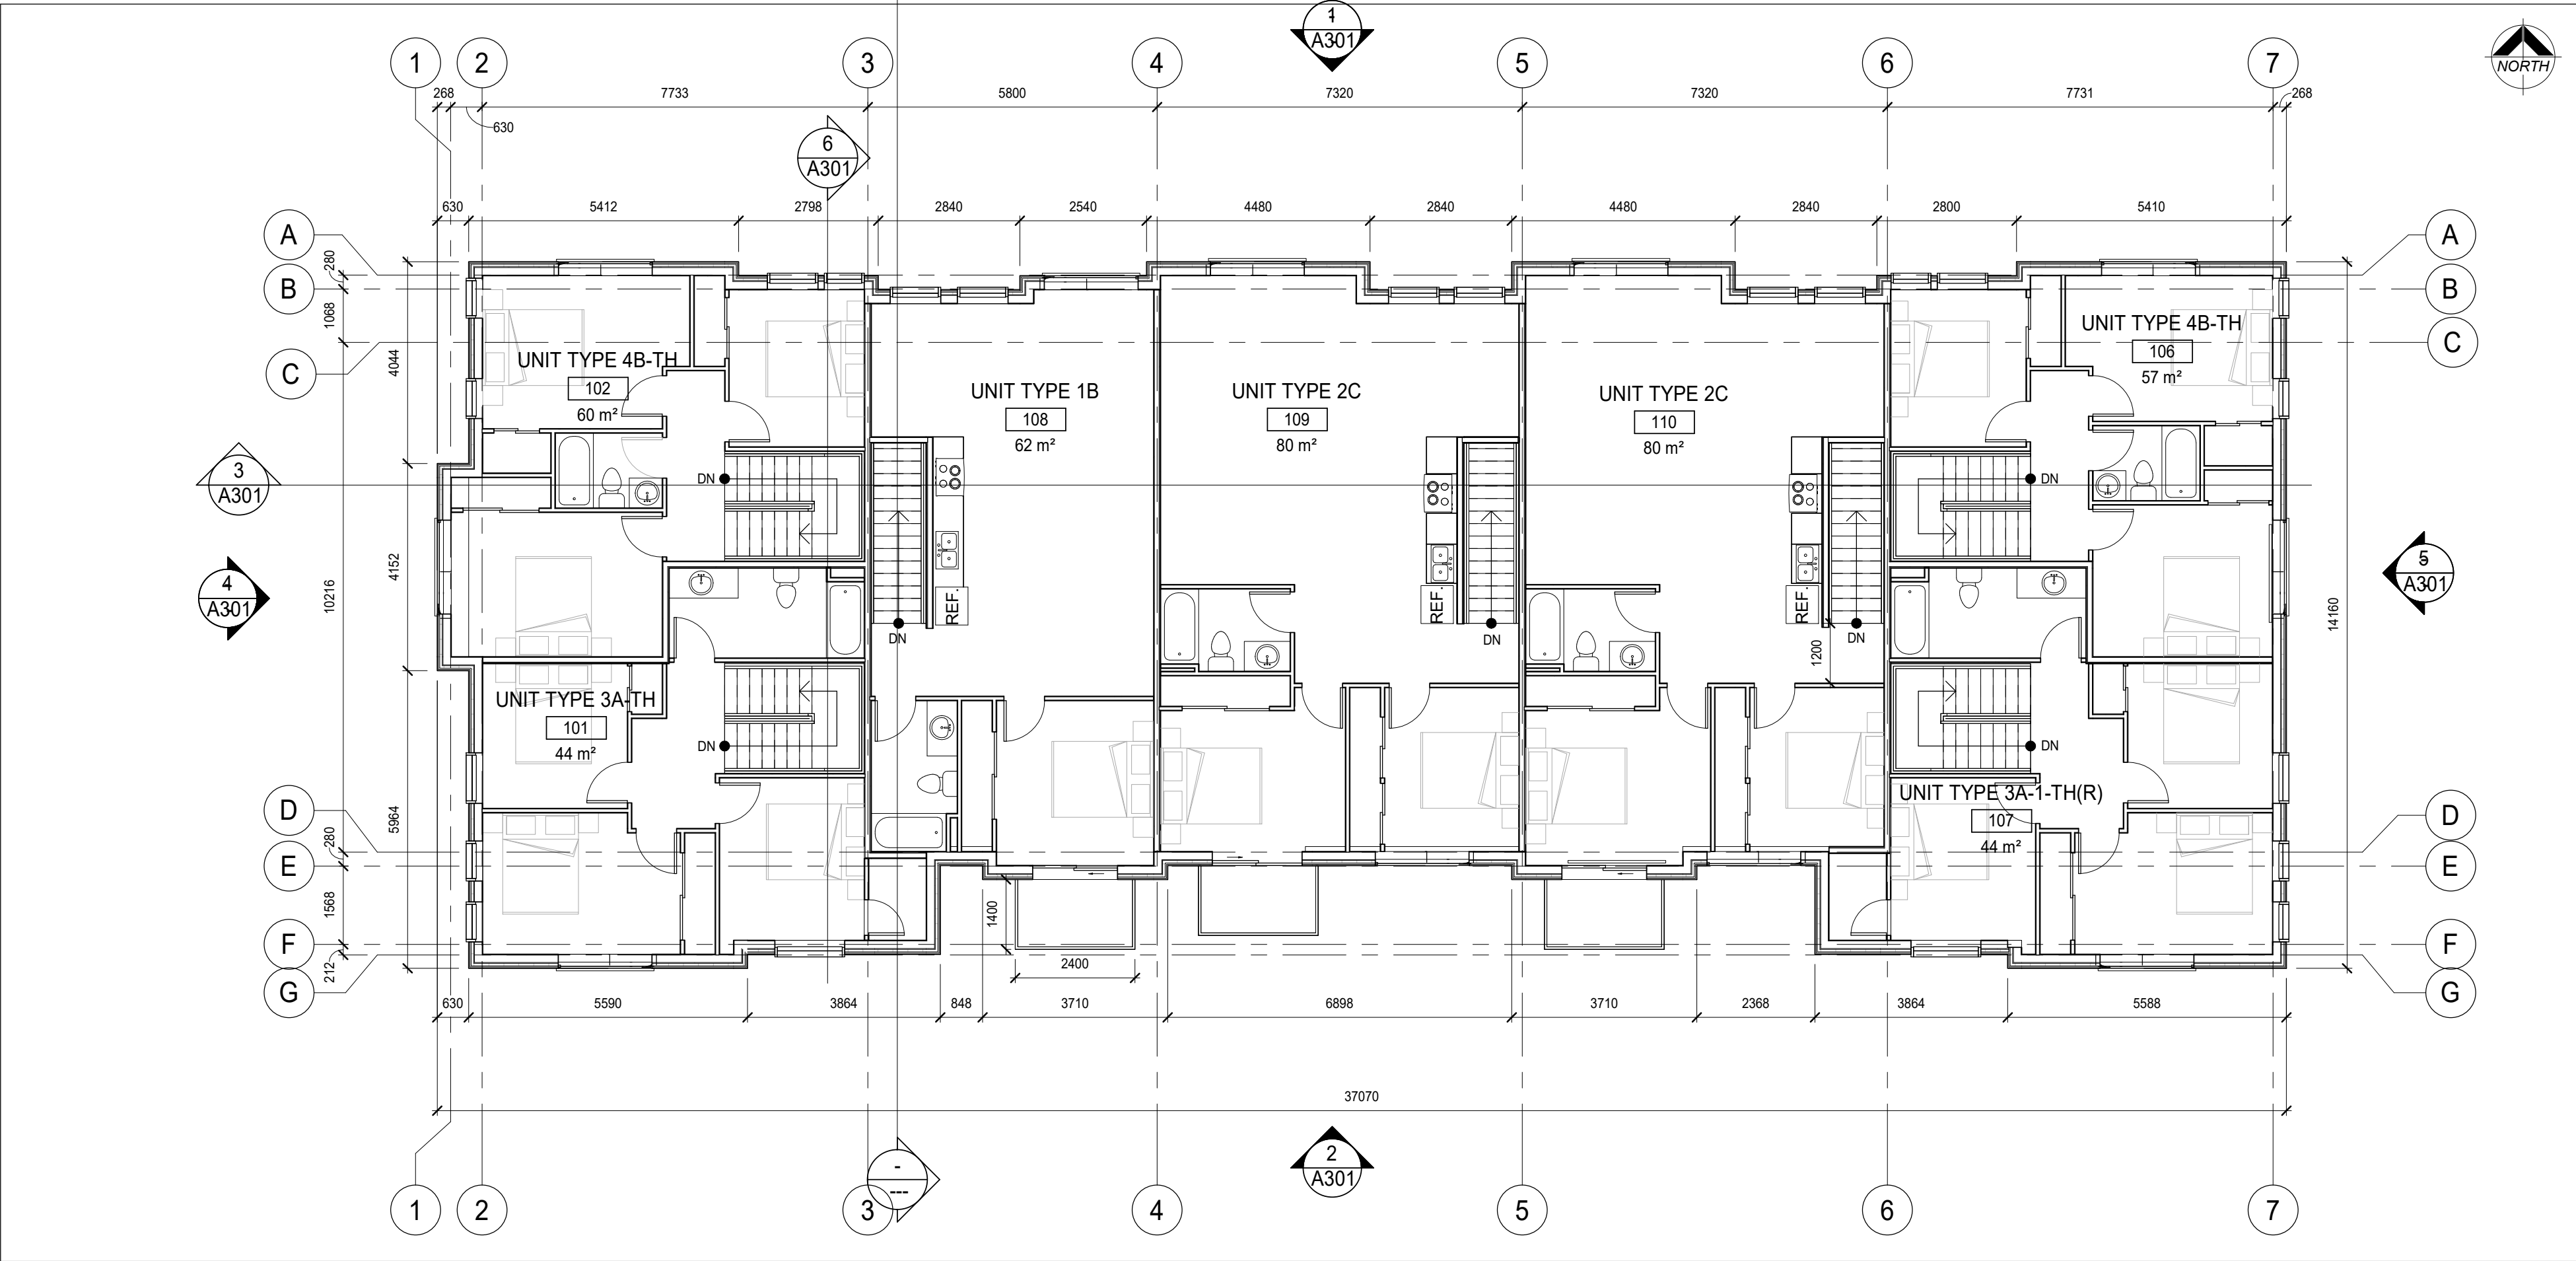

1 BUILDING 1 2ND FLOOR
1:100

DO NOT SCALE THE DRAWINGS
CHECK AND VERIFY ALL DIMENSIONS AT THE SITE.
ALL DRAWINGS, SPECIFICATIONS AND RELATED DOCUMENTS ARE THE
COPYRIGHT PROPERTY OF THE CONSULTANT AND MUST BE RETURNED
UPON REQUEST. REPRODUCTION OF DRAWINGS IN PART OR WHOLE
WITHOUT THE PERMISSION OF THE CONSULTANT IS FORBIDDEN.
DRAWINGS ARE NOT TO BE USED FOR CONSTRUCTION UNTIL SIGNED
AND SEALED BY THE CONSULTANT.

NO.	ISSUES	DATE	BY
1	ISSUED FOR REZONING	20/06/30	BBA
2	ISSUED FOR SPA	20/12/07	BBA

NO.	REVISIONS	DATE	BY

PROJECT:
**ELGIN PARK
REDEVELOPMENT
PROJECT**

265 - 327 ELGIN STREET
COBOURG, ONTARIO
NORTHUMBERLAND COUNTY

DRAWING:
**BUILDING 1, 2ND FLOOR
& ROOF PLAN**



BARRY BRYAN
ASSOCIATES


Architects
Engineers
Project Managers

201-250 Water Street
Whitby Ontario L1N 0G5
Tel: (905) 666-5252
Fax: (905) 666-5256
e-mail: bba@bba-archeng.com


DESIGN BY: BBA	DOC CONTROL: DATE
DRAWN BY: NV	% COMPLETE:
CHECKED BY: NS	INITIAL:
DATE: 06/29/20	SCALE: 1 : 100
FILE:	

PROJECT NO:
19284

DRAWING NO:
A202

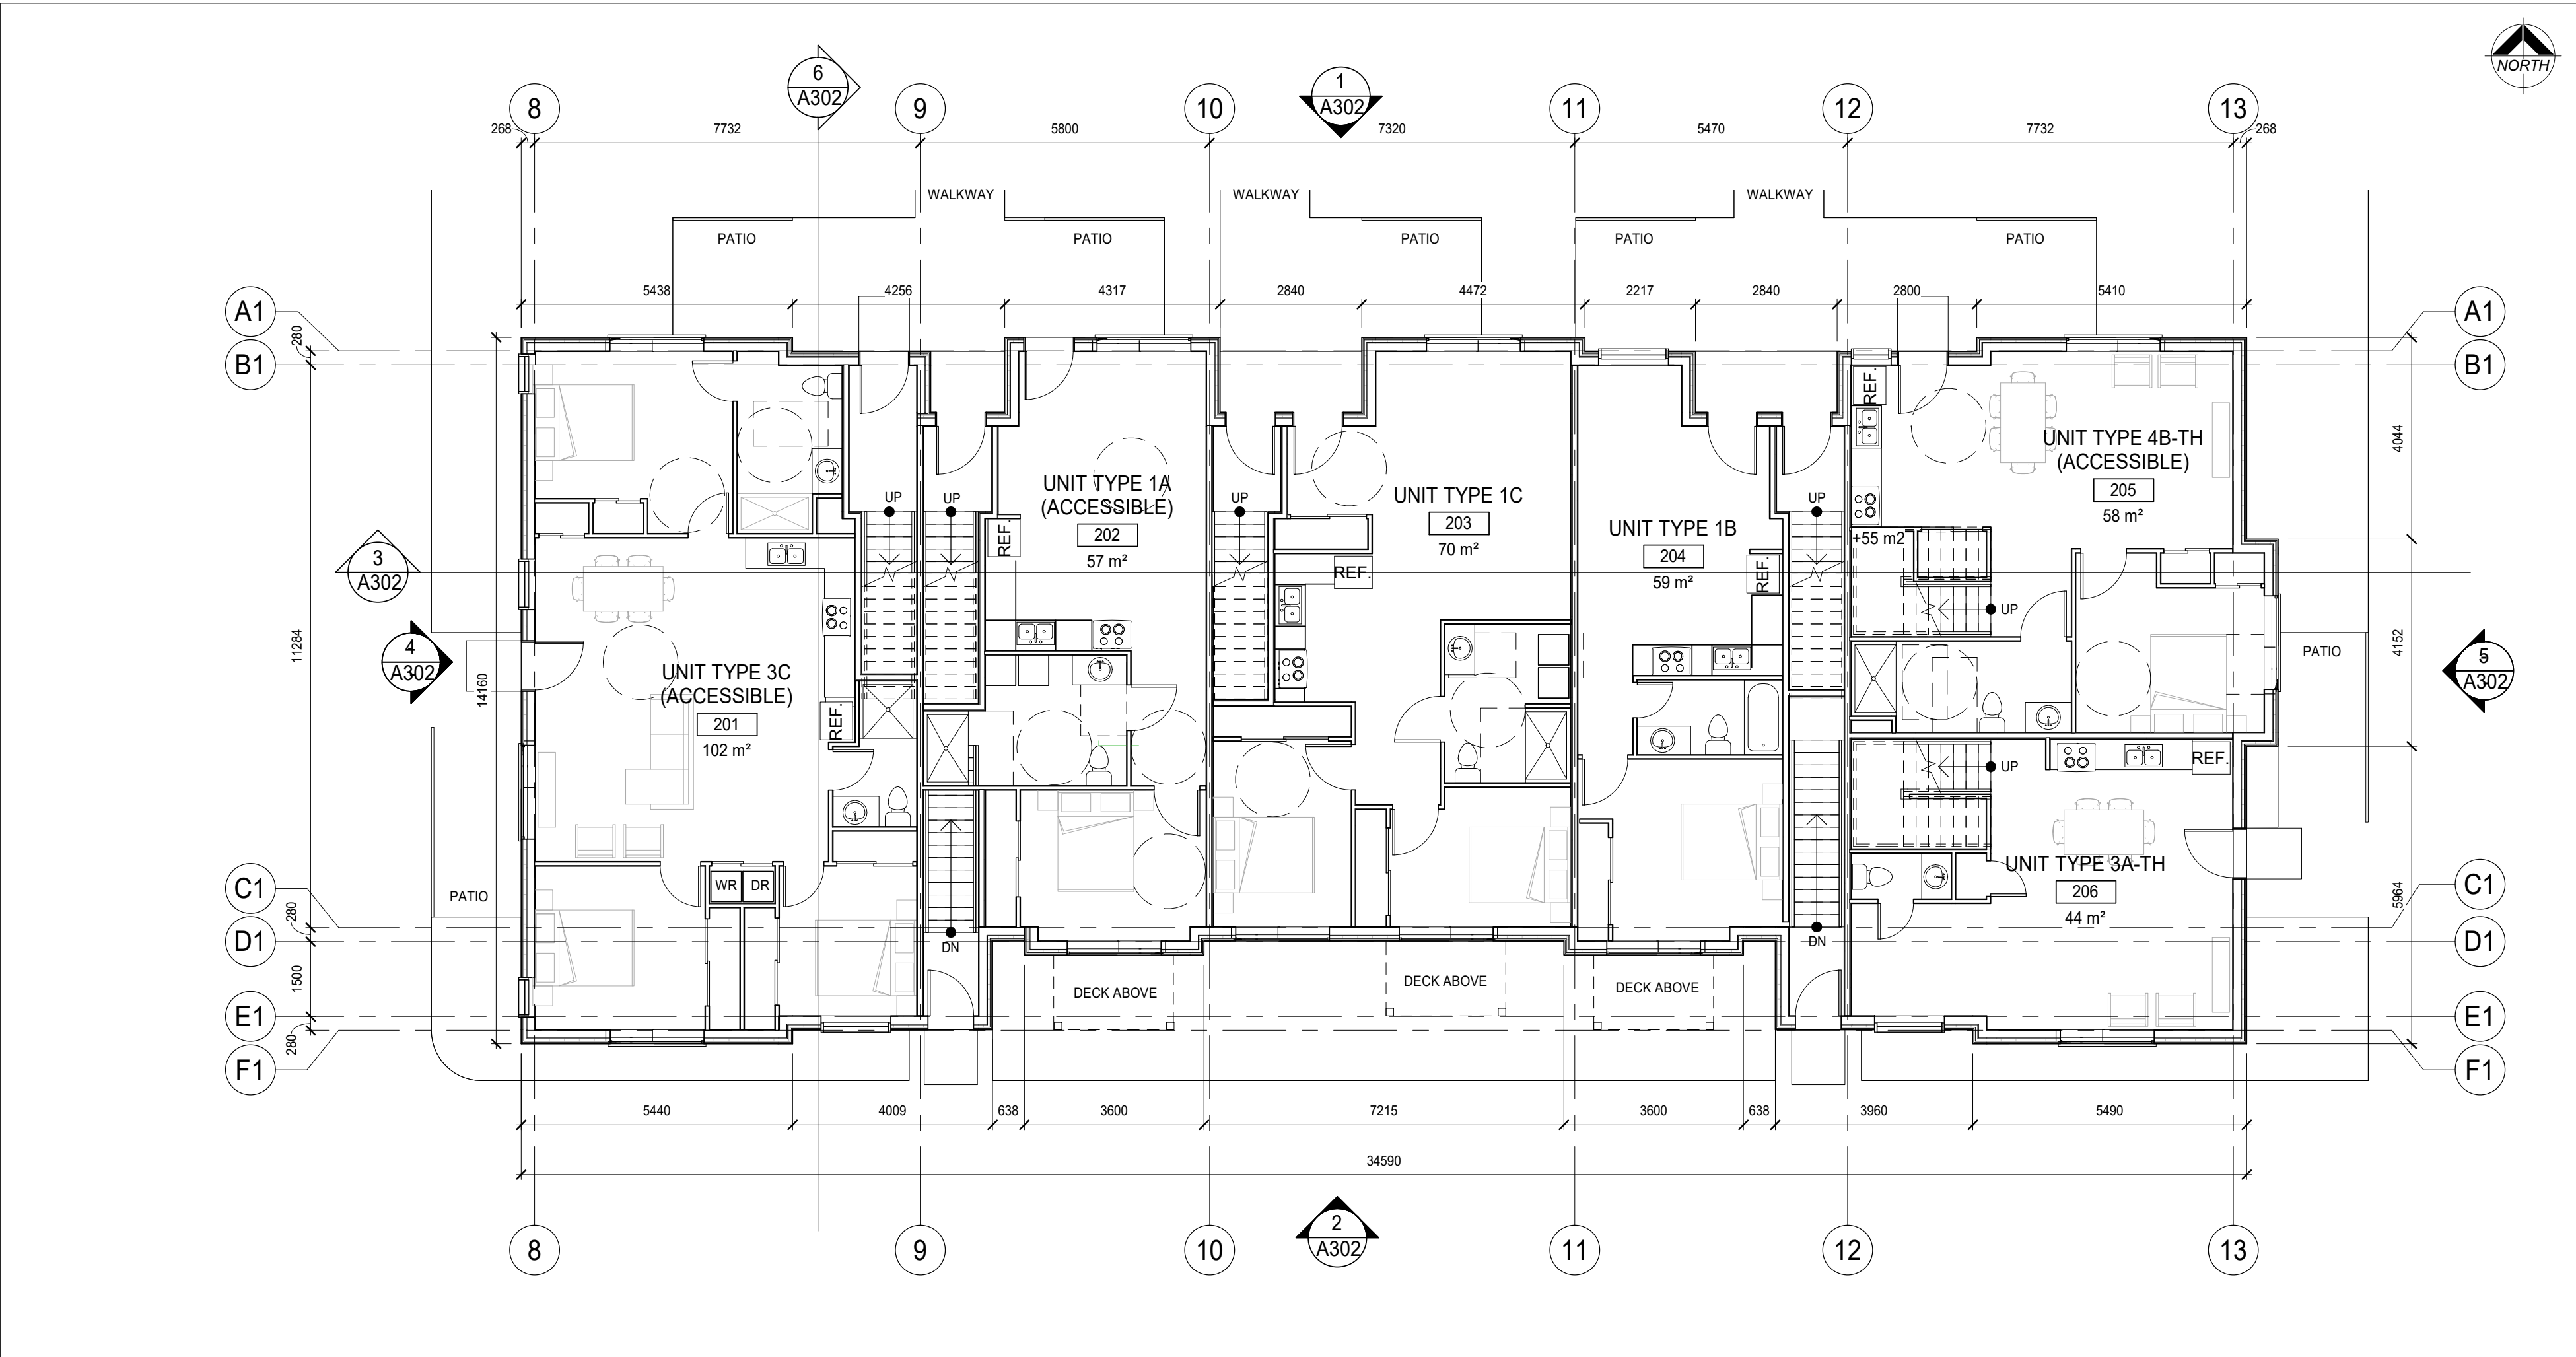

2 BUILDING 2 GROUND FLOOR
1:100

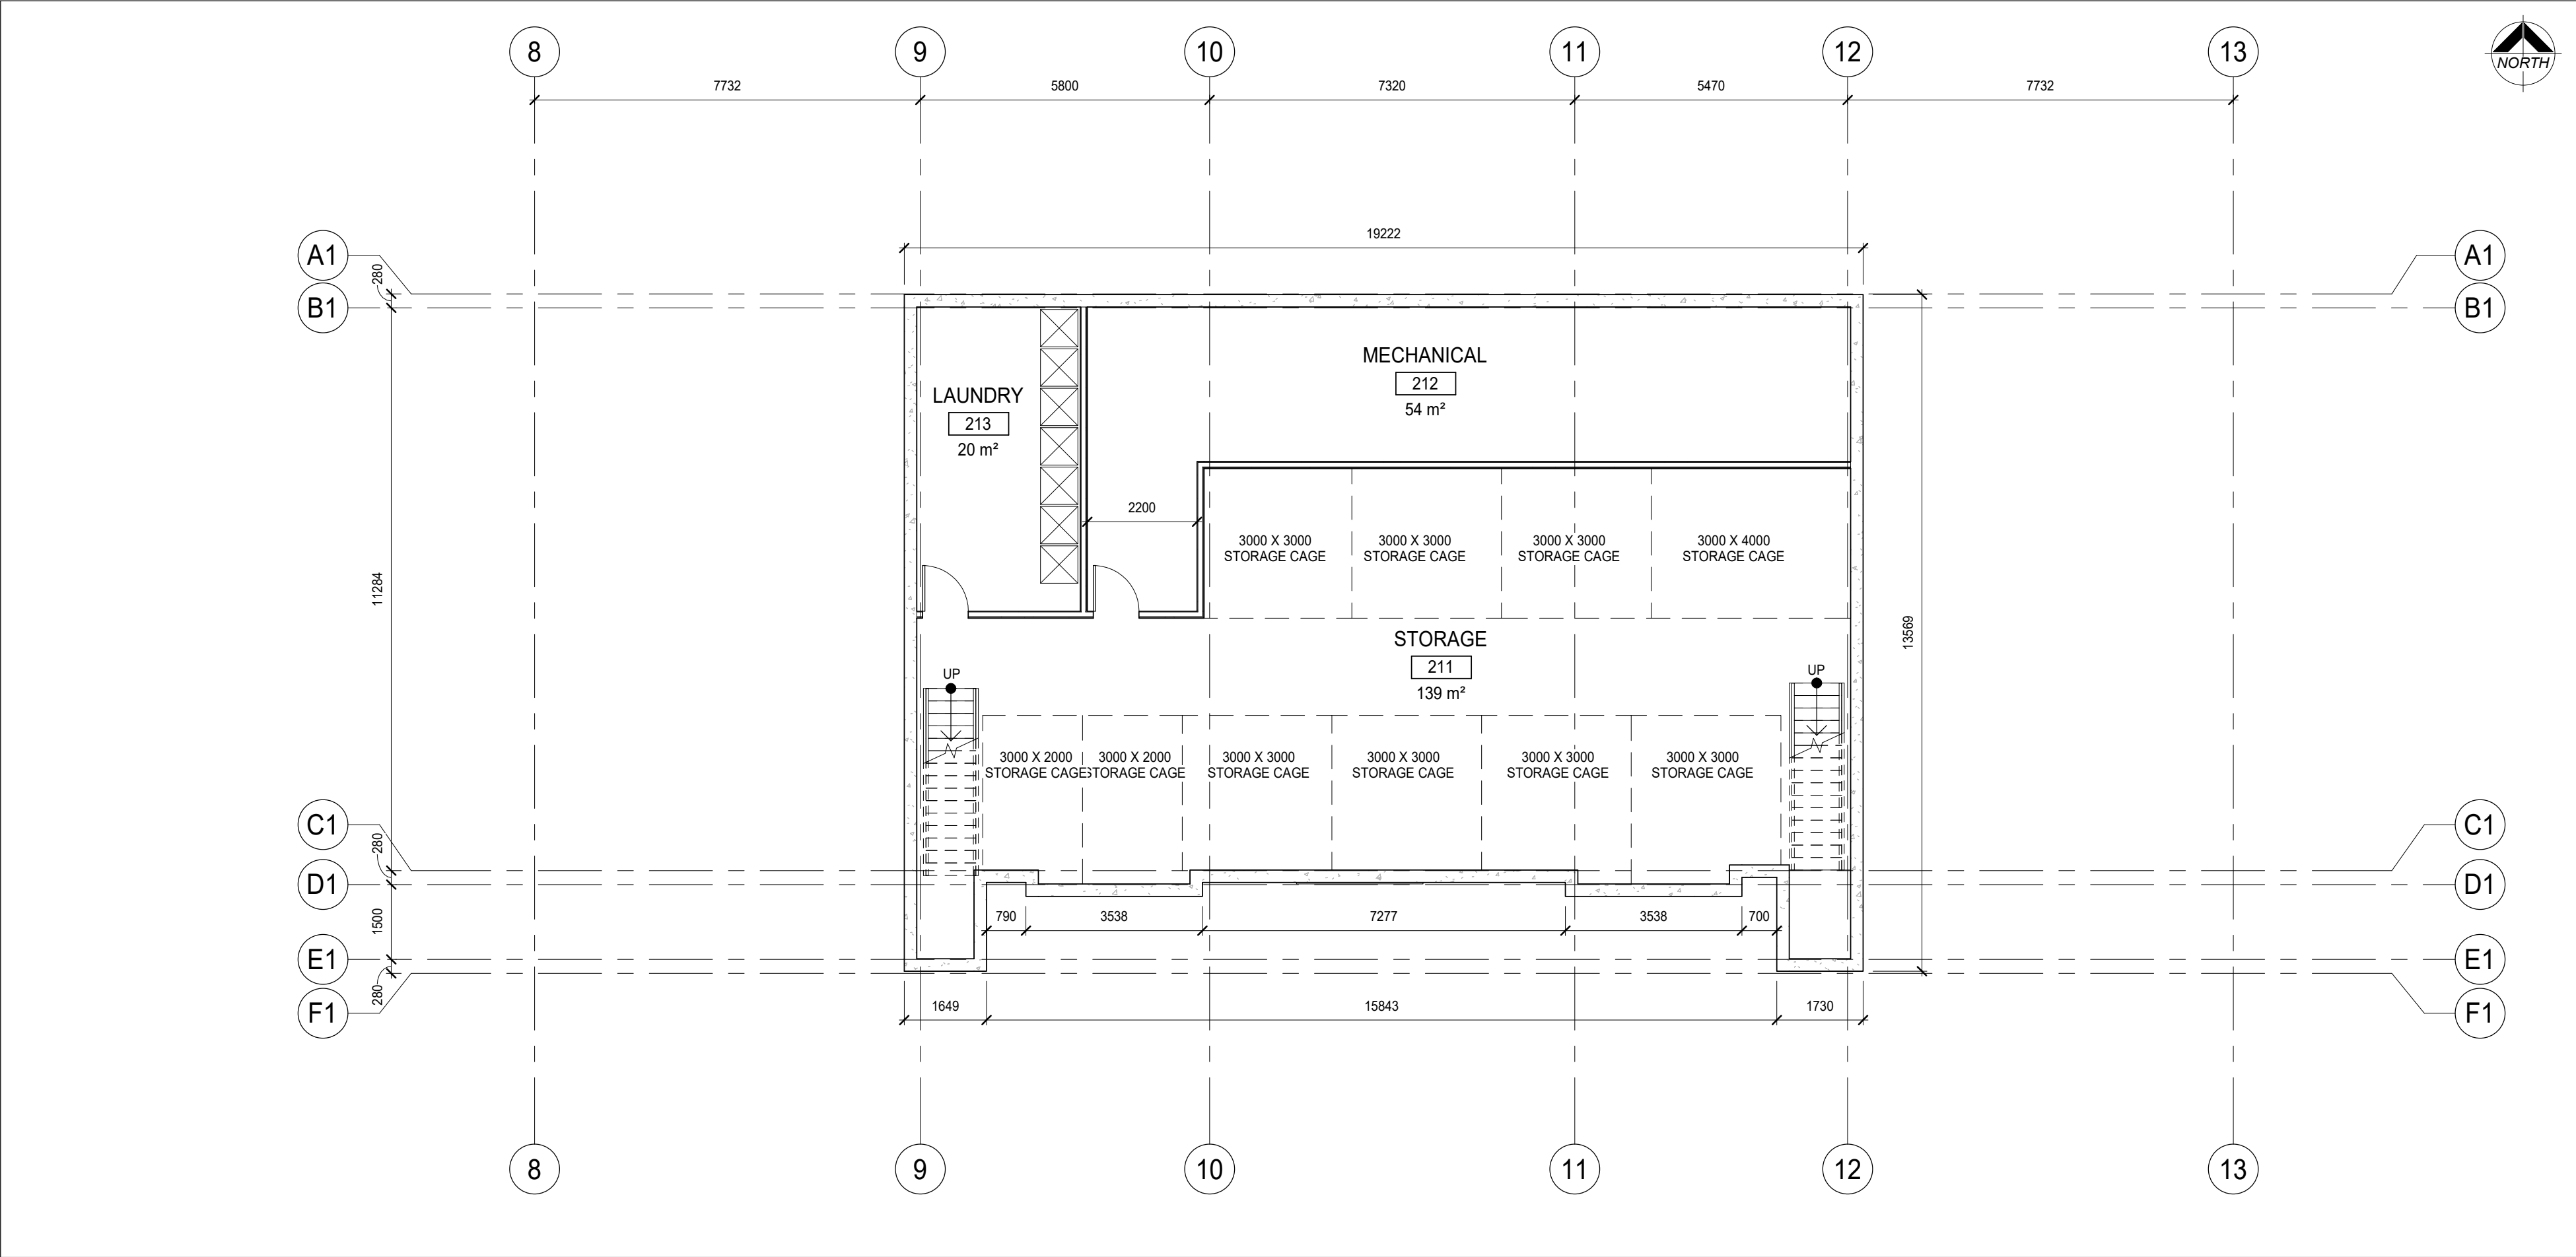

1 BUILDING 2 BASEMENT FLOOR
1:100

DO NOT SCALE THE DRAWINGS
CHECK AND VERIFY ALL DIMENSIONS AT THE SITE.
ALL DRAWINGS, SPECIFICATIONS AND RELATED DOCUMENTS ARE THE
COPYRIGHT PROPERTY OF THE CONSULTANT AND MUST BE RETURNED
UPON REQUEST. REPRODUCTION OF DRAWINGS IN PART OR WHOLE
WITHOUT THE PERMISSION OF THE CONSULTANT IS FORBIDDEN.
DRAWINGS ARE NOT TO BE USED FOR CONSTRUCTION UNTIL SIGNED
AND SEALED BY THE CONSULTANT.

NO.	ISSUES	DATE	BY
1	ISSUED FOR REZONING	20/06/30	BBA
2	ISSUED FOR SPA	20/12/07	BBA

NO.	REVISIONS	DATE	BY

PROJECT:
**ELGIN PARK
REDEVELOPMENT
PROJECT**

265 - 327 ELGIN STREET
COBOURG, ONTARIO
NORTHUMBERLAND COUNTY

DRAWING:
**BUILDING 2, BASEMENT
& GROUND FLOOR PLAN**



**BARRY BRYAN
ASSOCIATES**

*Architects
Engineers
Project Managers*


201-250 Water Street
Whitby Ontario L1N 0G5
Tel: (905) 666-5252
Fax: (905) 666-5256
e-mail: bba@bba-archeng.com

DESIGN BY: BBA	DOC CONTROL: DATE
DRAWN BY: NV	% COMPLETE:
CHECKED BY: NS	INITIAL:


DATE: 06/29/20
SCALE: 1 : 100
FILE:

PROJECT NO:
19284

DRAWING NO:
A203

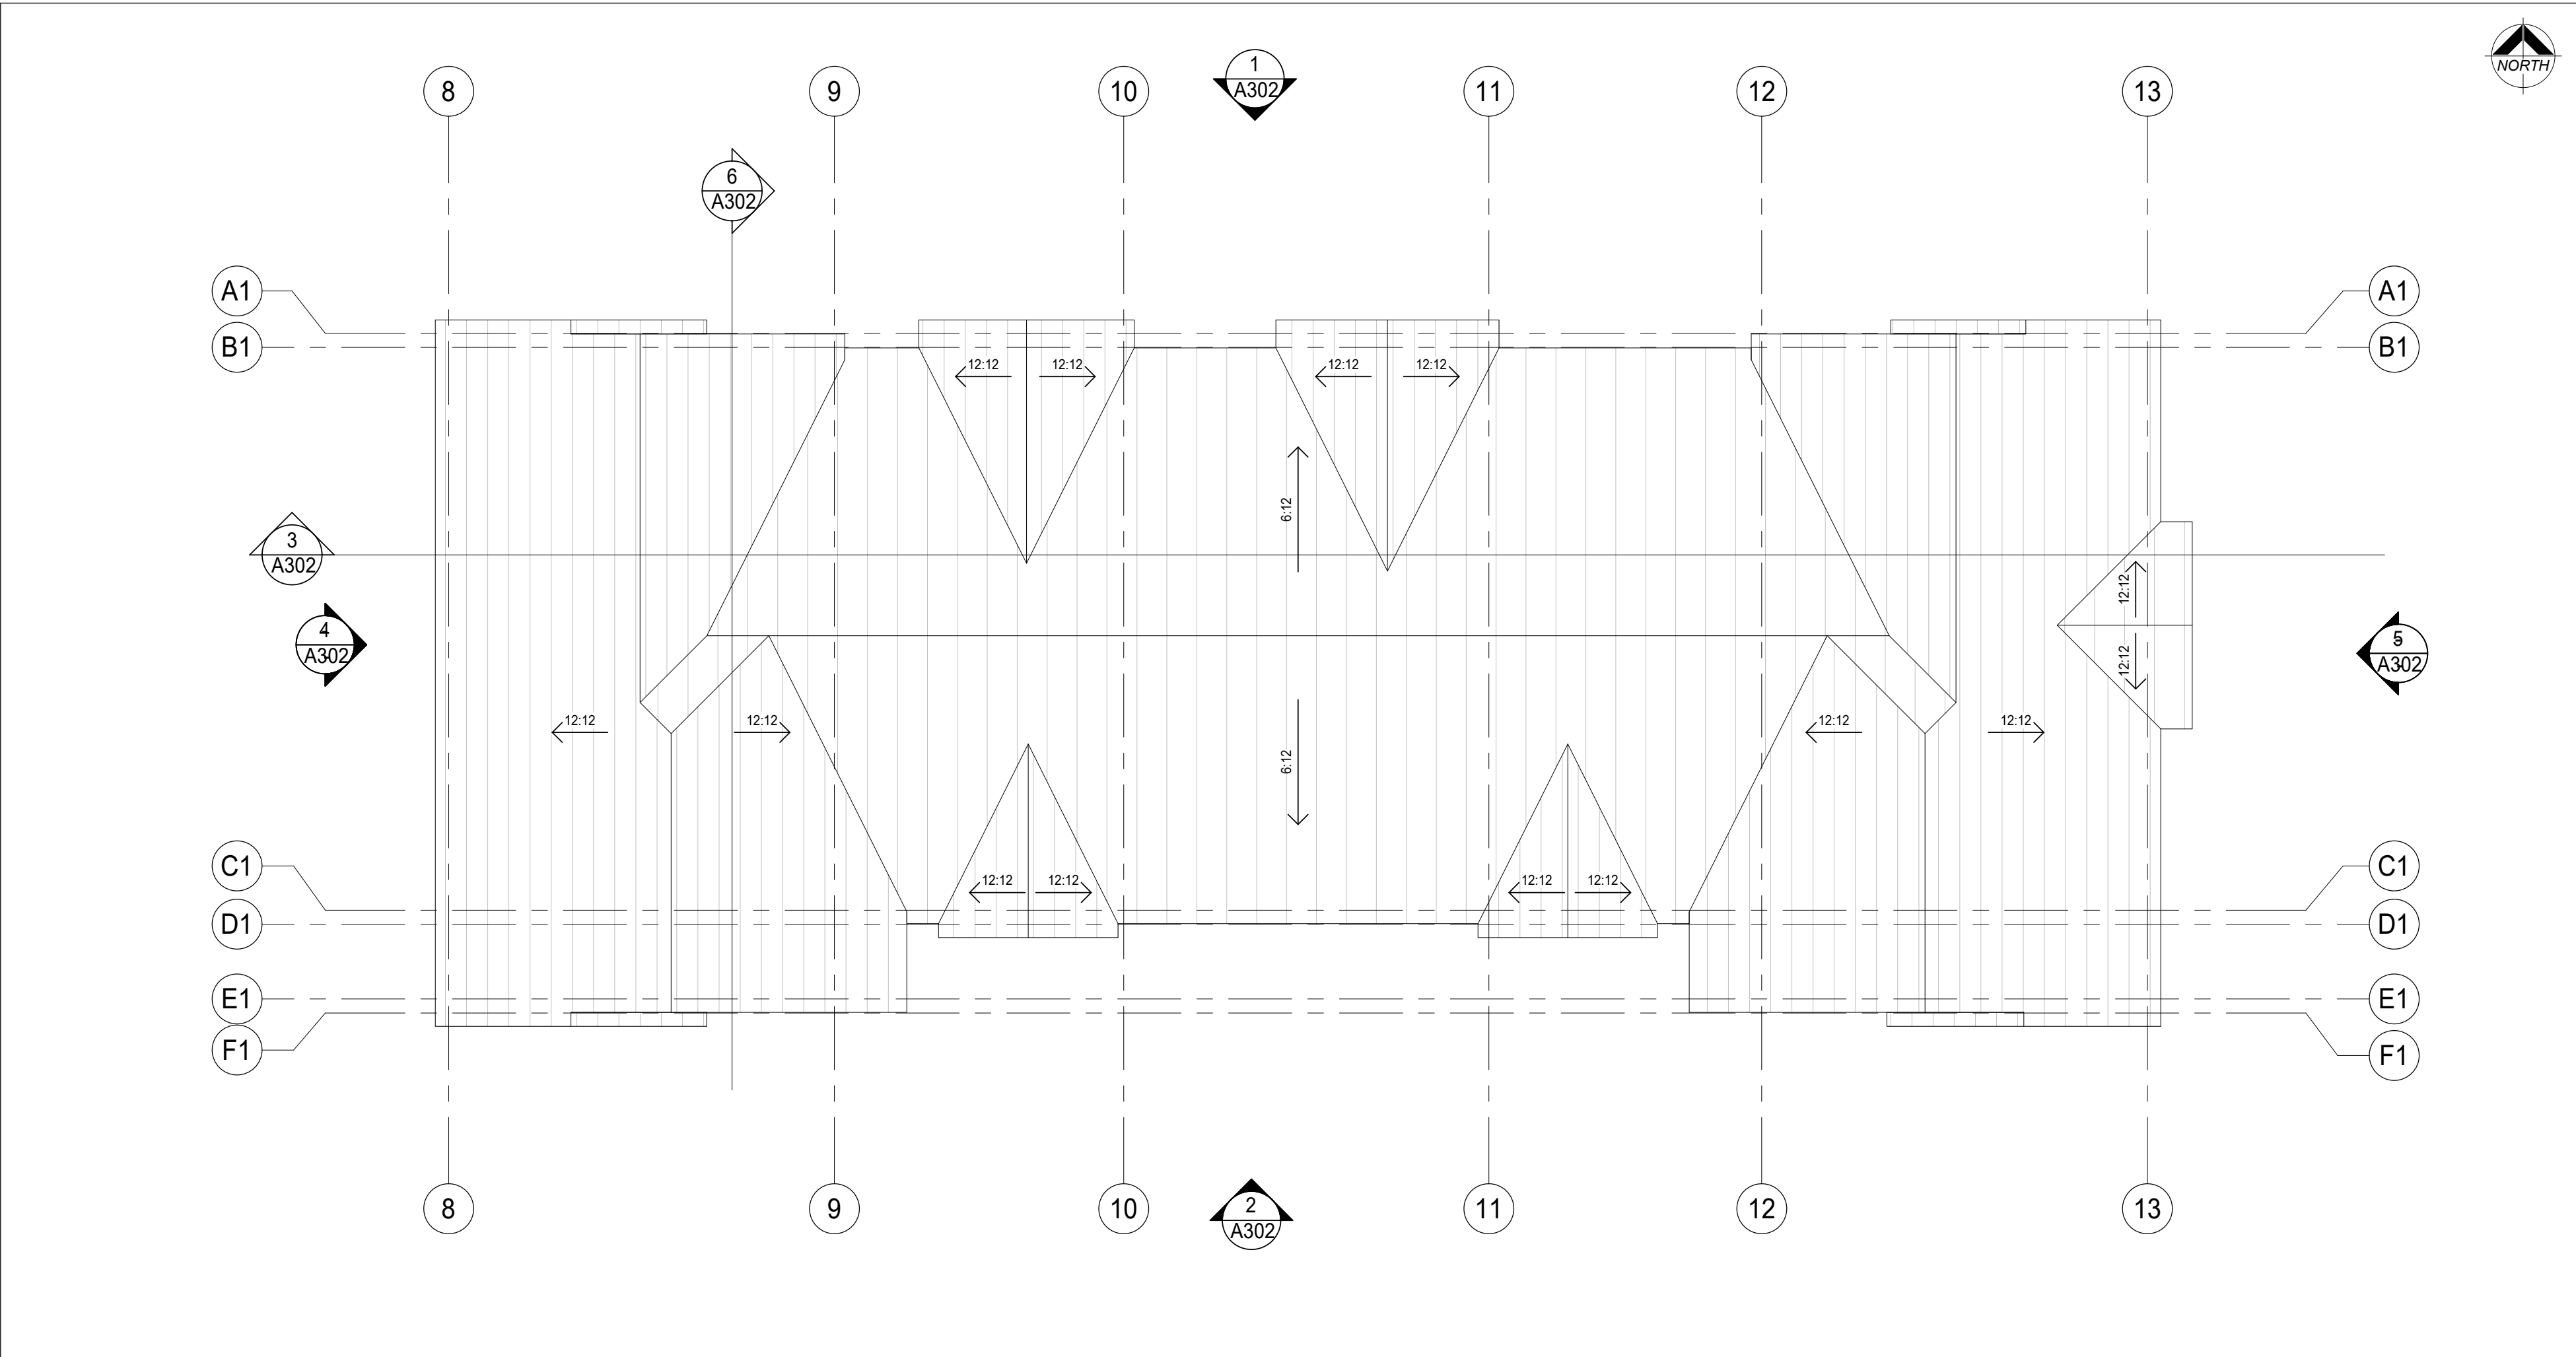

2 BUILDING 1 ROOF
A204 1:100

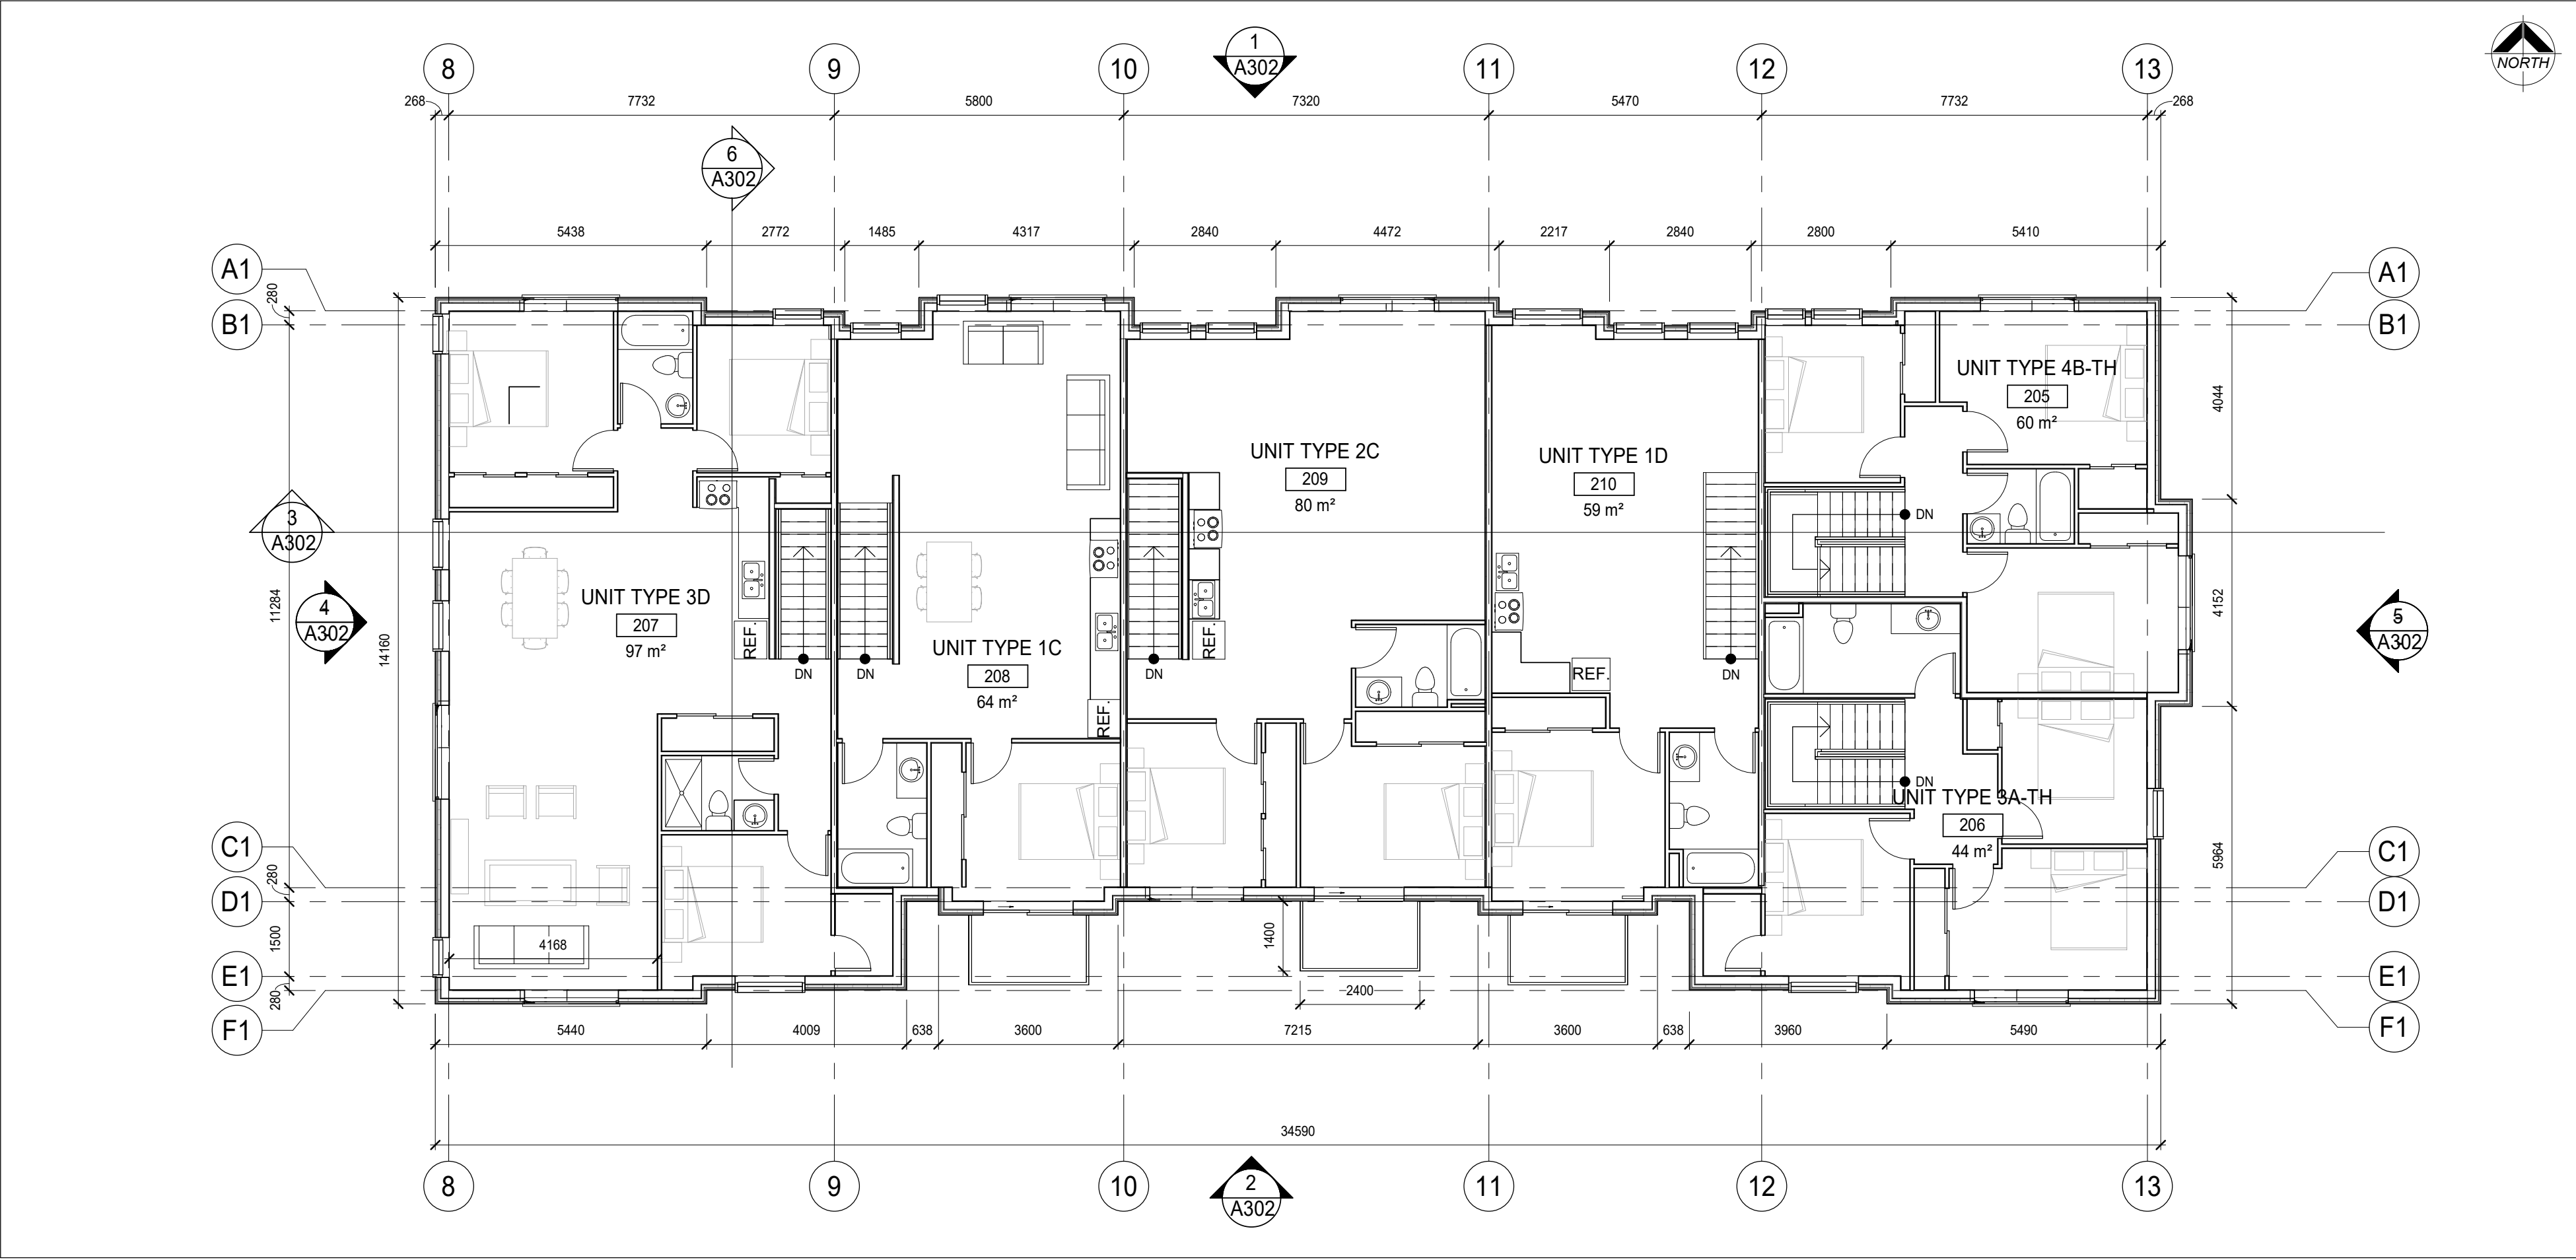

1 BUILDING 2 2ND FLOOR
A204 1:100

DO NOT SCALE THE DRAWINGS
CHECK AND VERIFY ALL DIMENSIONS AT THE SITE.
ALL DRAWINGS, SPECIFICATIONS AND RELATED DOCUMENTS ARE THE
COPYRIGHT PROPERTY OF THE CONSULTANT AND MUST BE RETURNED
UPON REQUEST. REPRODUCTION OF DRAWINGS IN PART OR WHOLE
WITHOUT THE PERMISSION OF THE CONSULTANT IS FORBIDDEN.
DRAWINGS ARE NOT TO BE USED FOR CONSTRUCTION UNTIL SIGNED
AND SEALED BY THE CONSULTANT.


NO.	ISSUES	DATE	BY
1	ISSUED FOR REZONING	20/06/30	BBA
2	ISSUED FOR SPA	20/12/07	BBA

NO.	REVISIONS	DATE	BY

PROJECT:
**ELGIN PARK
REDEVELOPMENT
PROJECT**

265 - 327 ELGIN STREET
COBOURG, ONTARIO
NORTHUMBERLAND COUNTY

DRAWING:
**BUILDING 2, 2ND FLOOR
& ROOF PLAN**

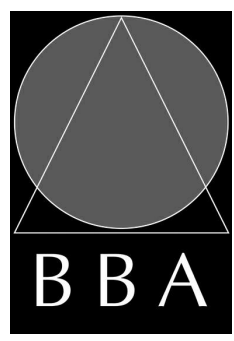

**BARRY BRYAN
ASSOCIATES**


*Architects
Engineers
Project Managers*

201-250 Water Street
Whitby Ontario L1N 0G5
Tel: (905) 666-5252
Fax: (905) 666-5256
e-mail: bba@bba-archeng.com


DESIGN BY: BBA	DOC CONTROL DATE:
DRAWN BY: NV	% COMPLETE:
CHECKED BY: NS	INITIAL:
DATE: 06/29/20	SCALE:
SCALE: 1 : 100	FILE:

PROJECT NO:
19284

DRAWING NO:
A204

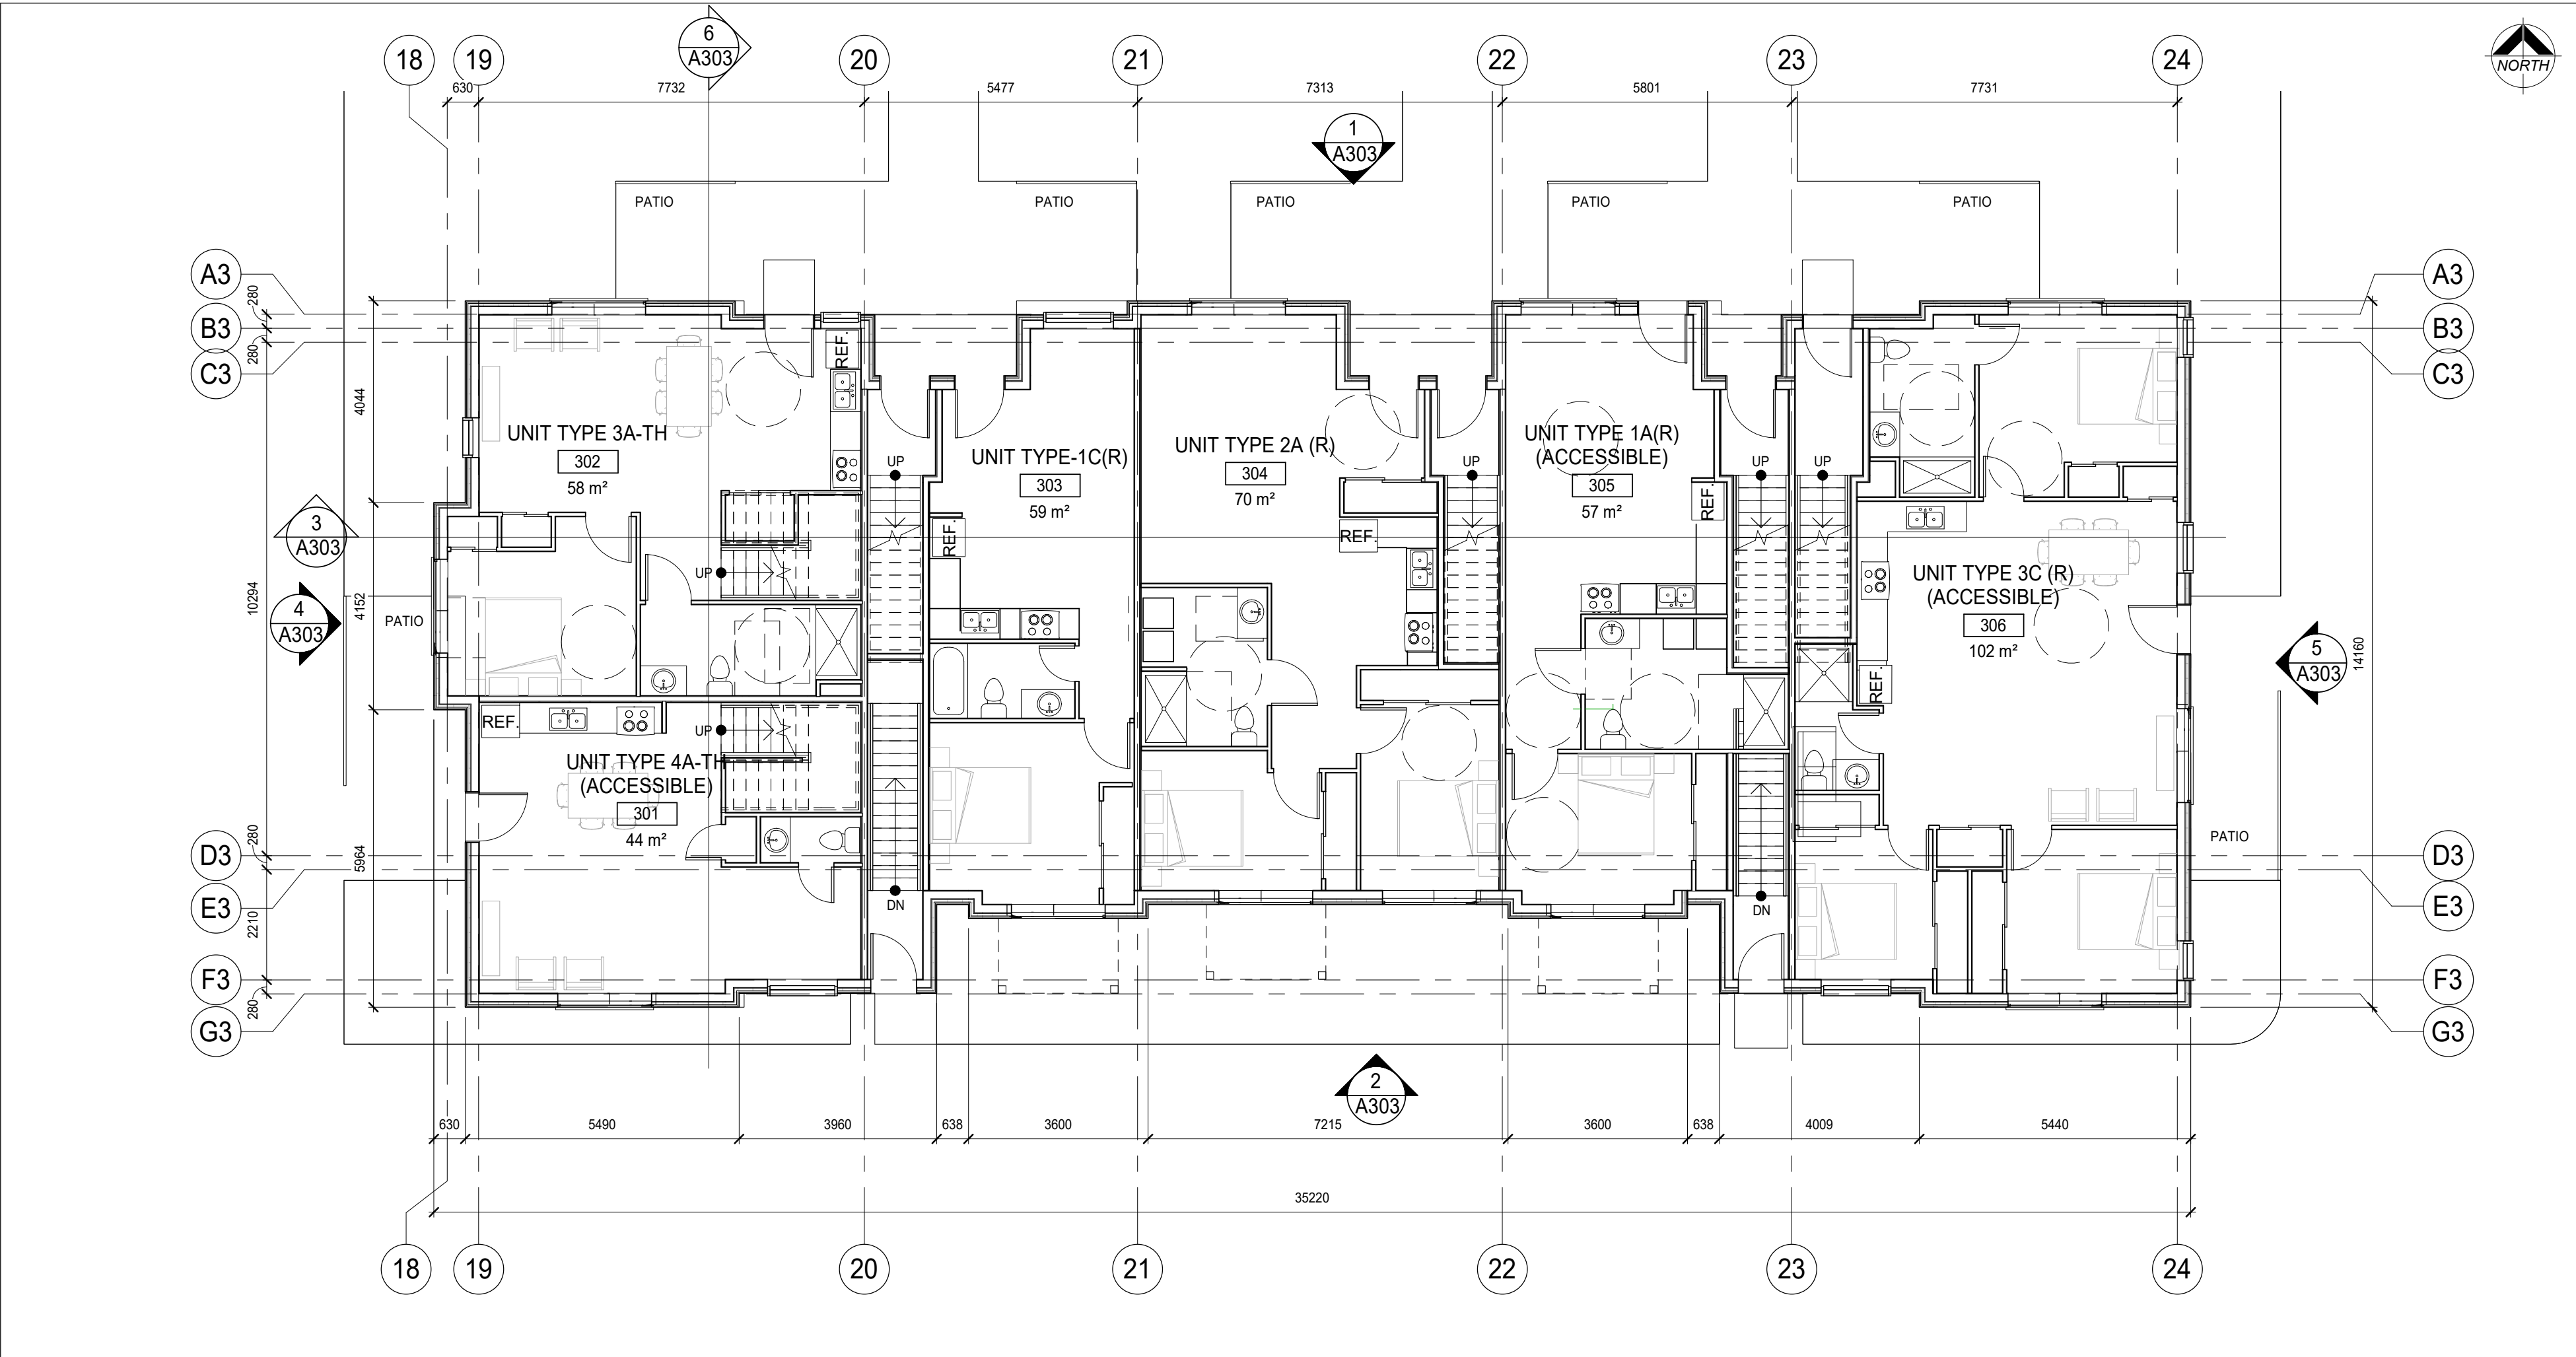

2 BUILDING 3 GROUND FLOOR
A205 1:100

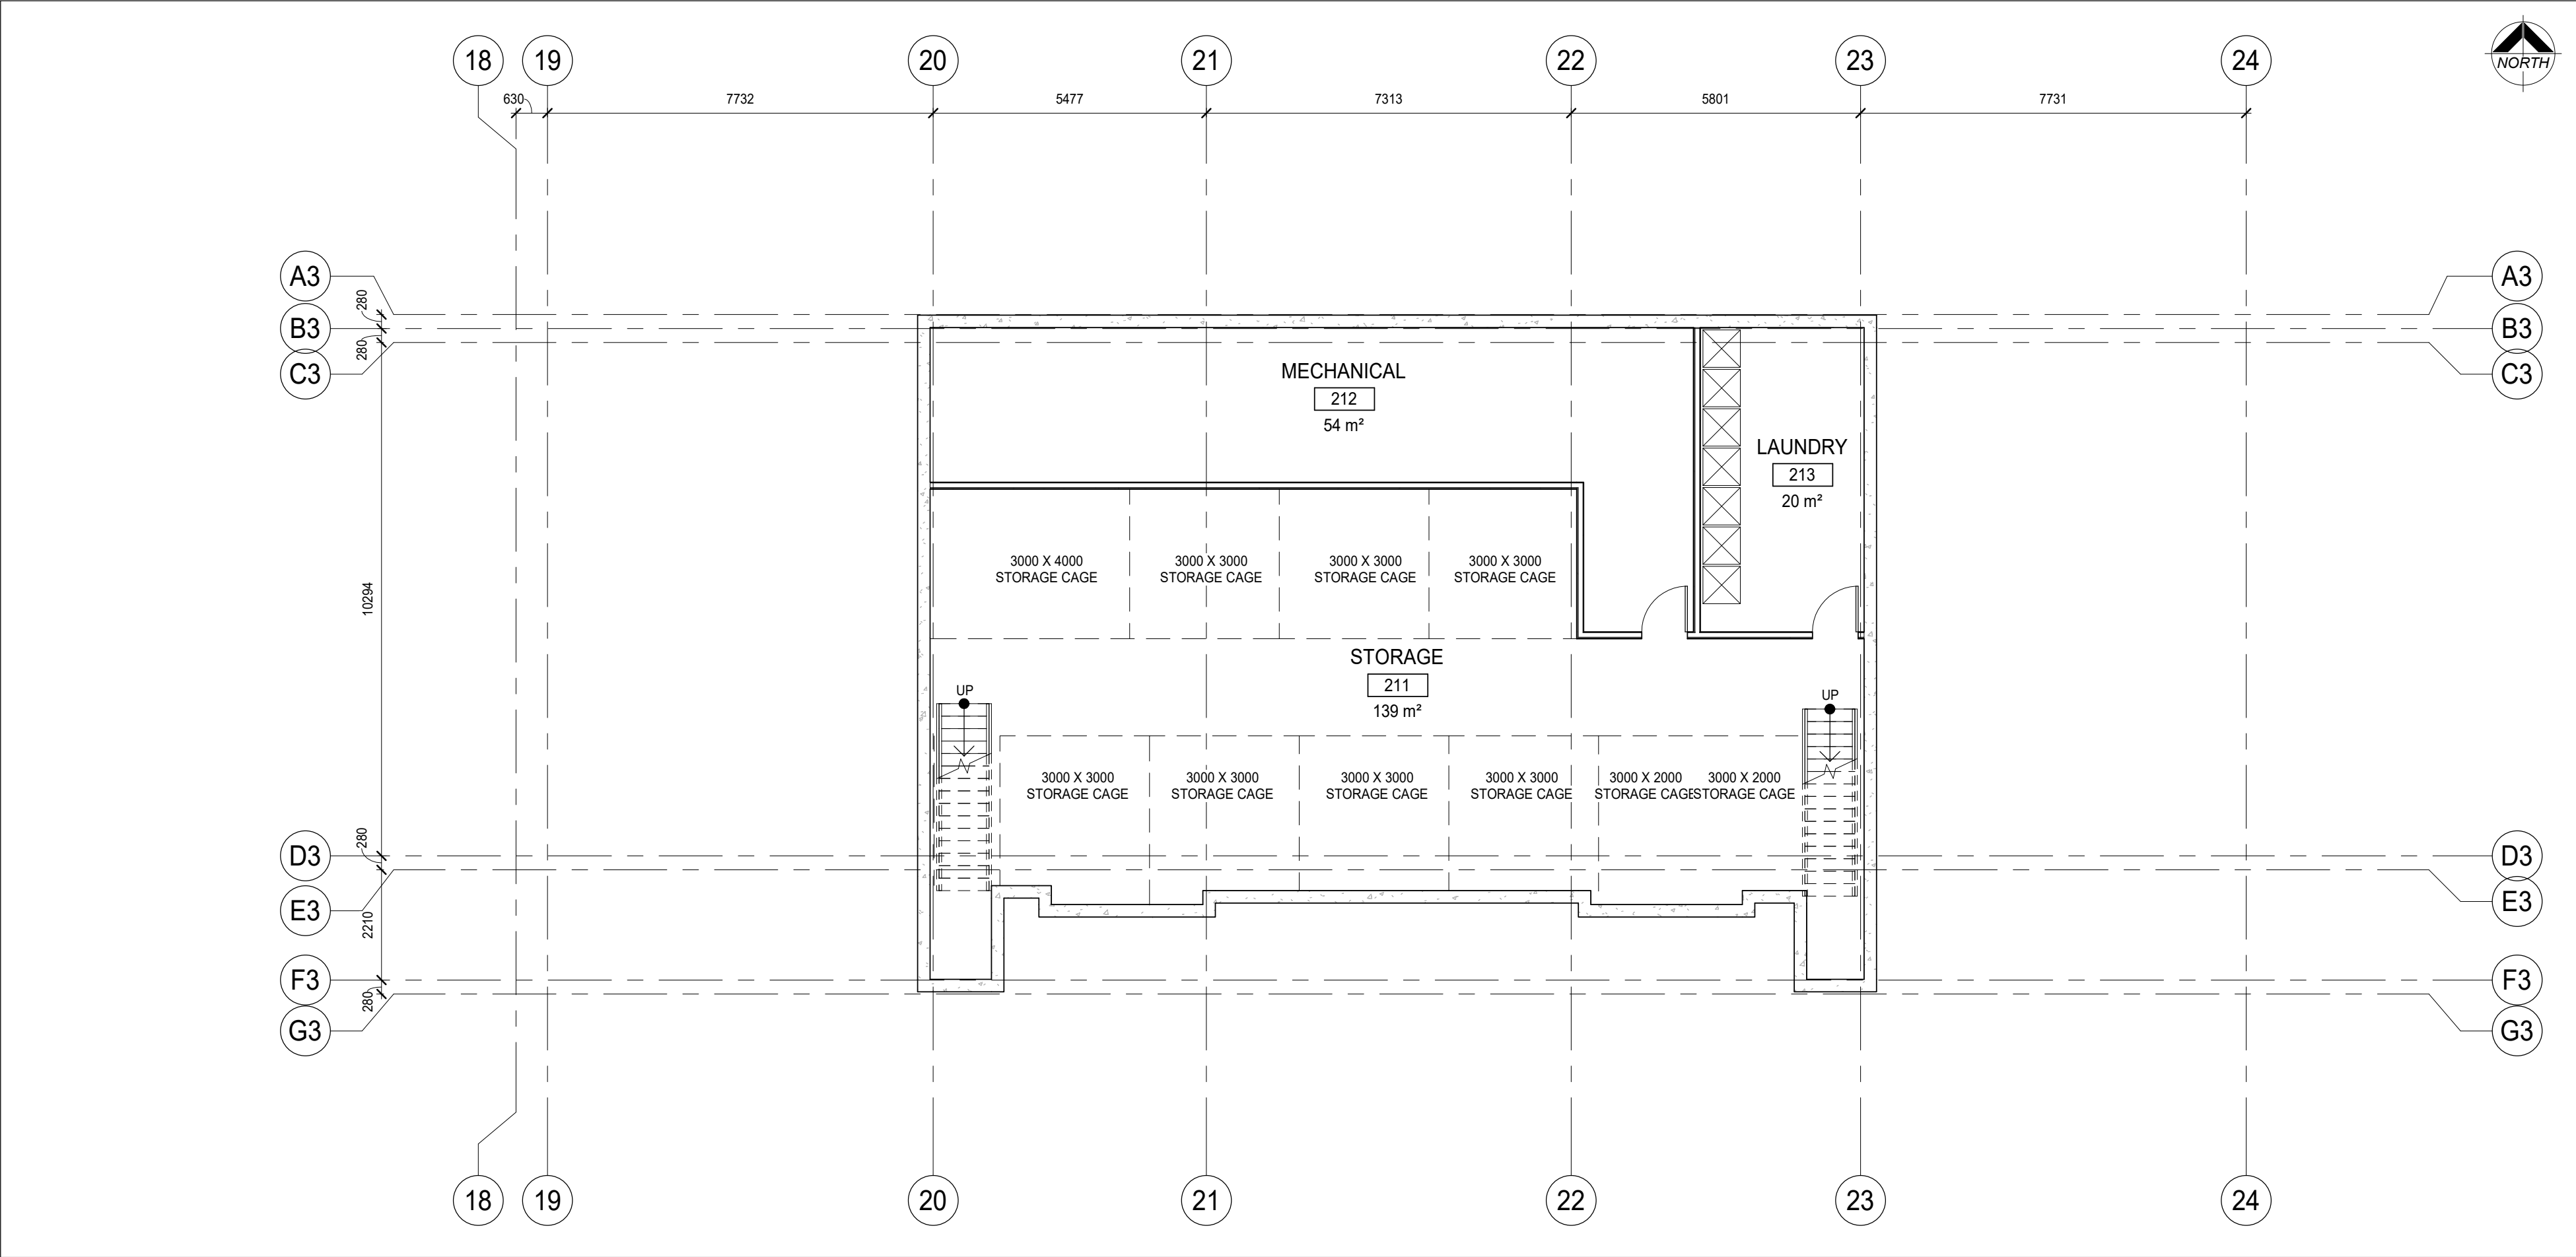

1 BUILDING 3 BASEMENT FLOOR
A205 1:100

DO NOT SCALE THE DRAWINGS
CHECK AND VERIFY ALL DIMENSIONS AT THE SITE.
ALL DRAWINGS, SPECIFICATIONS AND RELATED DOCUMENTS ARE THE
COPYRIGHT PROPERTY OF THE CONSULTANT AND MUST BE RETURNED
UPON REQUEST. REPRODUCTION OF DRAWINGS IN PART OR WHOLE
WITHOUT THE PERMISSION OF THE CONSULTANT IS FORBIDDEN.
DRAWINGS ARE NOT TO BE USED FOR CONSTRUCTION UNTIL SIGNED
AND SEALED BY THE CONSULTANT.

NO.	ISSUES	DATE	BY
1	ISSUED FOR REZONING	20/06/30	BBA
2	ISSUED FOR SPA	20/12/07	BBA

NO.	REVISIONS	DATE	BY

PROJECT:
**ELGIN PARK
REDEVELOPMENT
PROJECT**

265 - 327 ELGIN STREET
COBOURG, ONTARIO
NORTHUMBERLAND COUNTY

DRAWING:
**BUILDING 3, BASEMENT
& GROUND FLOOR PLAN**




**BARRY BRYAN
ASSOCIATES**

*Architects
Engineers
Project Managers*


DESIGN BY: BBA	DOC CONTROL: DATE
DRAWN BY: NV	% COMPLETE:
CHECKED BY: NS	INITIAL:
DATE: 06/29/20	
SCALE: 1 : 100	
FILE:	

PROJECT NO:
19284

DRAWING NO:
A205

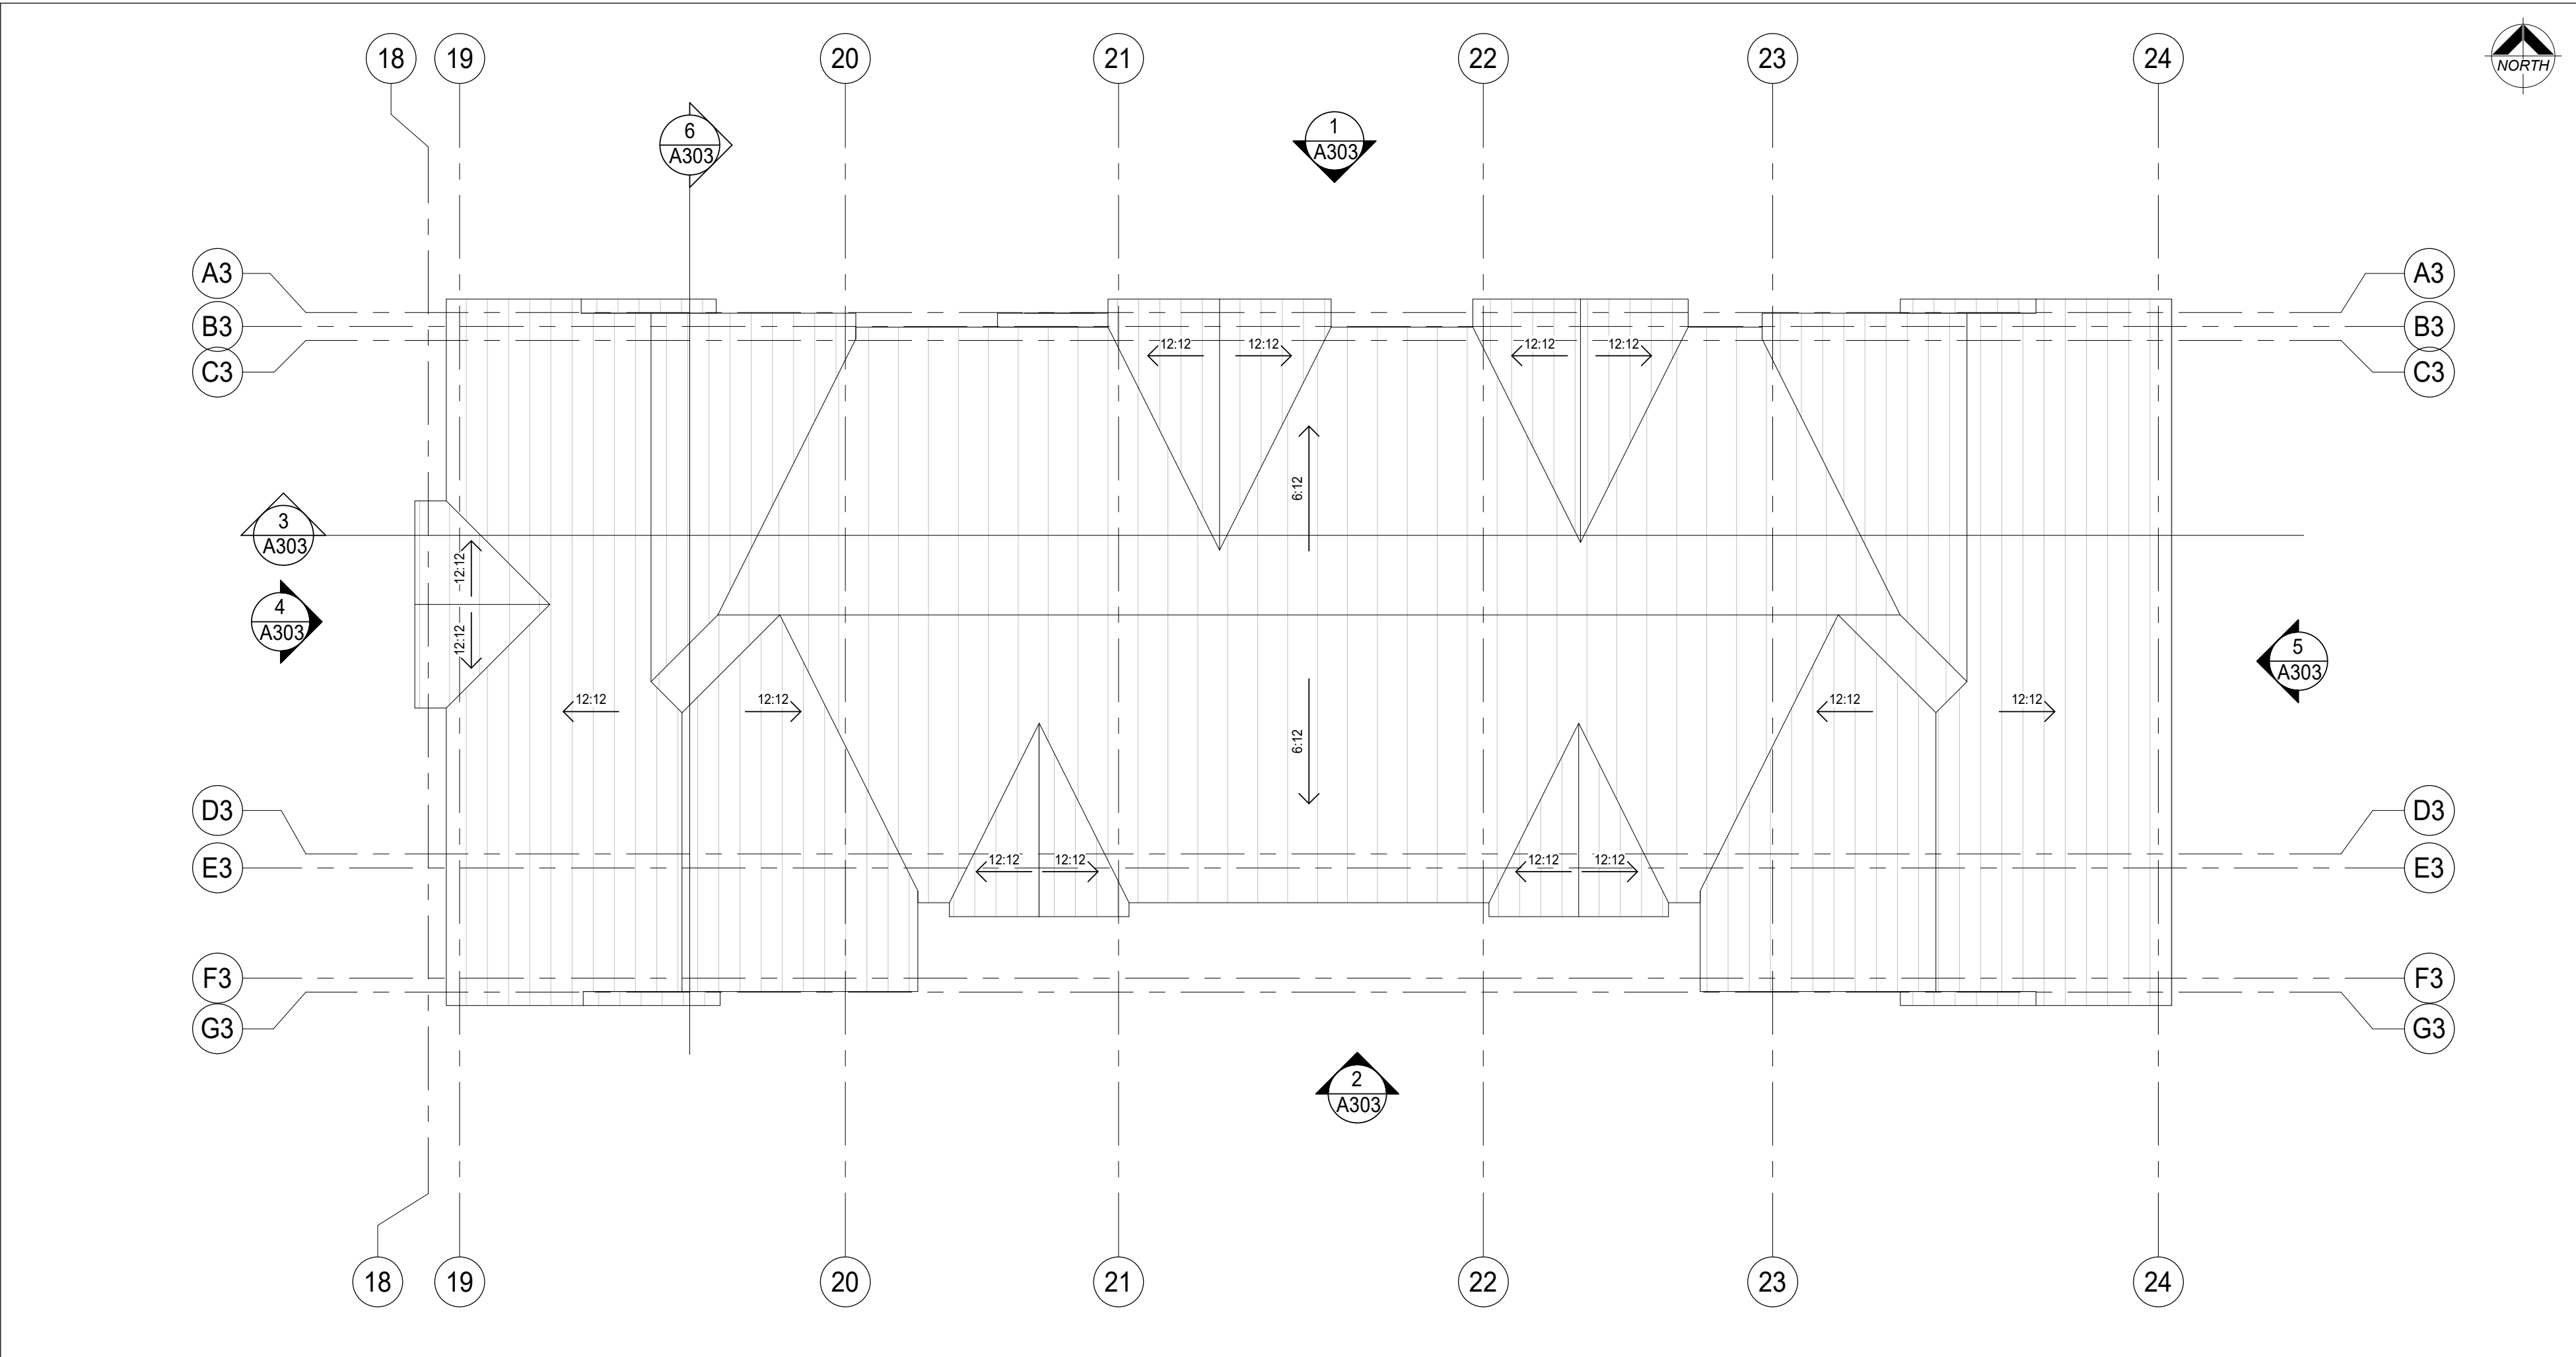

2 BUILDING 3 ROOF PLAN
A206 1 : 100

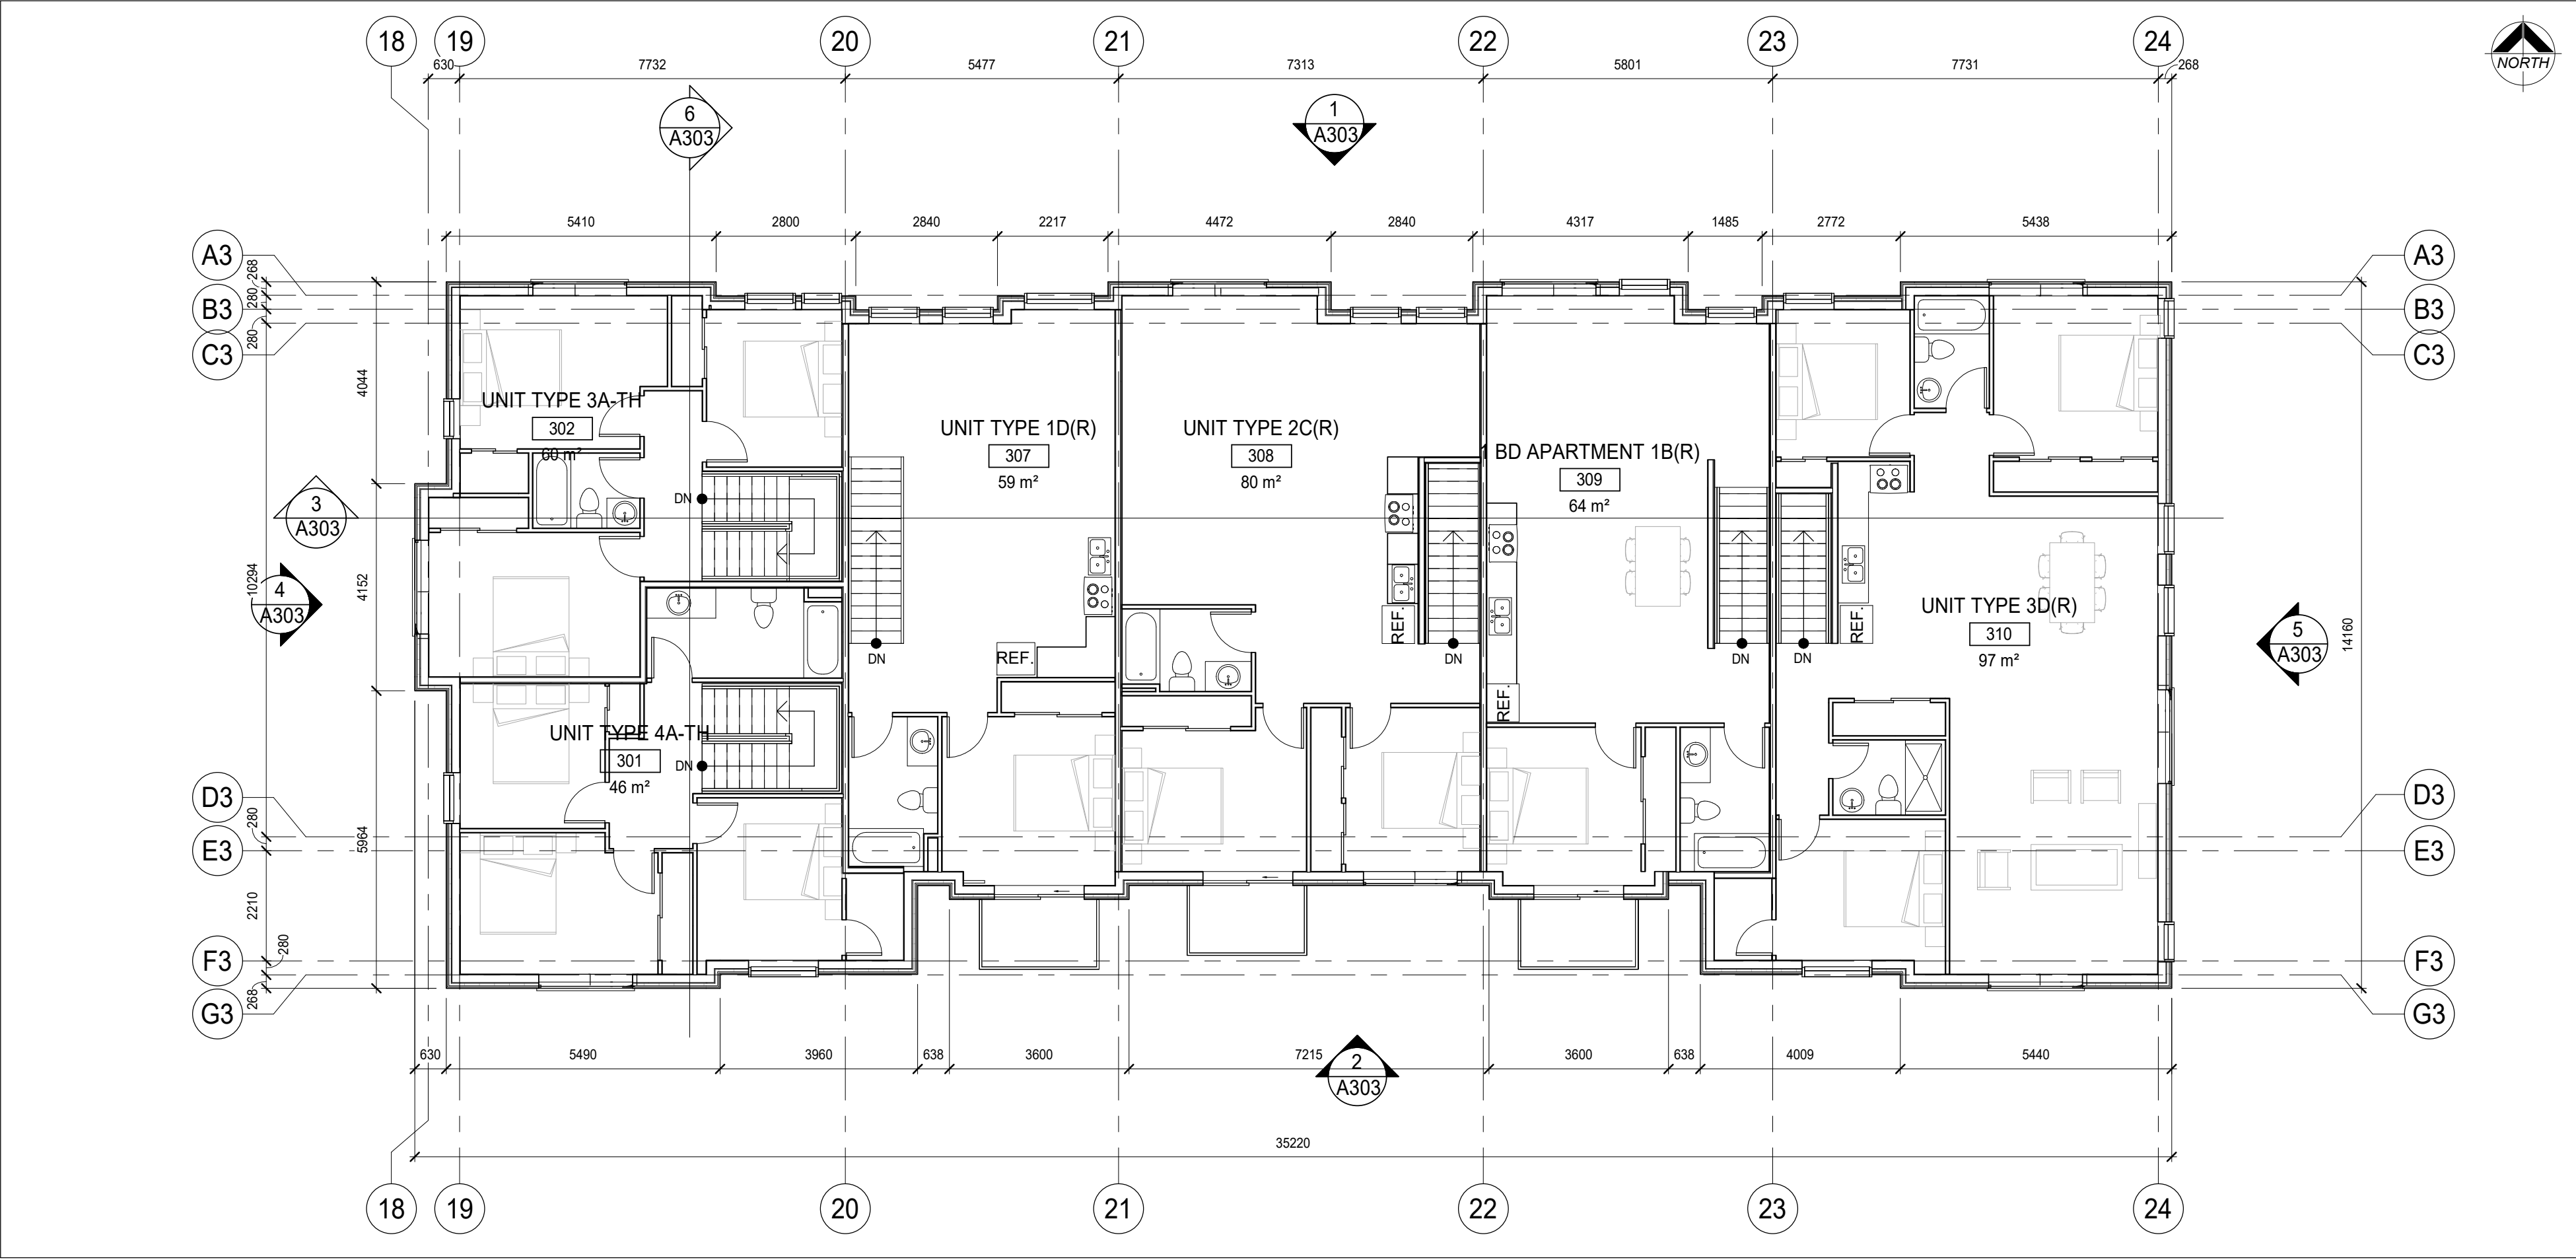

1 BUILDING 3 2ND FLOOR PLAN
A206 1 : 100

DO NOT SCALE THE DRAWINGS
CHECK AND VERIFY ALL DIMENSIONS AT THE SITE.
ALL DRAWINGS, SPECIFICATIONS AND RELATED DOCUMENTS ARE THE
COPYRIGHT PROPERTY OF THE CONSULTANT AND MUST BE RETURNED
UPON REQUEST. REPRODUCTION OF DRAWINGS IN PART OR WHOLE
WITHOUT THE PERMISSION OF THE CONSULTANT IS FORBIDDEN.
DRAWINGS ARE NOT TO BE USED FOR CONSTRUCTION UNTIL SIGNED
AND SEALED BY THE CONSULTANT.


NO.	ISSUES	DATE	BY
1	ISSUED FOR REZONING	20/06/30	BBA
2	ISSUED FOR SPA	20/12/07	BBA

NO.	REVISIONS	DATE	BY

PROJECT:
**ELGIN PARK
REDEVELOPMENT
PROJECT**

265 - 327 ELGIN STREET
COBOURG, ONTARIO
NORTHUMBERLAND COUNTY

DRAWING:
**BUILDING 3, 2ND FLOOR
& ROOF PLAN**

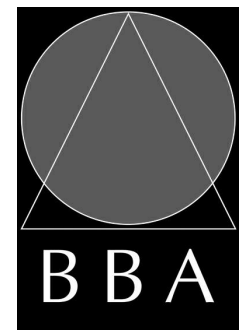

**BARRY BRYAN
ASSOCIATES**


*Architects
Engineers
Project Managers*

201-250 Water Street
Whitby Ontario L1N 0G5
Tel: (905) 666-5252
Fax: (905) 666-5256
e-mail: bba@bba-archeng.com


DESIGN BY: BBA	DOC CONTROL: DATE
DRAWN BY: NV	% COMPLETE:
CHECKED BY: NS	INITIAL:

DATE: 06/30/20
SCALE: 1 : 100
FILE:

PROJECT NO: 19284	DRAWING NO: A206
-----------------------------	----------------------------

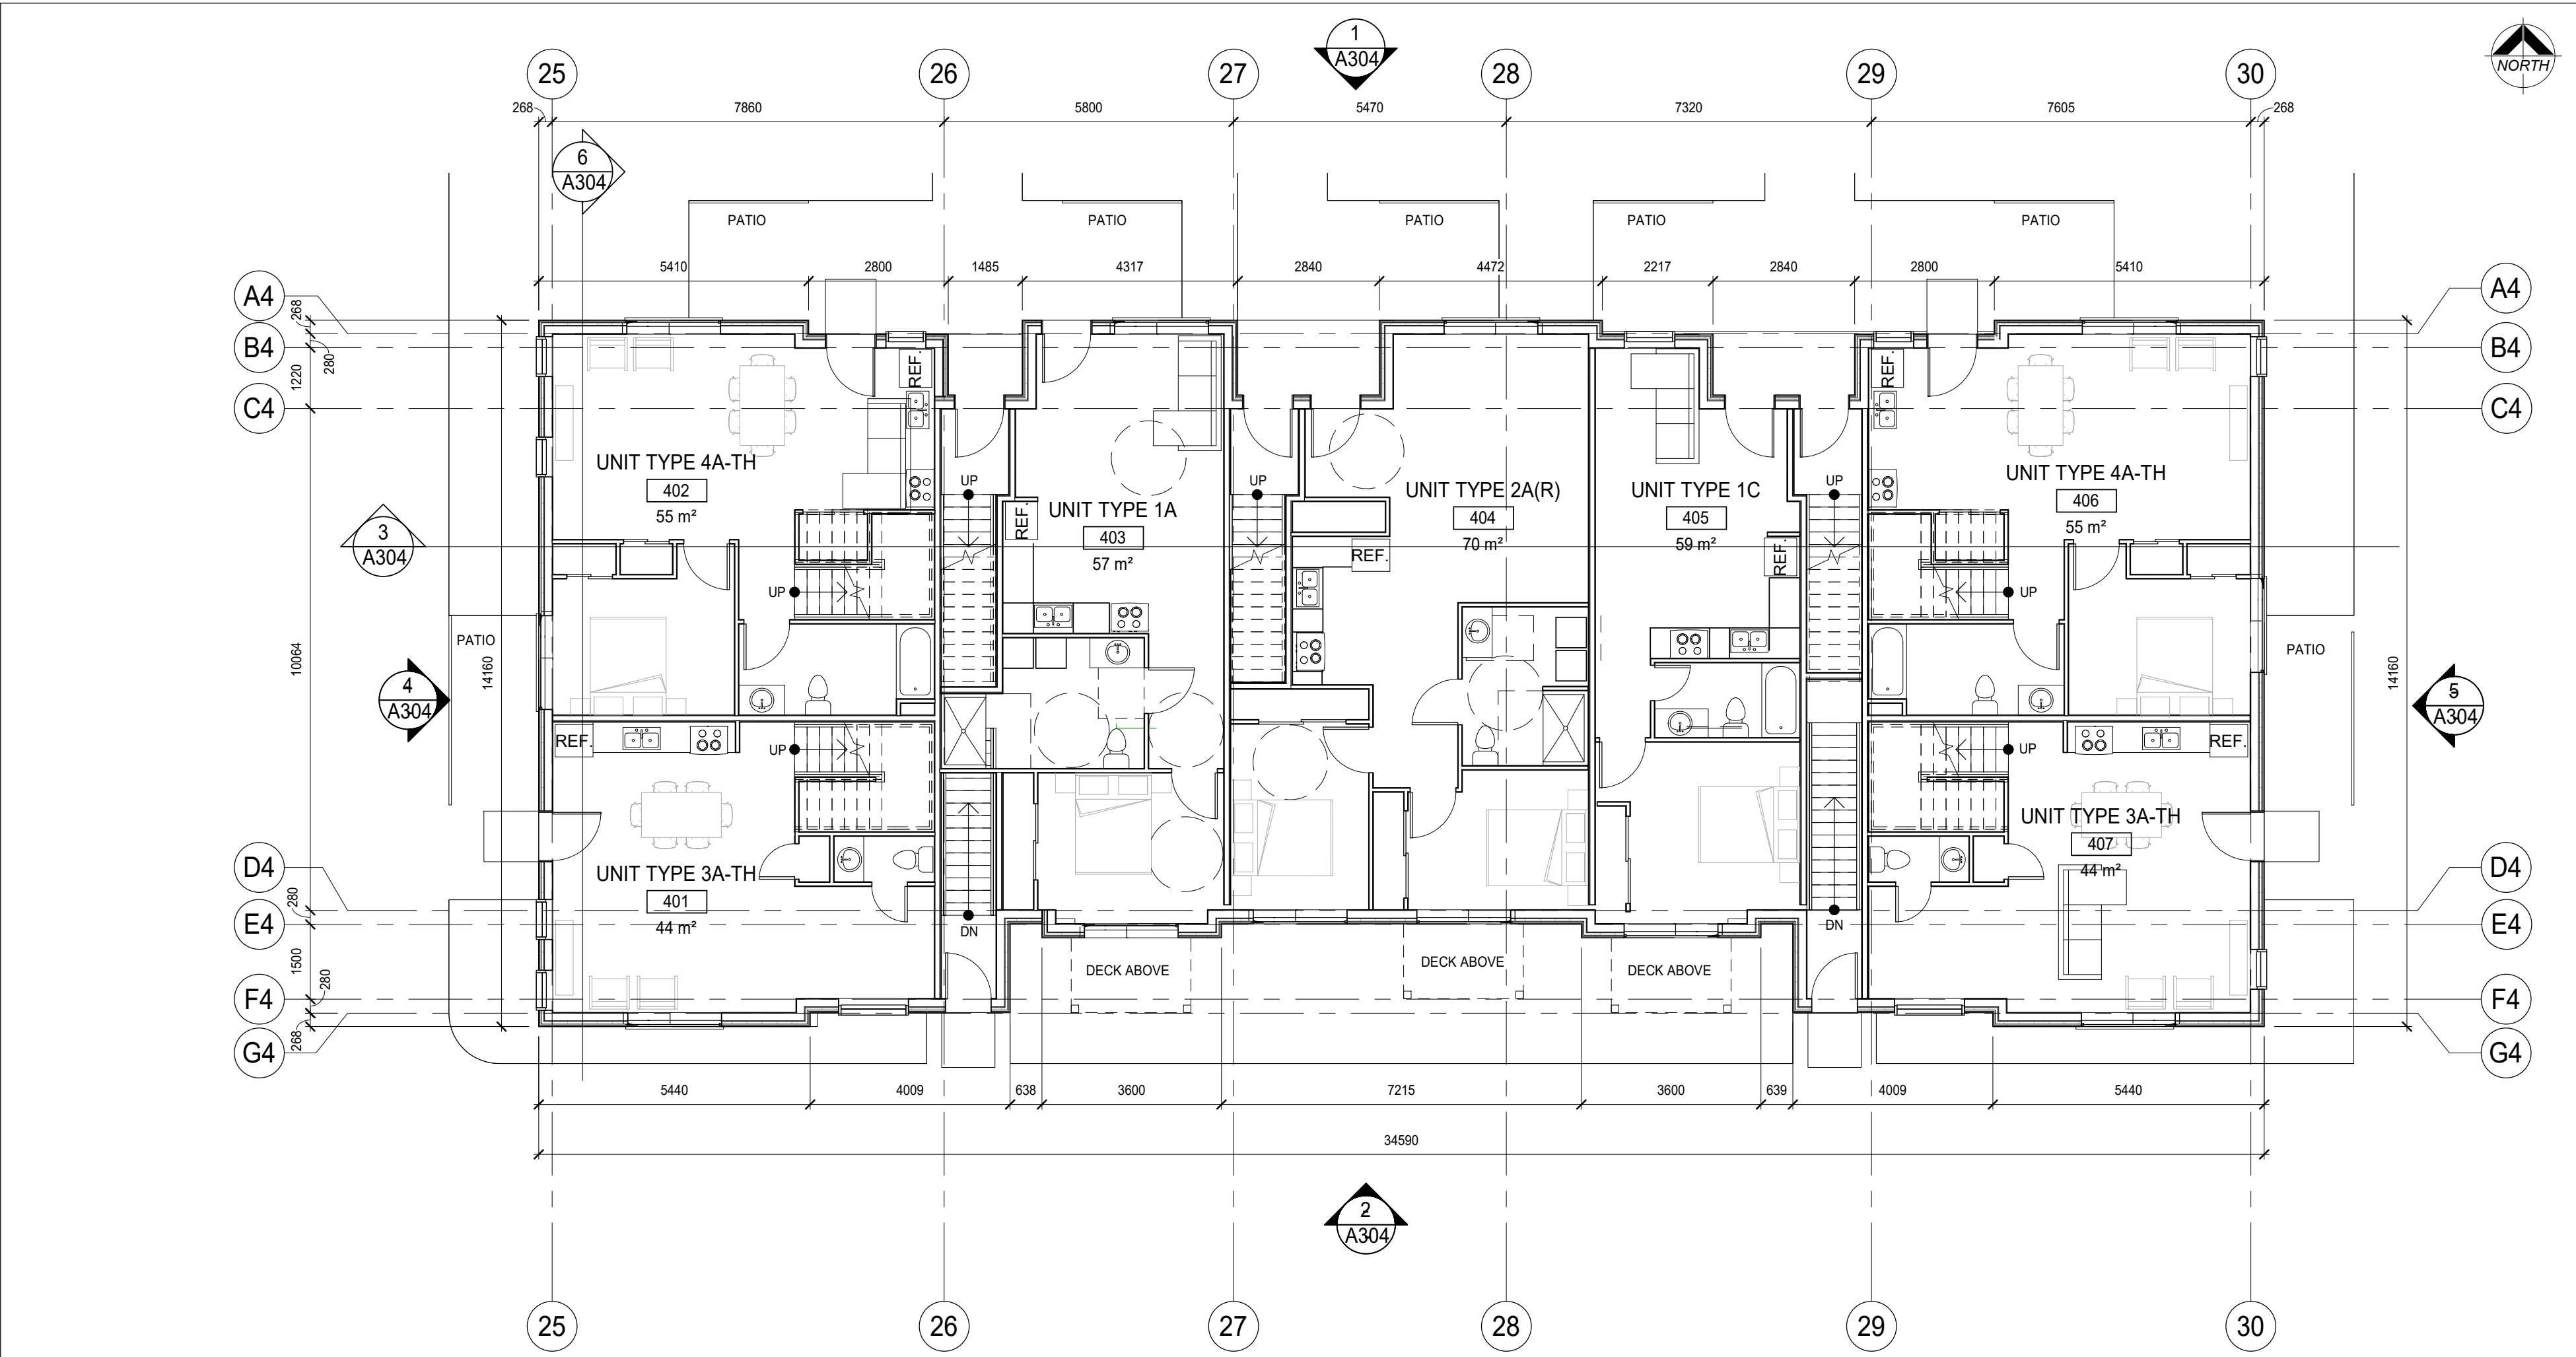

2 BUILDING 4 GROUND FLOOR PLAN
A207 1:100

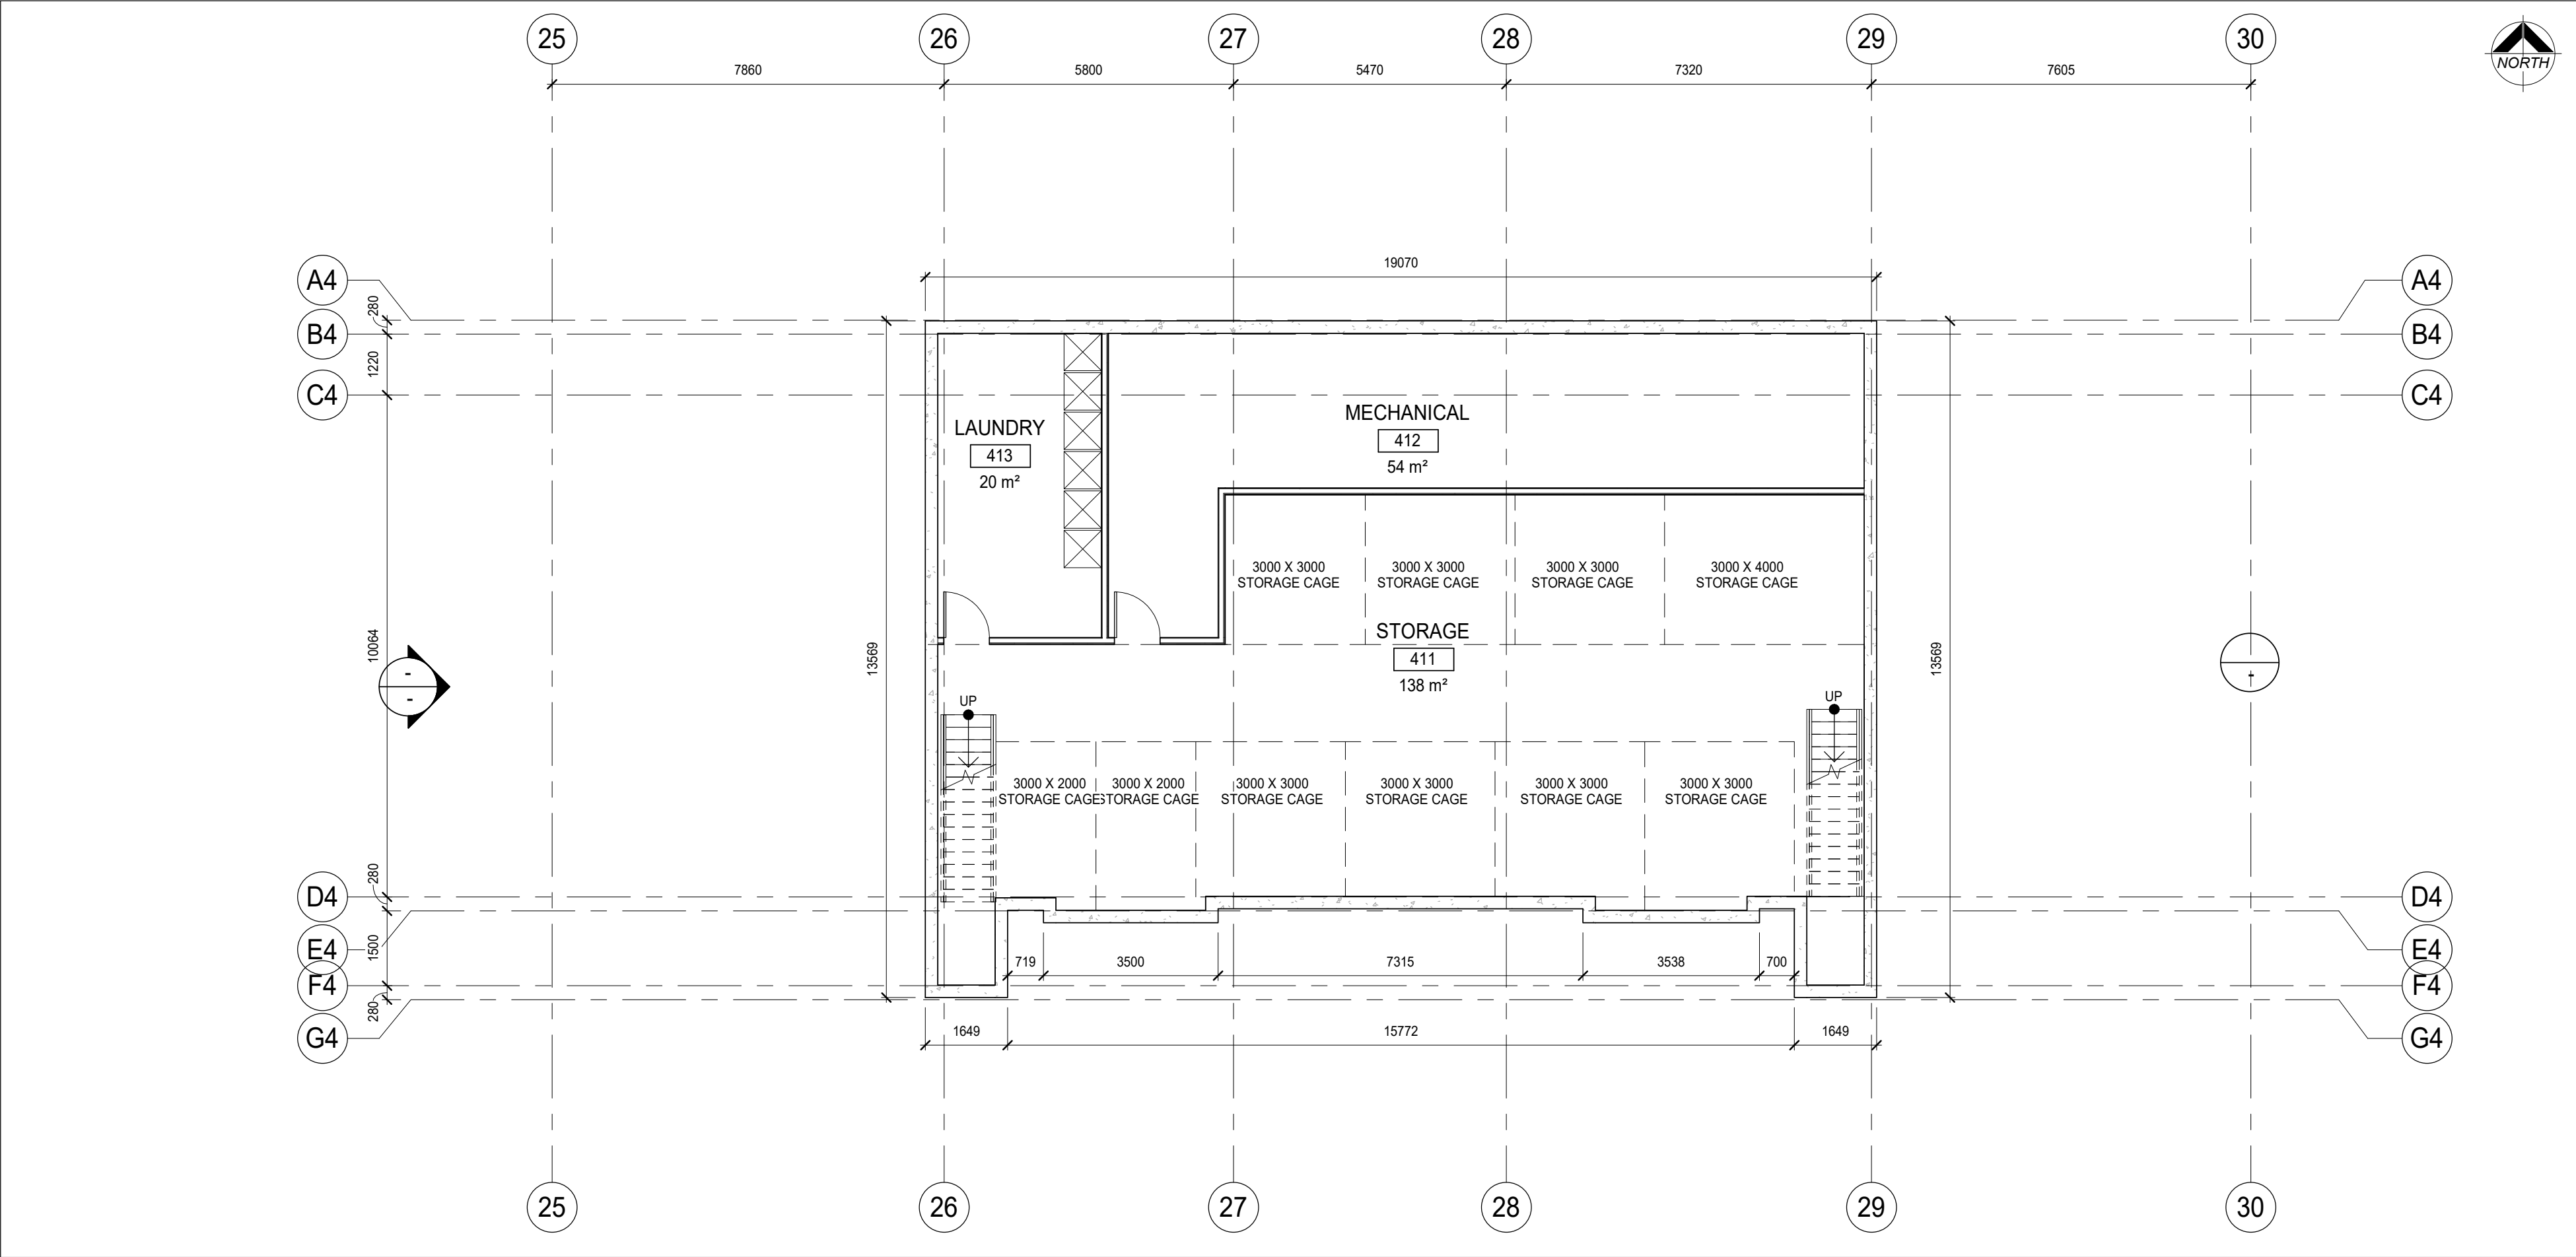

1 BUILDING 4 BASEMENT PLAN
A207 1:100

DO NOT SCALE THE DRAWINGS
CHECK AND VERIFY ALL DIMENSIONS AT THE SITE.
ALL DRAWINGS, SPECIFICATIONS AND RELATED DOCUMENTS ARE THE
COPYRIGHT PROPERTY OF THE CONSULTANT AND MUST BE RETURNED
UPON REQUEST. REPRODUCTION OF DRAWINGS IN PART OR WHOLE
WITHOUT THE PERMISSION OF THE CONSULTANT IS FORBIDDEN.
DRAWINGS ARE NOT TO BE USED FOR CONSTRUCTION UNTIL SIGNED
AND SEALED BY THE CONSULTANT.

NO.	ISSUES	DATE	BY
1	ISSUED FOR REZONING	20/06/30	BBA
2	ISSUED FOR SPA	20/12/07	BBA

NO.	REVISIONS	DATE	BY

PROJECT:
**ELGIN PARK
REDEVELOPMENT
PROJECT**
265 - 327 ELGIN STREET
COBOURG, ONTARIO
NORTHUMBERLAND COUNTY
DRAWING:
**BUILDING 4, BASEMENT
& GROUND FLOOR PLAN**




BARRY BRYAN
ASSOCIATES

Architects
Engineers
Project Managers


201-250 Water Street
Whitby Ontario L1N 0G5
Tel: (905) 666-5252
Fax: (905) 666-5256
e-mail: bba@bba-archeng.com

DESIGN BY: BBA	DOC CONTROL DATE
DRAWN BY: NV	% COMPLETE:
CHECKED BY: NS	INITIAL:
DATE: 11/02/20	SCALE: 1 : 100
FILE:	

PROJECT NO:
19284
DRAWING NO:
A207

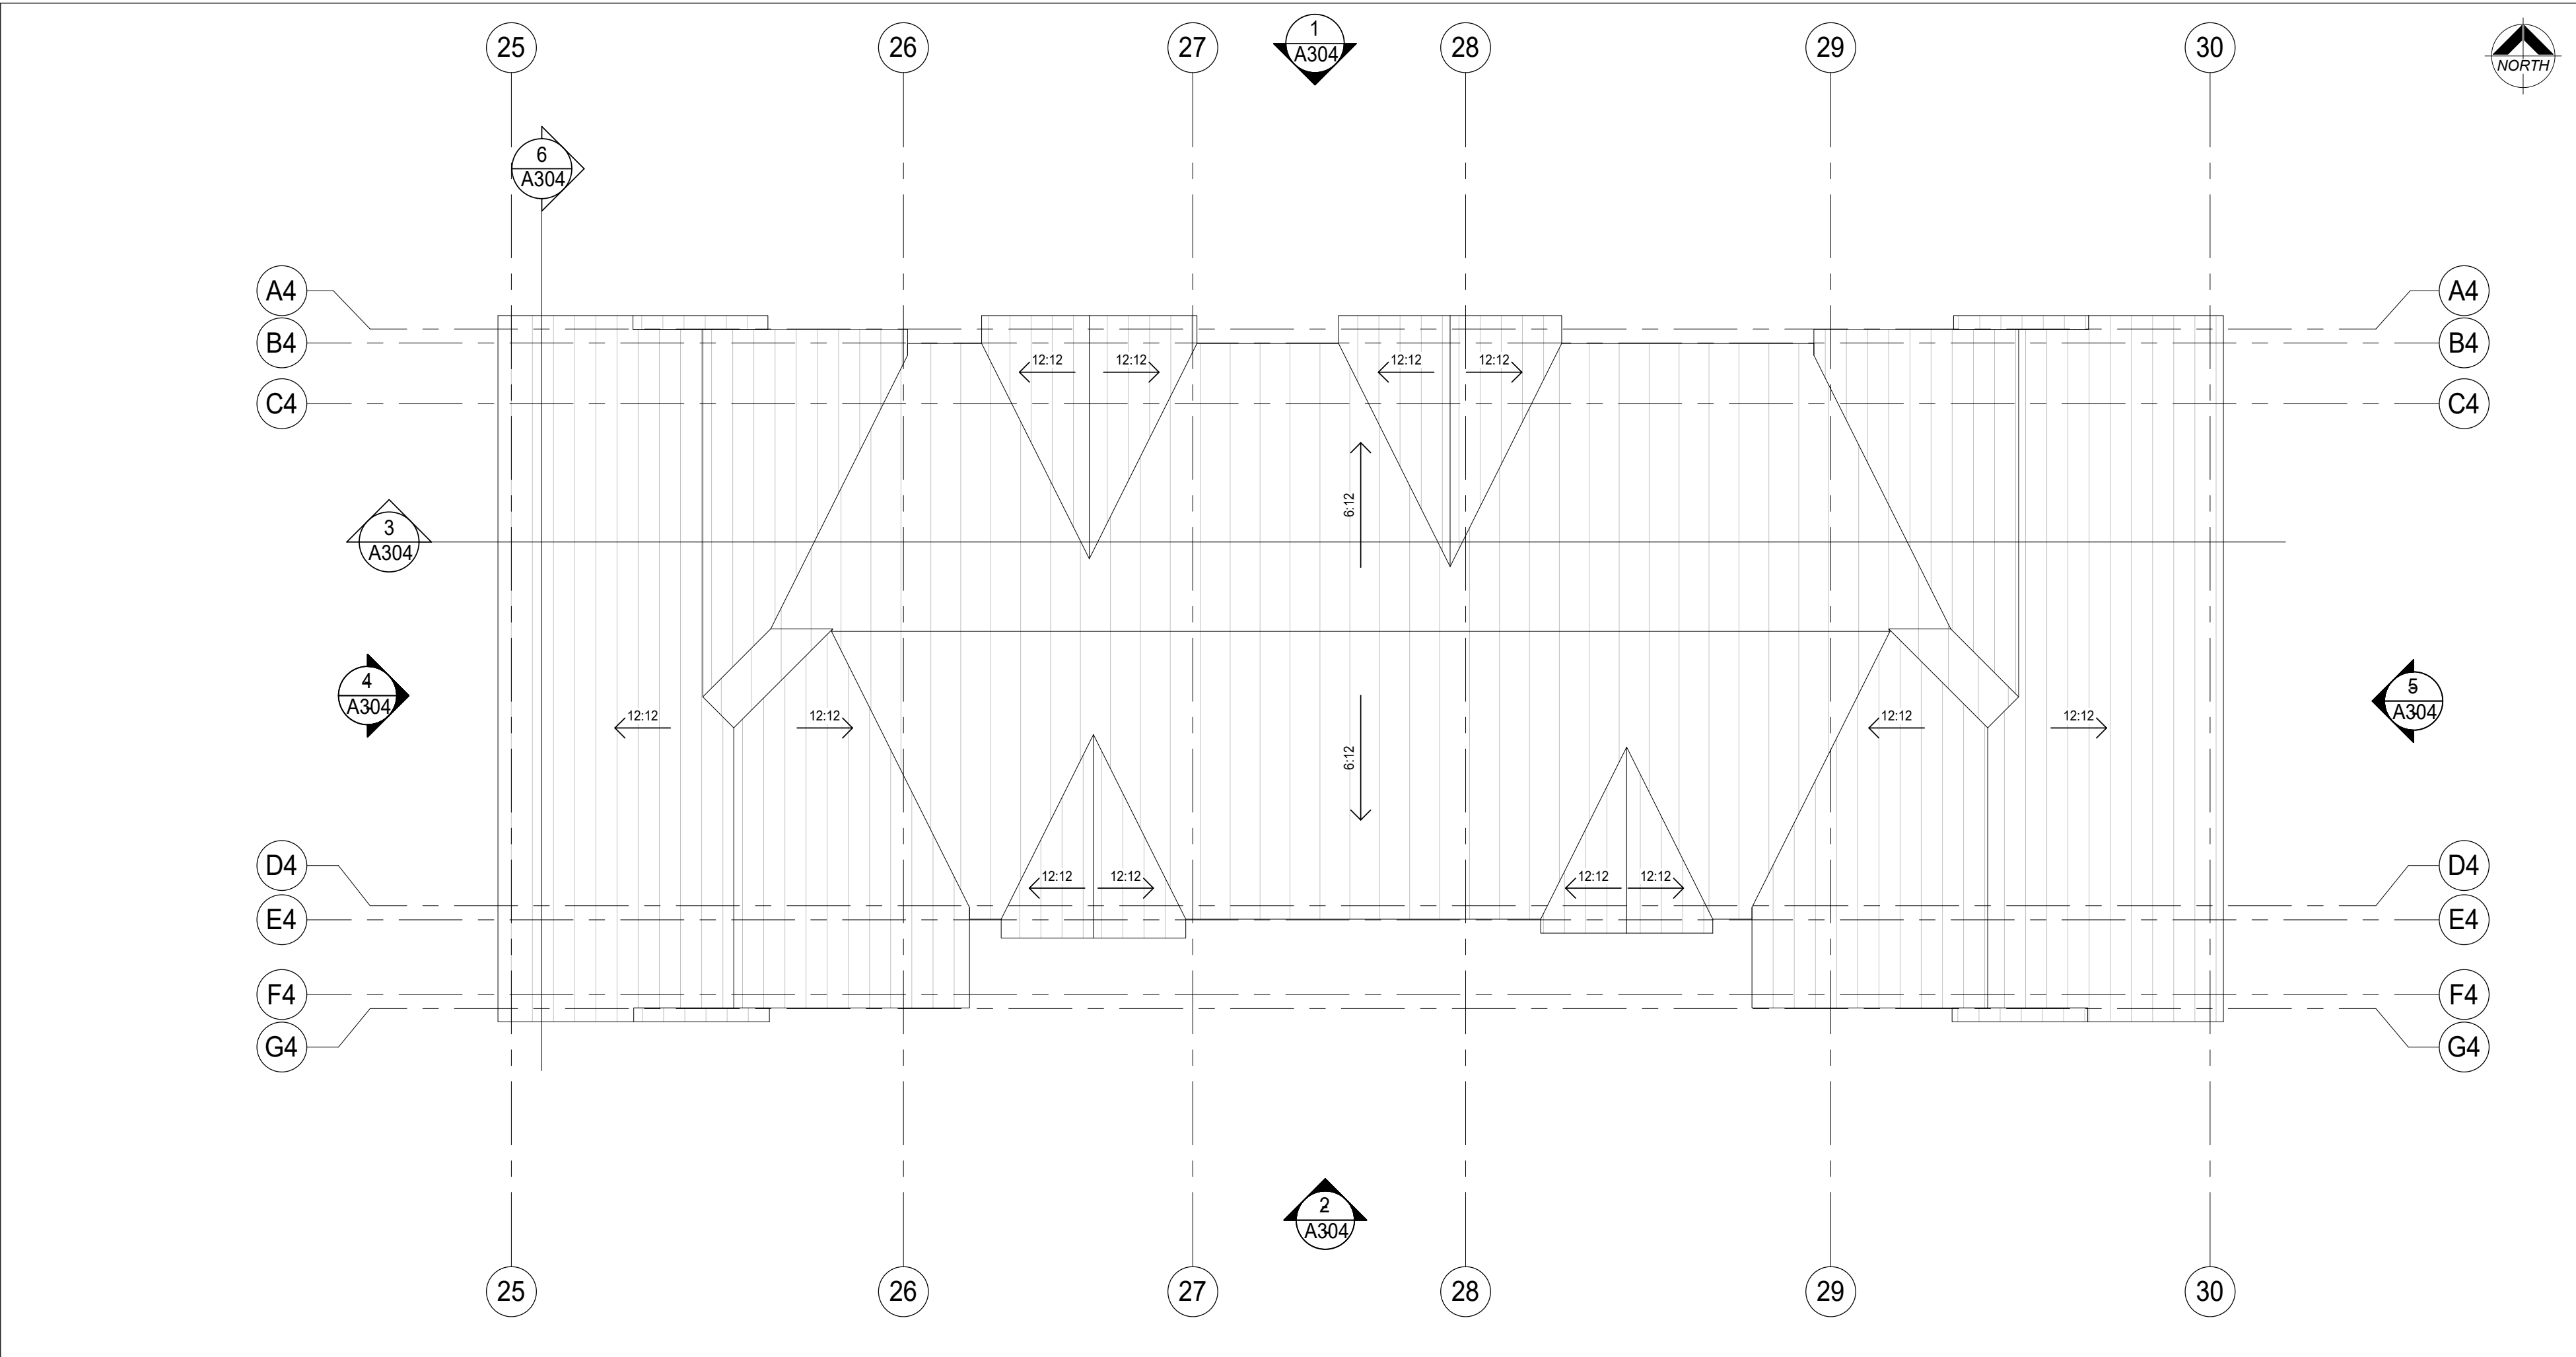

2
A208
BUILDING 4 ROOF PLAN
1 : 100

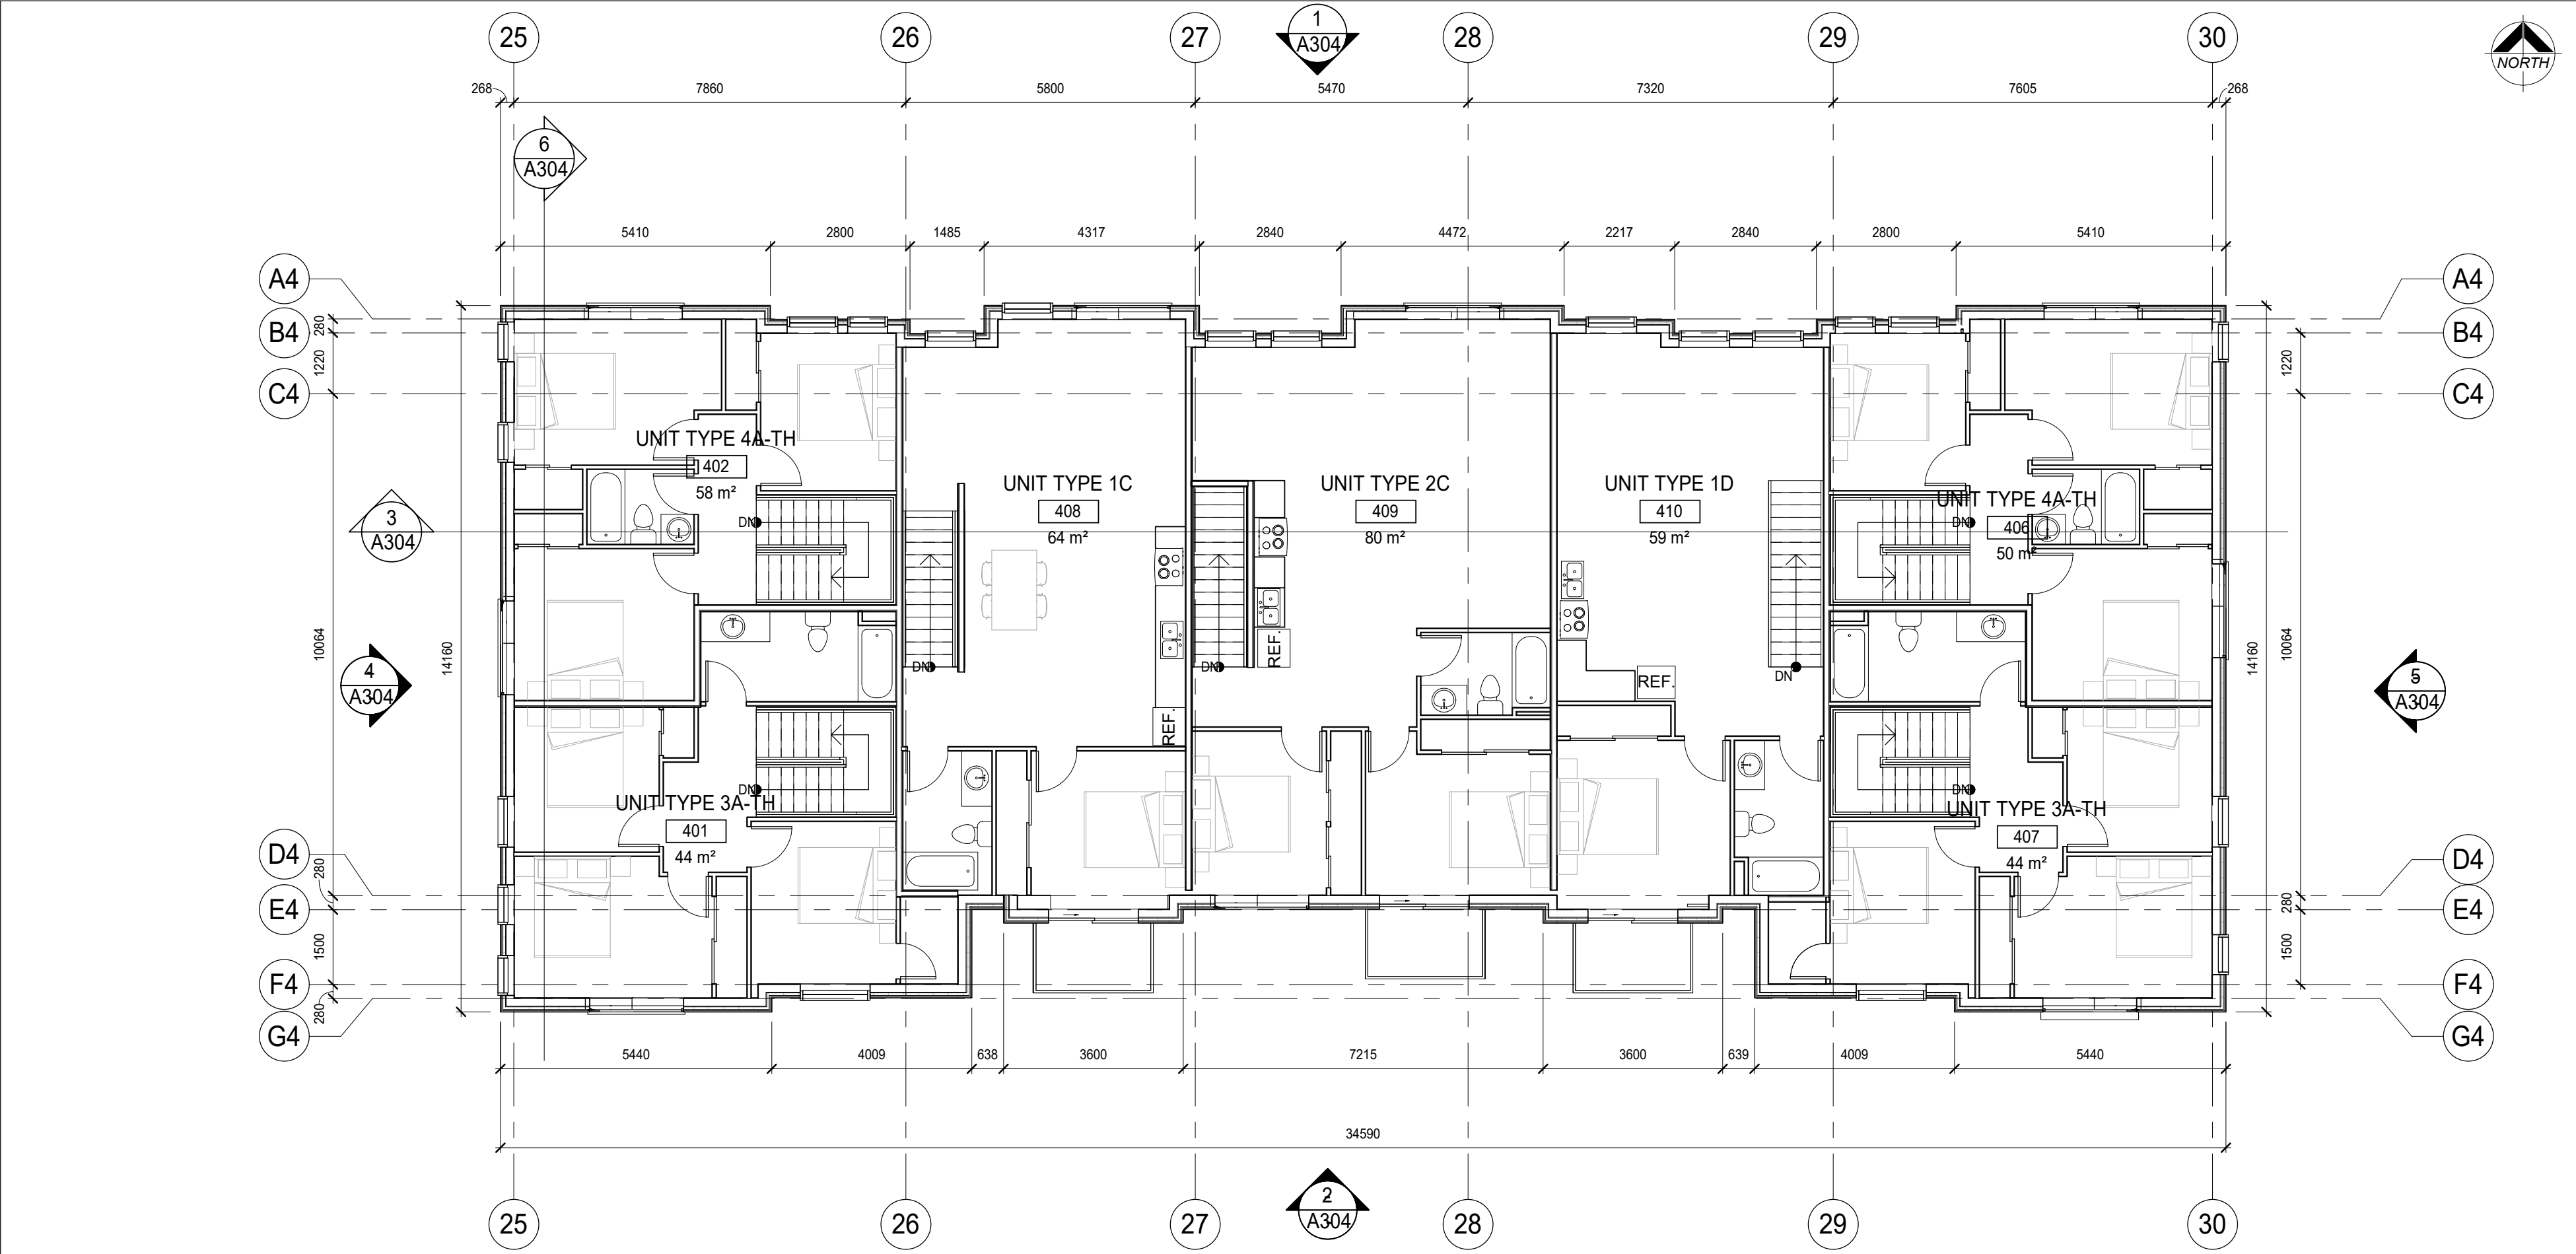

1
A208
BUILDING 4 2ND FLOOR PLAN
1 : 100

DO NOT SCALE THE DRAWINGS
CHECK AND VERIFY ALL DIMENSIONS AT THE SITE.
ALL DRAWINGS, SPECIFICATIONS AND RELATED DOCUMENTS ARE THE
COPYRIGHT PROPERTY OF THE CONSULTANT AND MUST BE RETURNED
UPON REQUEST. REPRODUCTION OF DRAWINGS IN PART OR WHOLE
WITHOUT THE PERMISSION OF THE CONSULTANT IS FORBIDDEN.
DRAWINGS ARE NOT TO BE USED FOR CONSTRUCTION UNTIL SIGNED
AND SEALED BY THE CONSULTANT.


NO.	ISSUES	DATE	BY
1	ISSUED FOR REZONING	20/06/30	BBA
2	ISSUED FOR SPA	20/12/07	BBA

NO.	REVISIONS	DATE	BY

PROJECT:
**ELGIN PARK
REDEVELOPMENT
PROJECT**

265 - 327 ELGIN STREET
COBOURG, ONTARIO
NORTHUMBERLAND COUNTY

DRAWING:
**BUILDING 4, 2ND FLOOR
& ROOF PLAN**

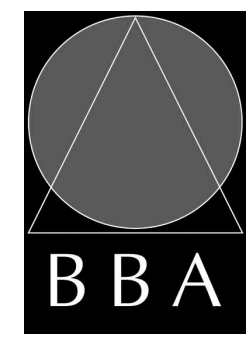

**BARRY BRYAN
ASSOCIATES**


*Architects
Engineers
Project Managers*

201-250 Water Street
Whitby Ontario L1N 0G5
Tel: (905) 666-5252
Fax: (905) 666-5256
e-mail: bba@bba-archeng.com


DESIGN BY: BBA	DOC CONTROL: DATE
DRAWN BY: NV	% COMPLETE:
CHECKED BY: NS	INITIAL:
DATE: 11/02/20	SCALE: 1 : 100
FILE:	

PROJECT NO:
19284

DRAWING NO:
A208

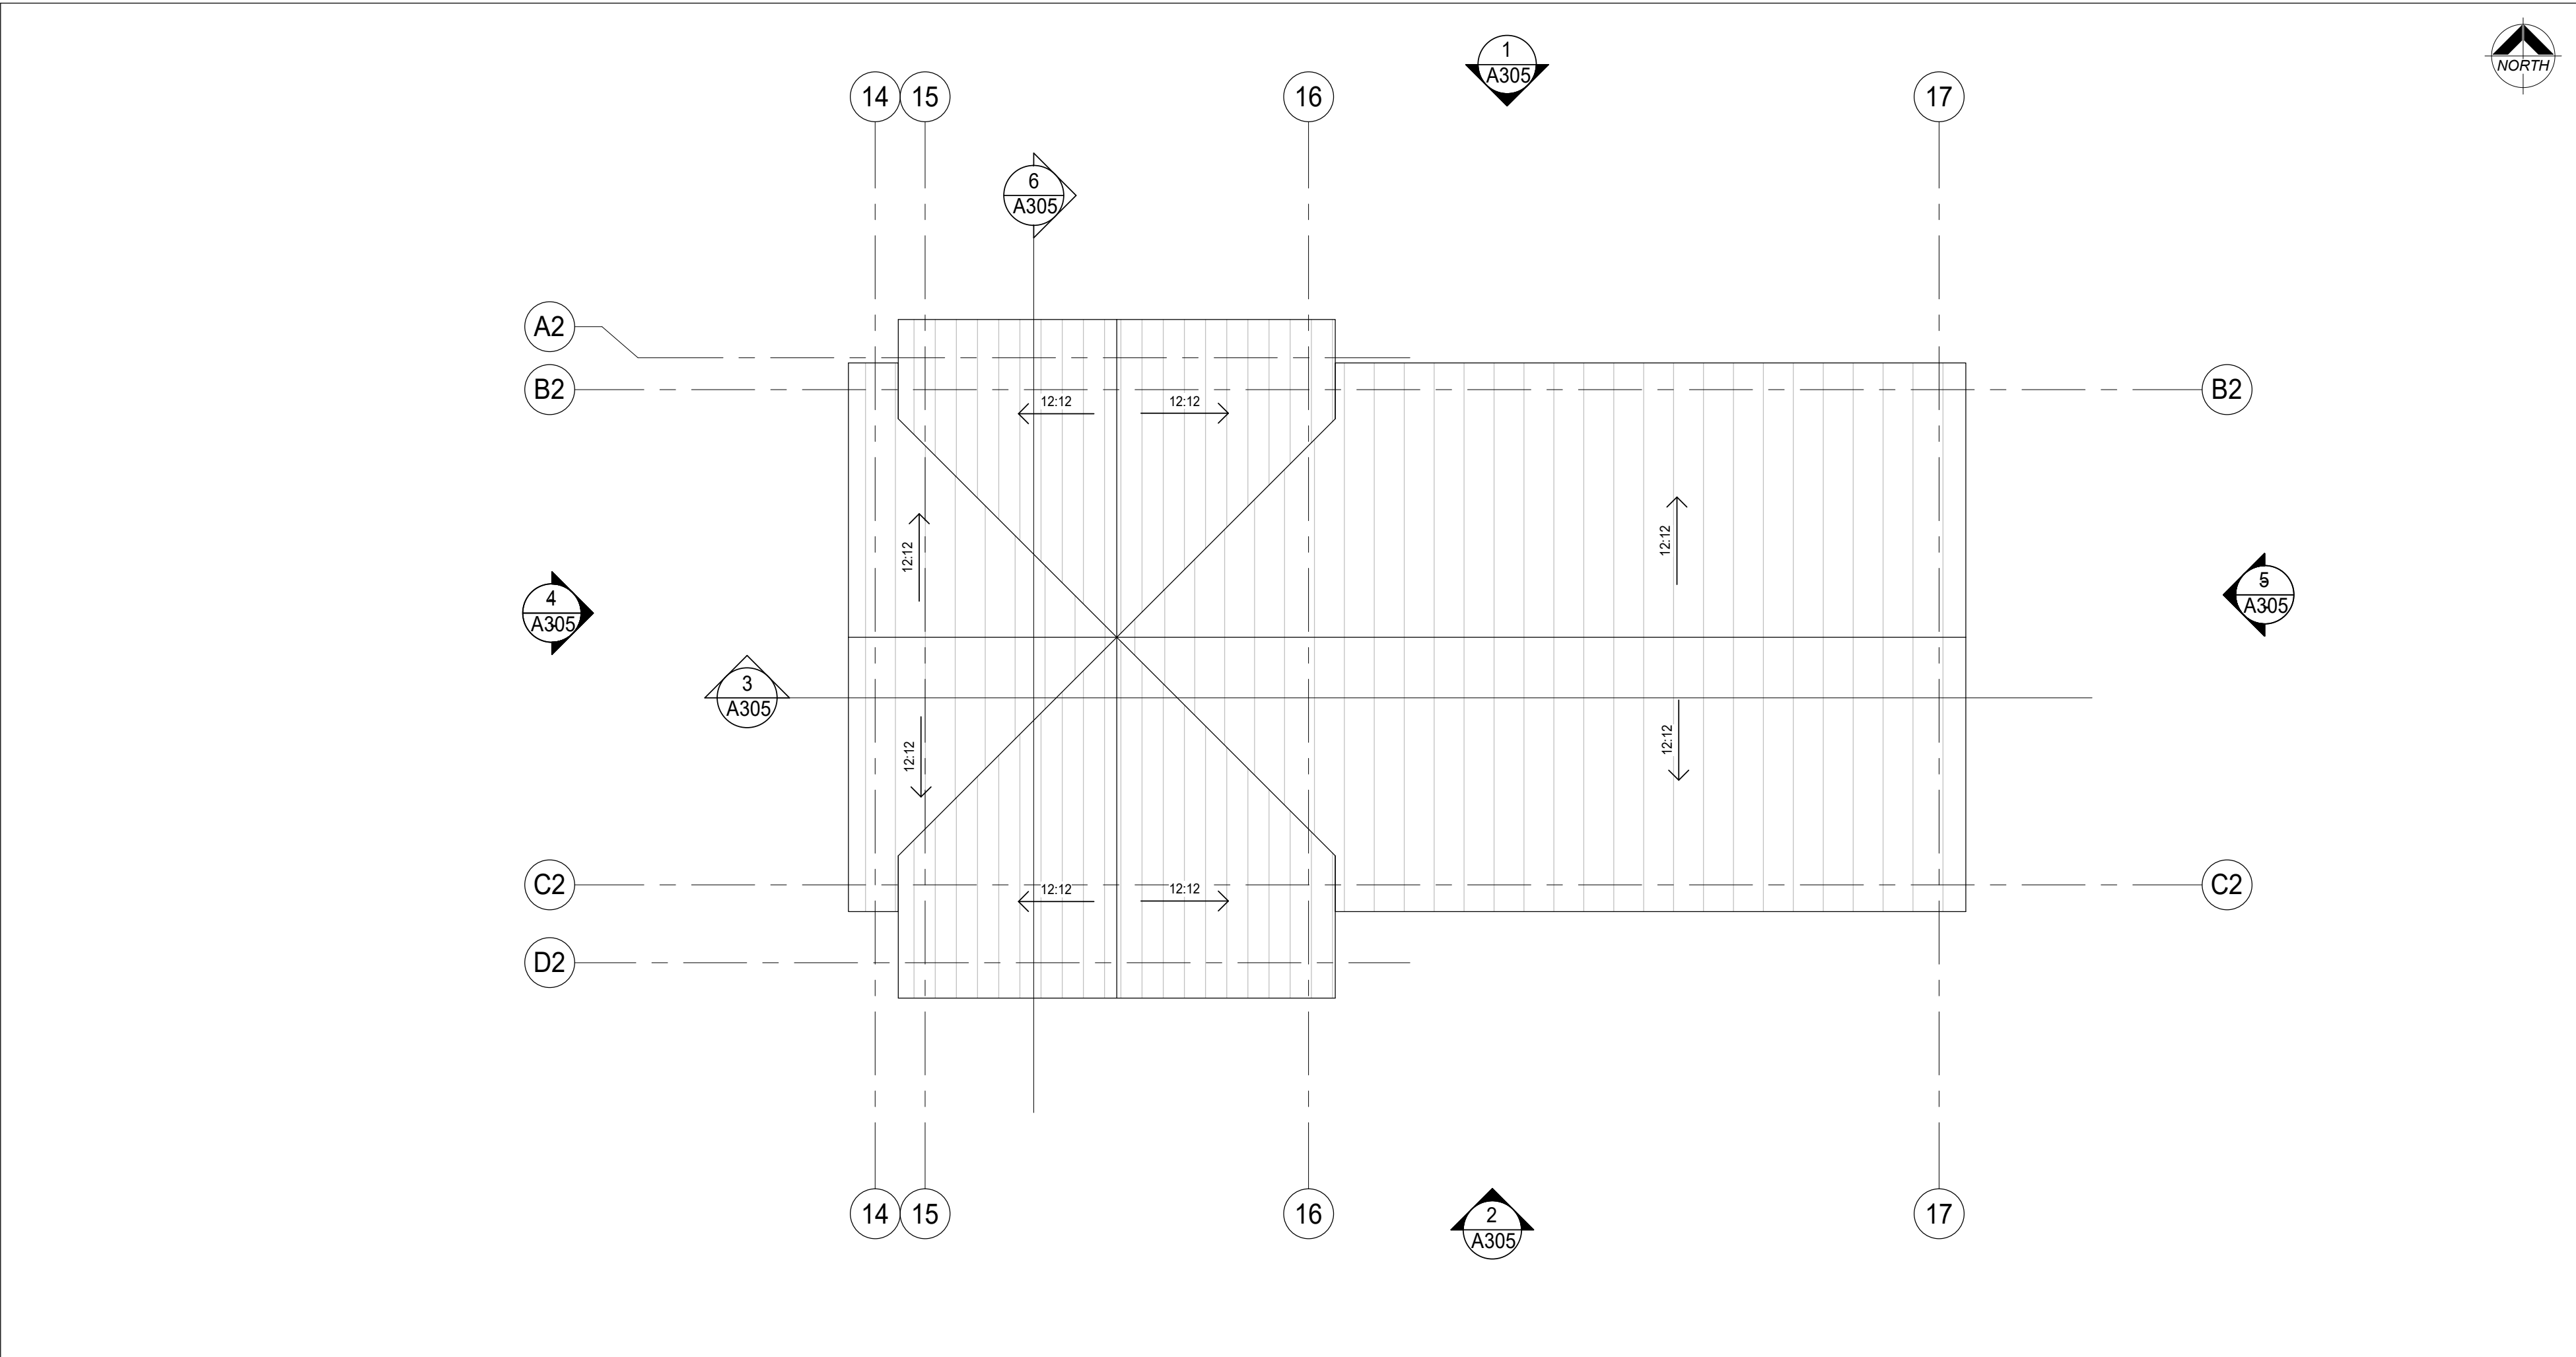

2 BUILDING 5 ROOF PLAN
A209 1:50

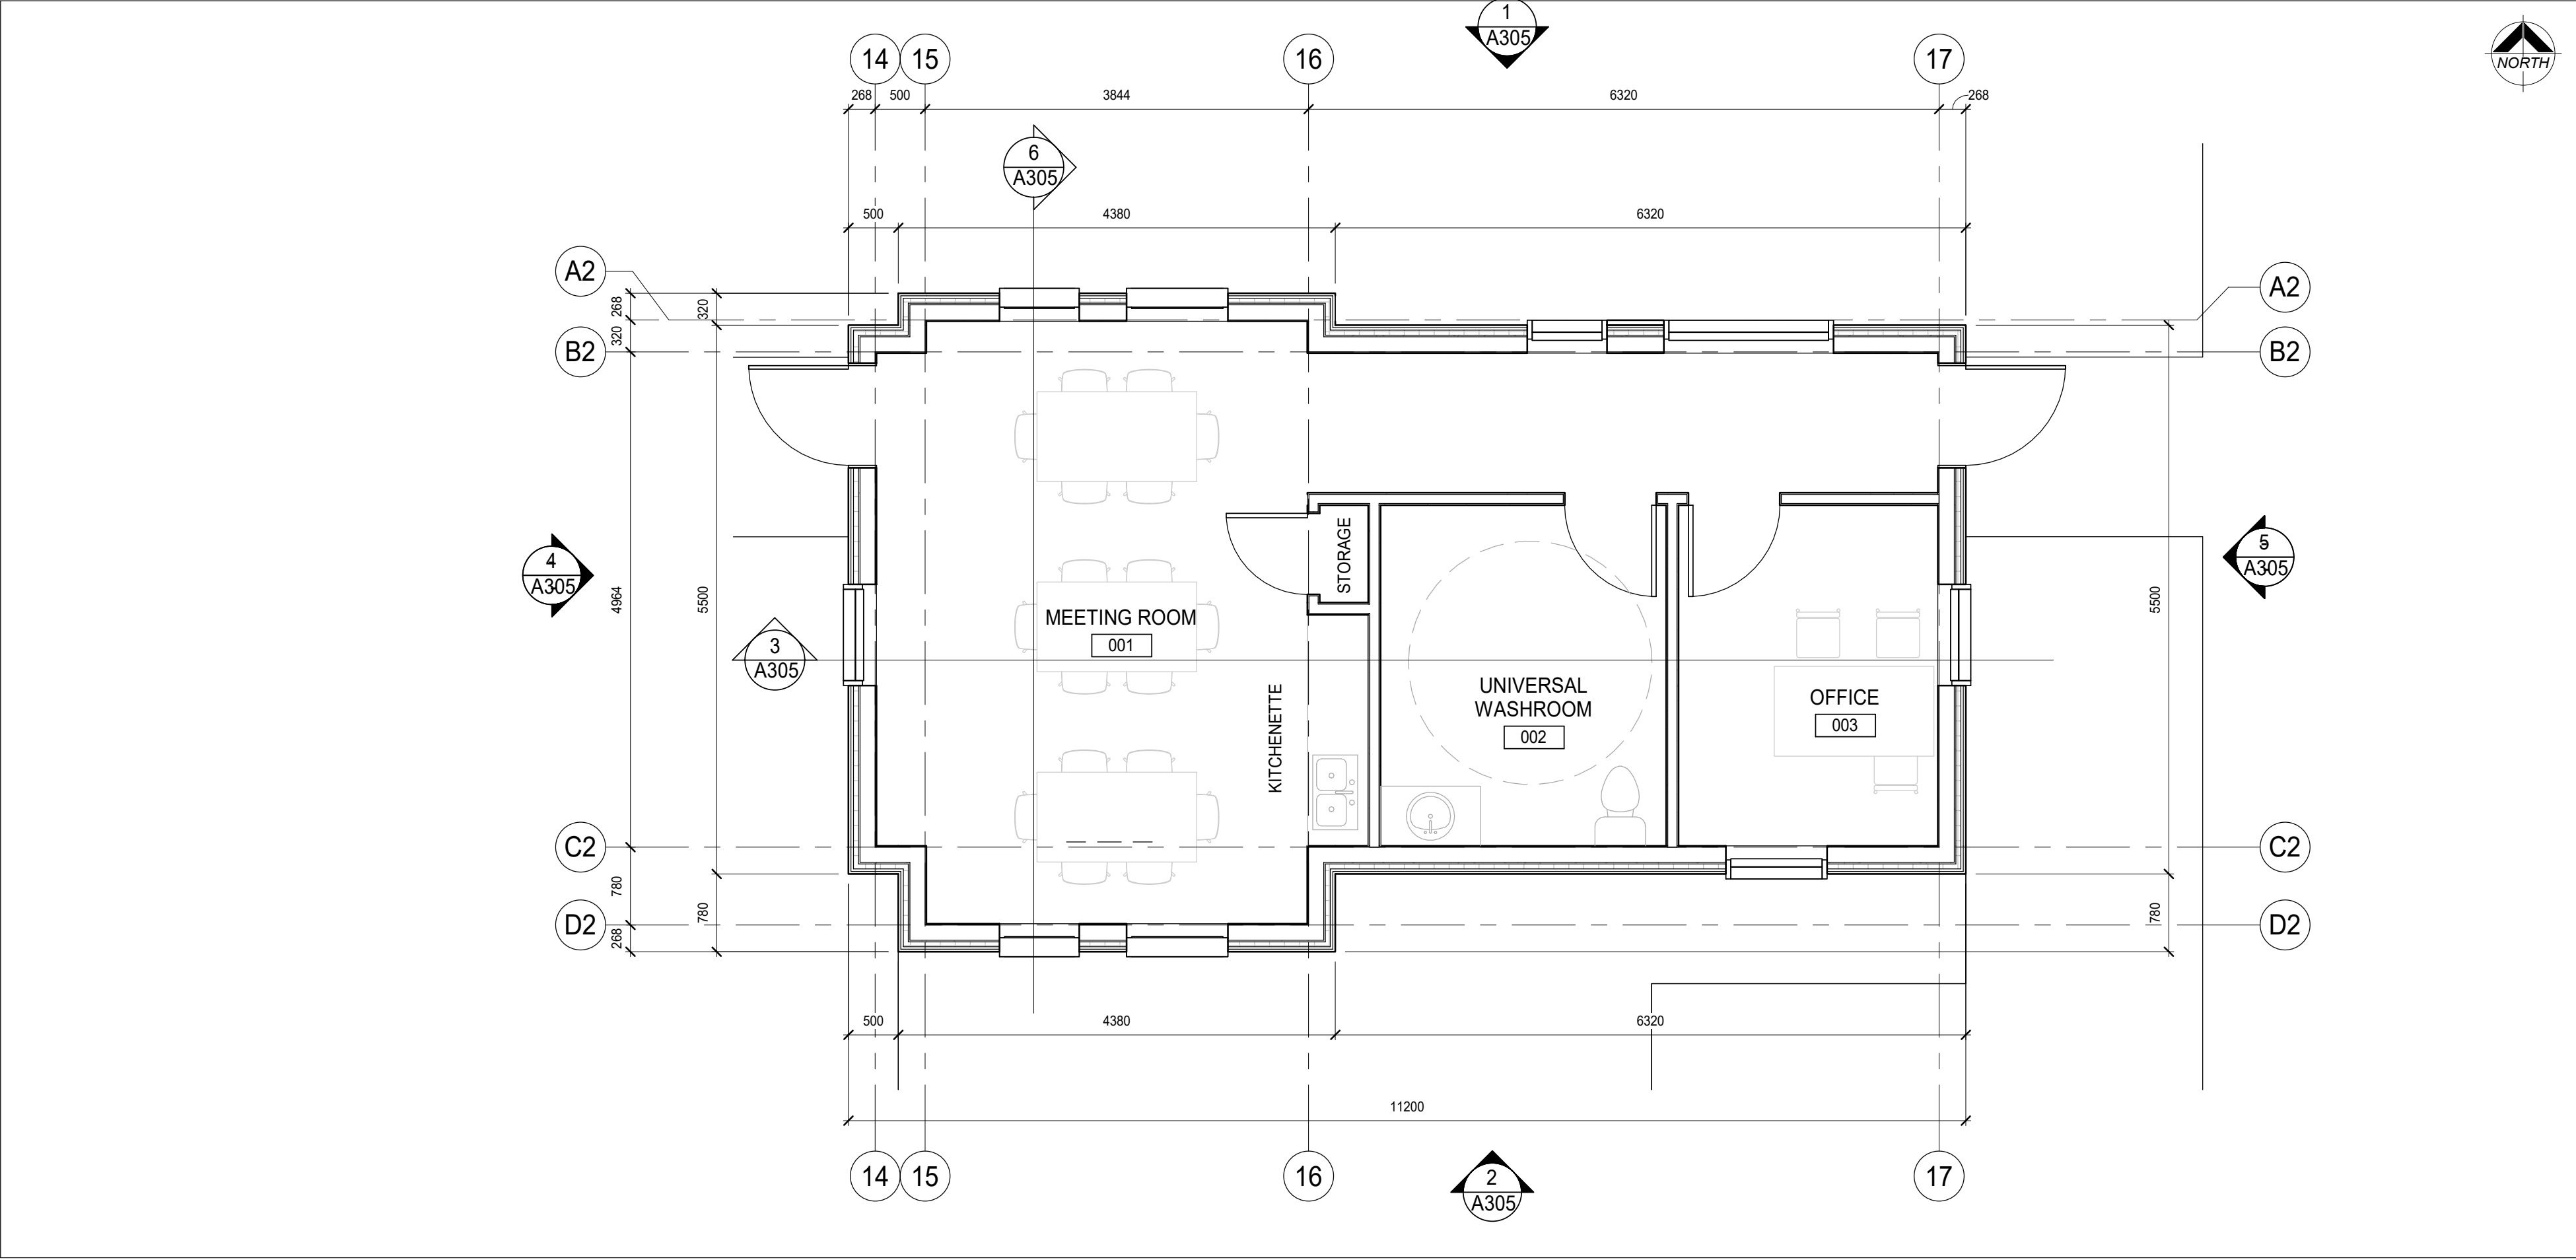

1 BUILDING 5 FLOOR PLAN
A209 1:50

DO NOT SCALE THE DRAWINGS
CHECK AND VERIFY ALL DIMENSIONS AT THE SITE.
ALL DRAWINGS, SPECIFICATIONS AND RELATED DOCUMENTS ARE THE
COPYRIGHT PROPERTY OF THE CONSULTANT AND MUST BE RETURNED
UPON REQUEST. REPRODUCTION OF DRAWINGS IN PART OR WHOLE
WITHOUT THE PERMISSION OF THE CONSULTANT IS FORBIDDEN.
DRAWINGS ARE NOT TO BE USED FOR CONSTRUCTION UNTIL SIGNED
AND SEALED BY THE CONSULTANT.

NO.	ISSUES	DATE	BY
1	ISSUED FOR REZONING	20/06/30	BBA
2	ISSUED FOR SPA	20/12/07	BBA

NO.	REVISIONS	DATE	BY

PROJECT:
**ELGIN PARK
REDEVELOPMENT
PROJECT**

265 - 327 ELGIN STREET
COBOURG, ONTARIO
NORTHUMBERLAND COUNTY

DRAWING:
**BUILDING 5, FLOOR
PLAN & ROOF PLAN**



BARRY BRYAN
ASSOCIATES


Architects
Engineers
Project Managers

201-250 Water Street
Whitby Ontario L1N 0G5
Tel: (905) 666-5252
Fax: (905) 666-5256
e-mail: bba@bba-archeng.com

DESIGN BY: BBA	DOC CONTROL: DATE
DRAWN BY: NV	% COMPLETE:
CHECKED BY: NS	INITIAL:

DATE: 06/30/20
SCALE: 1 : 50
FILE:


PROJECT NO: 19284	DRAWING NO: A209
-----------------------------	----------------------------

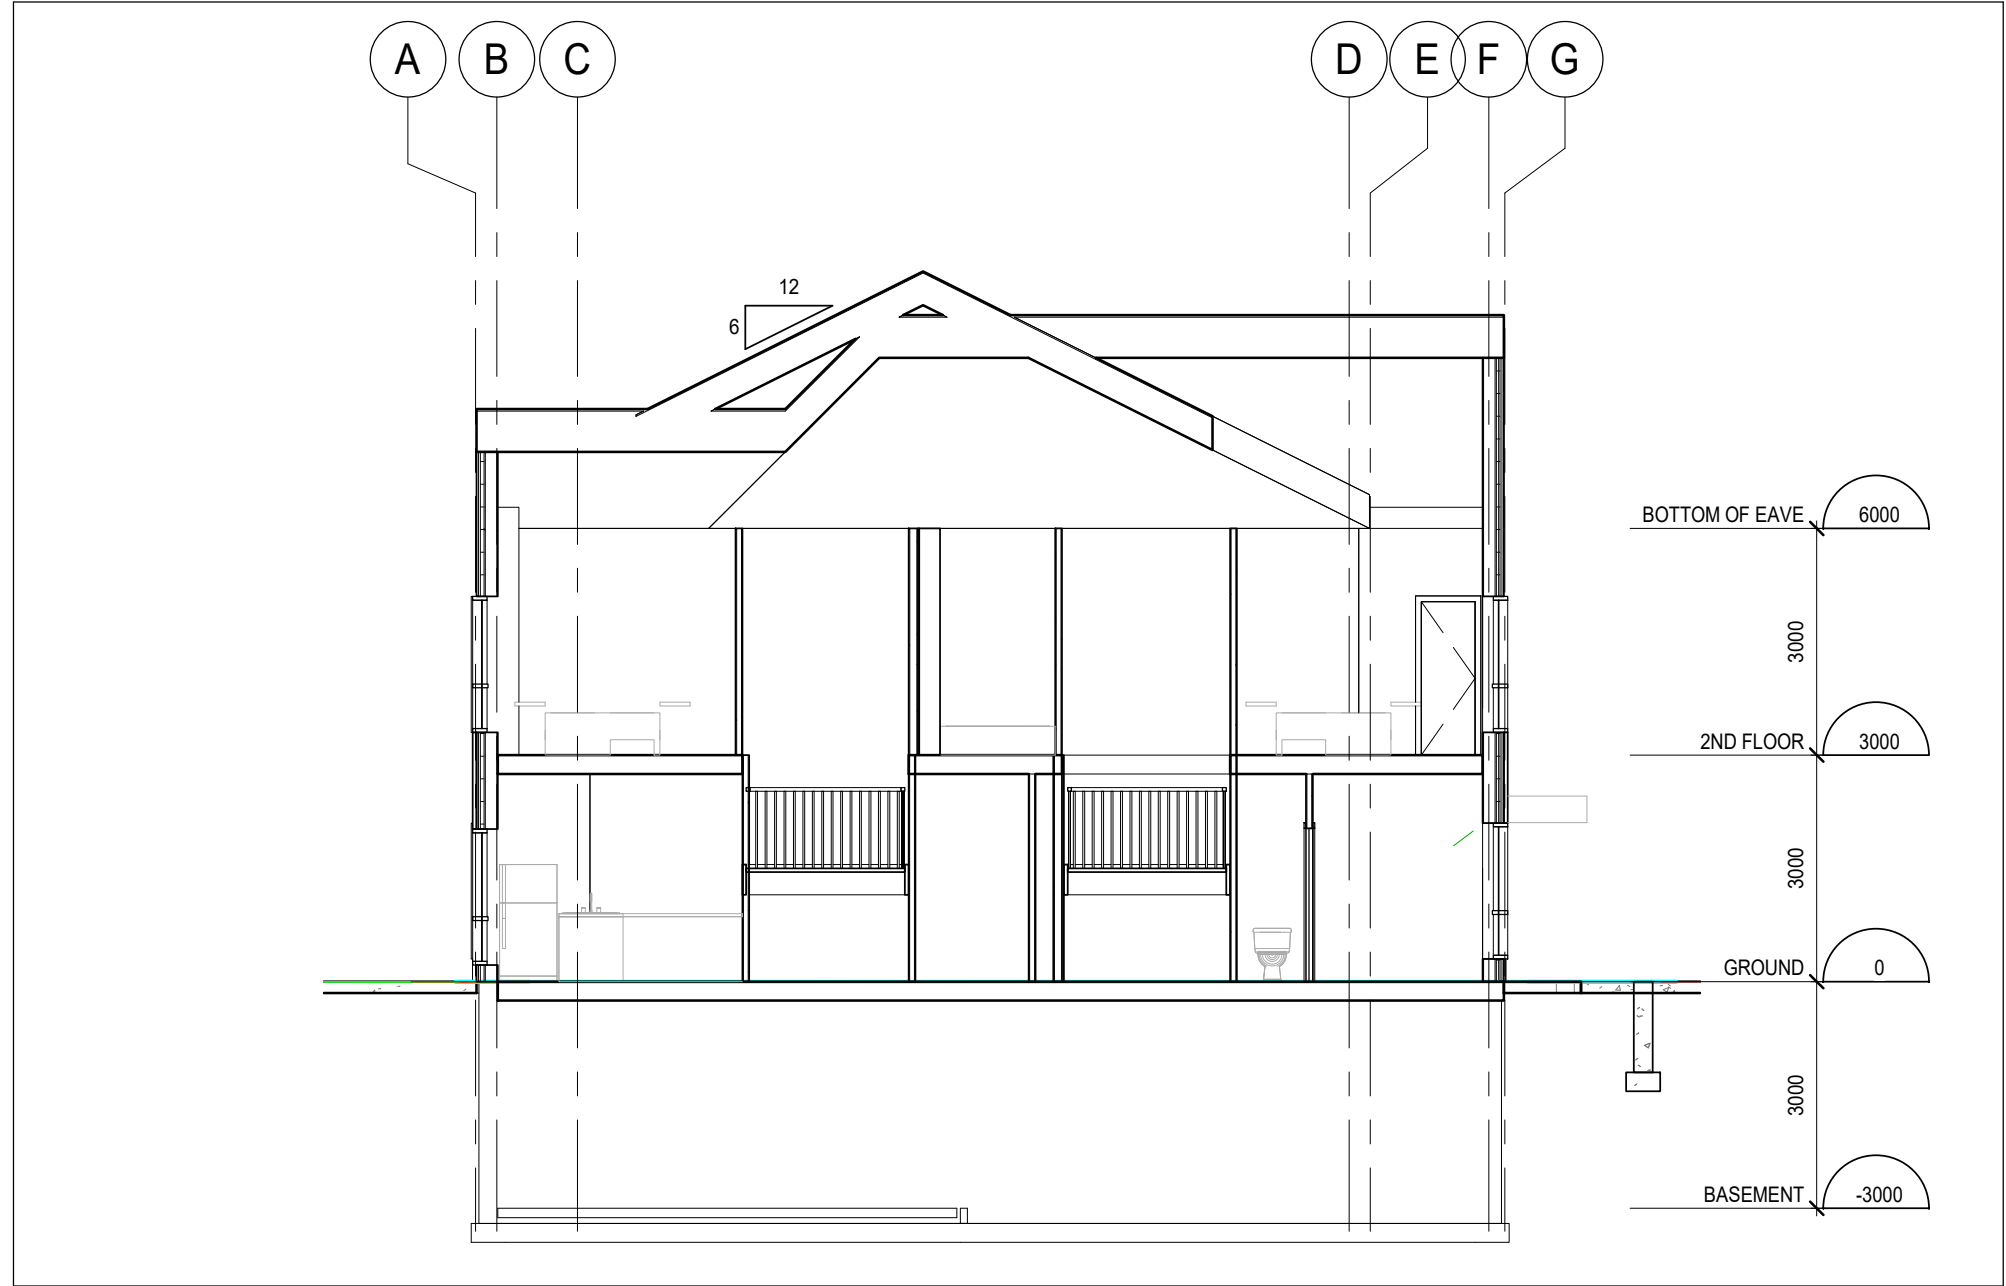

6 BUILDING SECTION
A301 1:100




3 BUILDING SECTION
A301 1:100

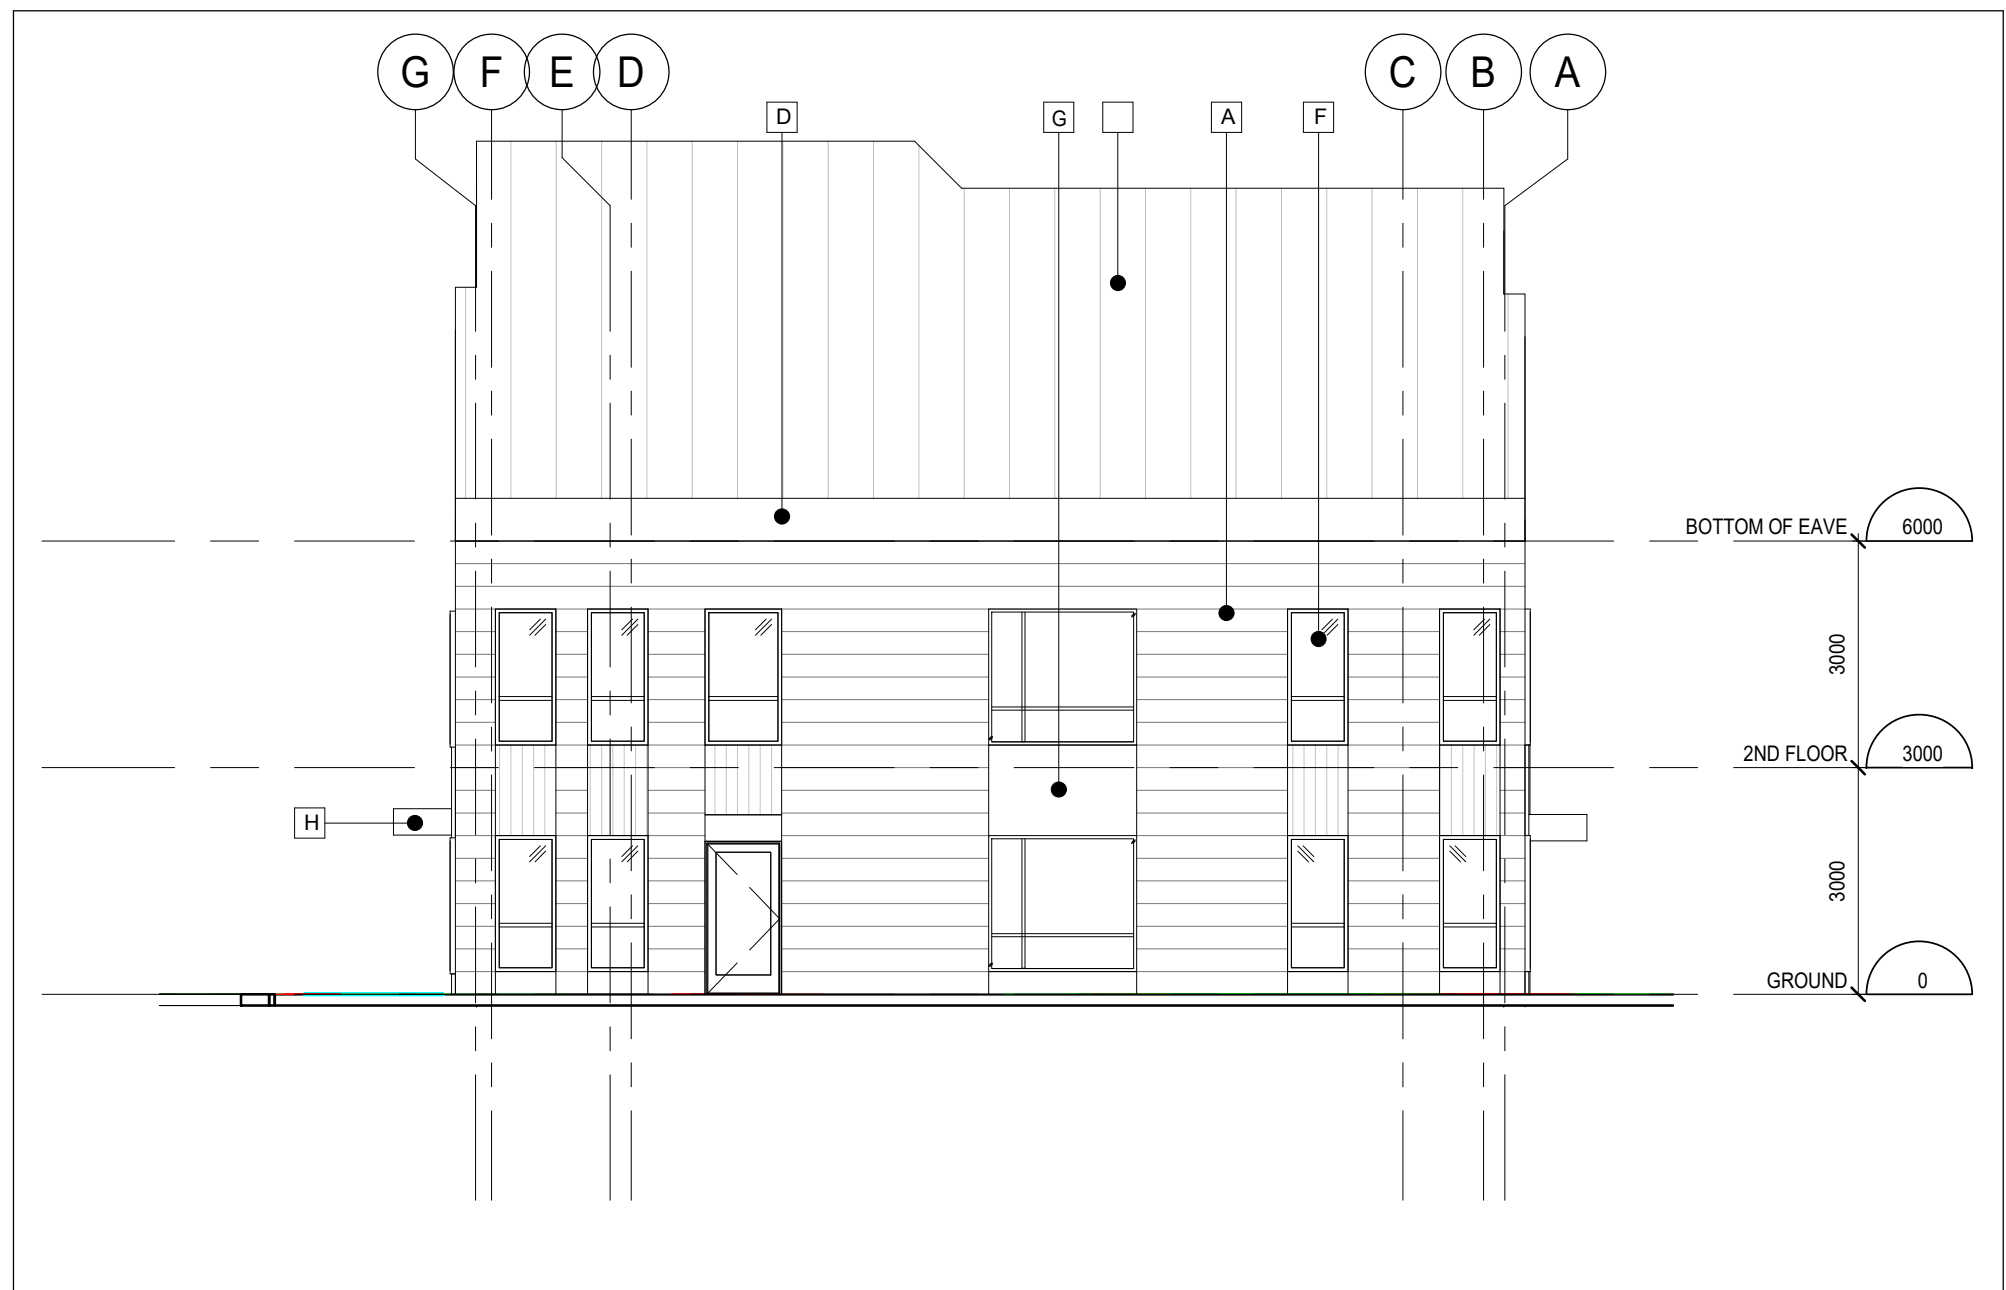

5 EAST ELEVATION
A301 1:100



2 SOUTH ELEVATION
A301 1:100

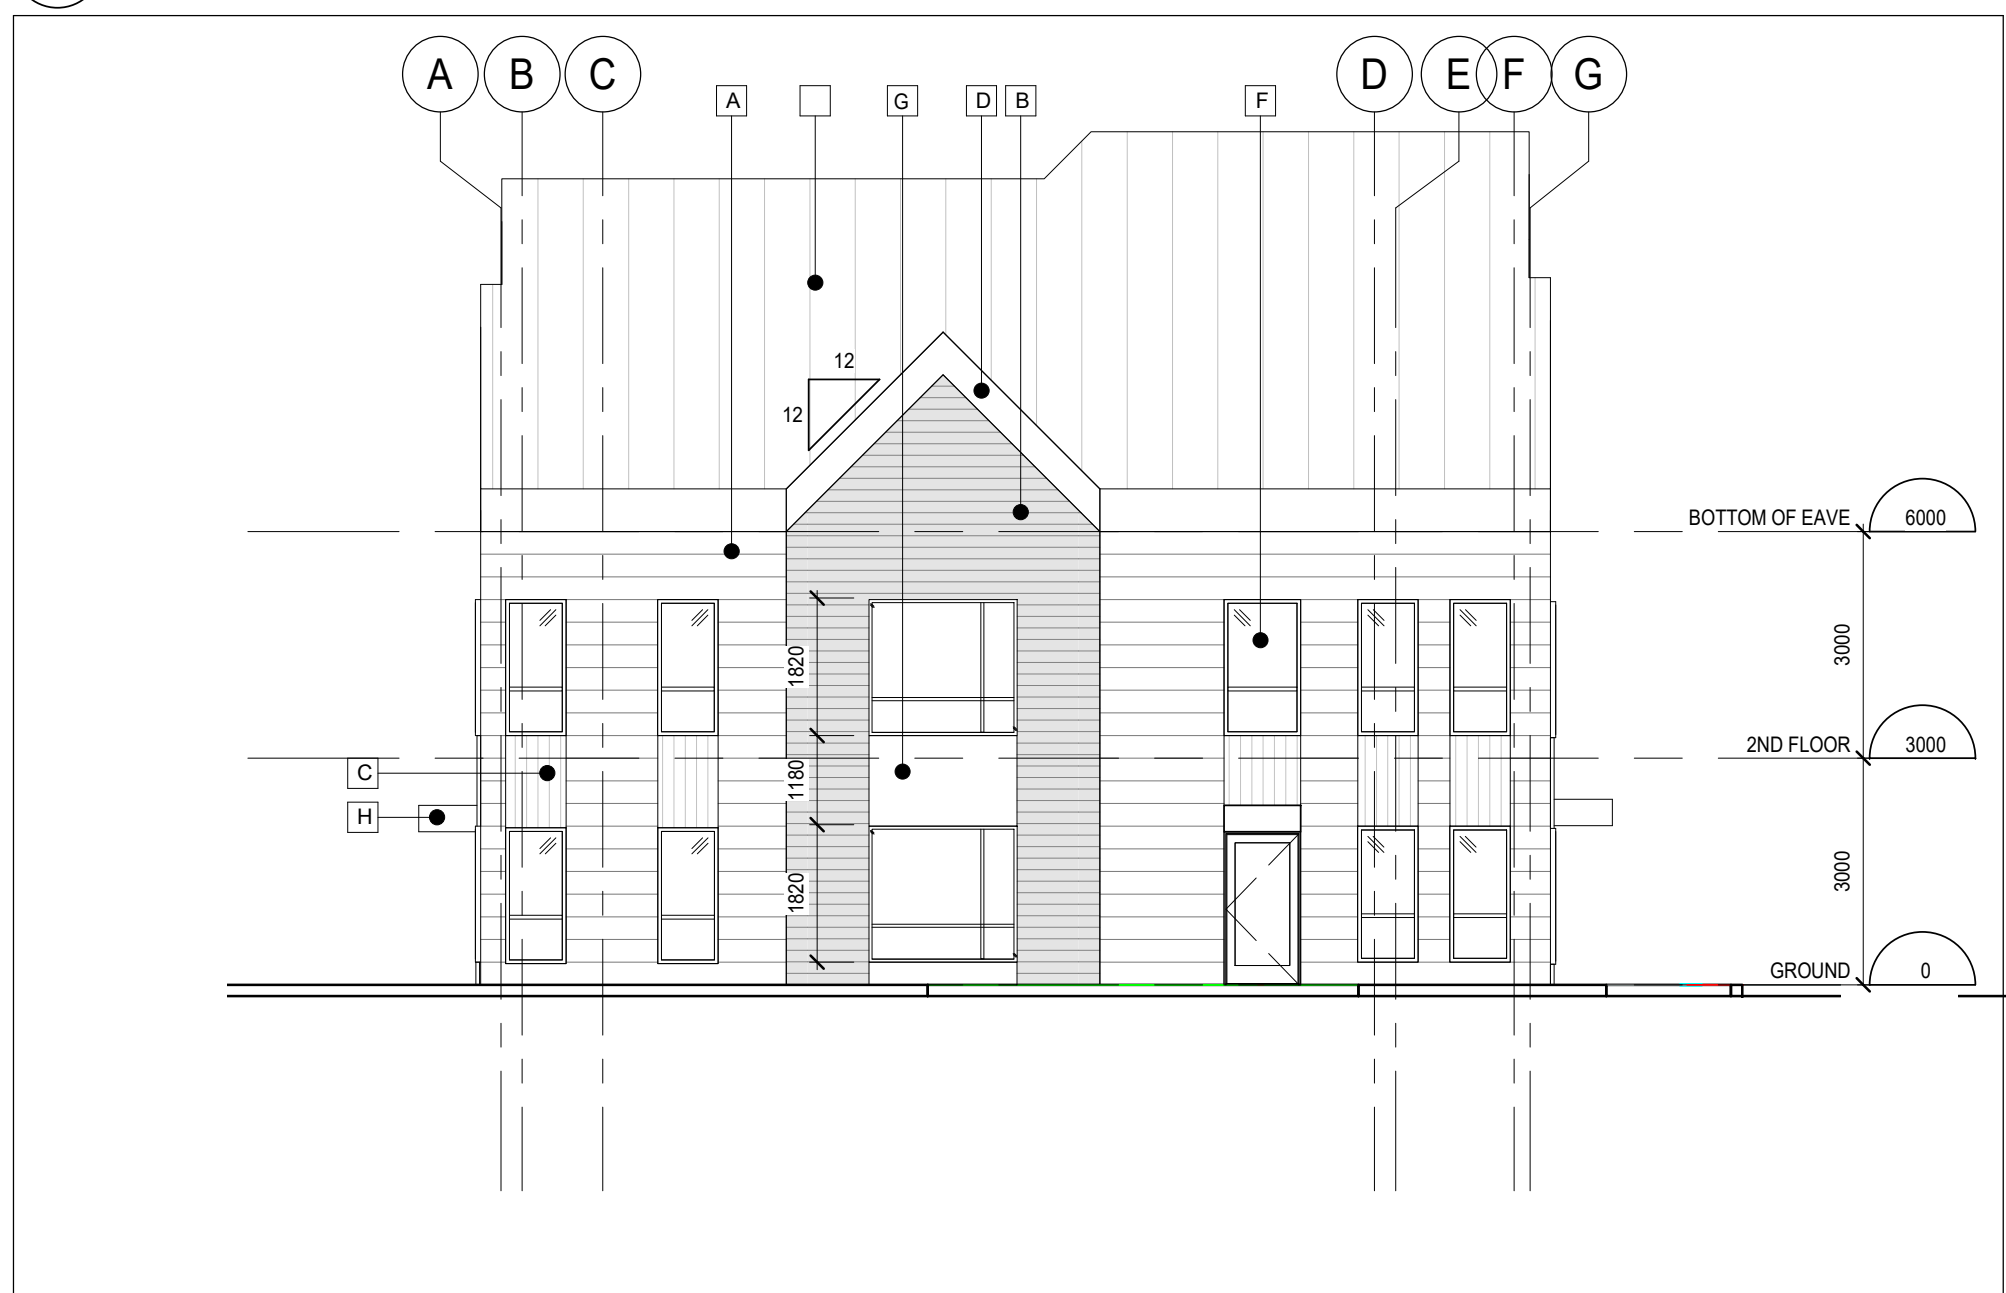

4 WEST ELEVATION
A301 1:100



1 NORTH ELEVATION
A301 1:100

DO NOT SCALE THE DRAWINGS
CHECK AND VERIFY ALL DIMENSIONS AT THE SITE.
ALL DRAWINGS, SPECIFICATIONS AND RELATED DOCUMENTS ARE THE
COPYRIGHT PROPERTY OF THE CONSULTANT AND MUST BE RETURNED
UPON REQUEST. REPRODUCTION OF DRAWINGS IN PART OR WHOLE
WITHOUT THE PERMISSION OF THE CONSULTANT IS FORBIDDEN.
DRAWINGS ARE NOT TO BE USED FOR CONSTRUCTION UNTIL SIGNED
AND SEALED BY THE CONSULTANT.

NO.	ISSUES	DATE	BY
1	ISSUED FOR REZONING	20/06/30	BBA
2	ISSUED FOR SPA	20/12/07	BBA

MATERIAL LEGEND:

- A - HARDBOARD SIDING (WHITE)
- B - HARDBOARD SIDING (GREY/BLUE)
- C - ALUMINUM SIDING
- D - PREFIN. METAL FACIA
- E - METAL ROOF
- F - GLAZING
- G - SPANDREL PANEL
- H - ALUMINUM BOARD CANOPY

NO.	REVISIONS	DATE	BY

PROJECT:
**ELGIN PARK
REDEVELOPMENT
PROJECT**

265 - 327 ELGIN STREET
COBOURG, ONTARIO
NORTHUMBERLAND COUNTY

DRAWING:
**BUILDING 1 ELEVATIONS
& SECTIONS**



BARRY BRYAN
ASSOCIATES


Architects
Engineers
Project Managers

201-250 Water Street
Whitby Ontario L1N 0G5
Tel: (905) 666-5252
Fax: (905) 666-5256
e-mail: bba@bba-archeng.com

DESIGN BY:	DOC CONTROL:
BBA	DATE:
DRAWN BY:	% COMPLETE:
NV	
CHECKED BY:	INITIAL:
NS	

DATE:	SCALE:
11/02/20	As indicated
FILE:	


PROJECT NO:	DRAWING NO:
19284	A301

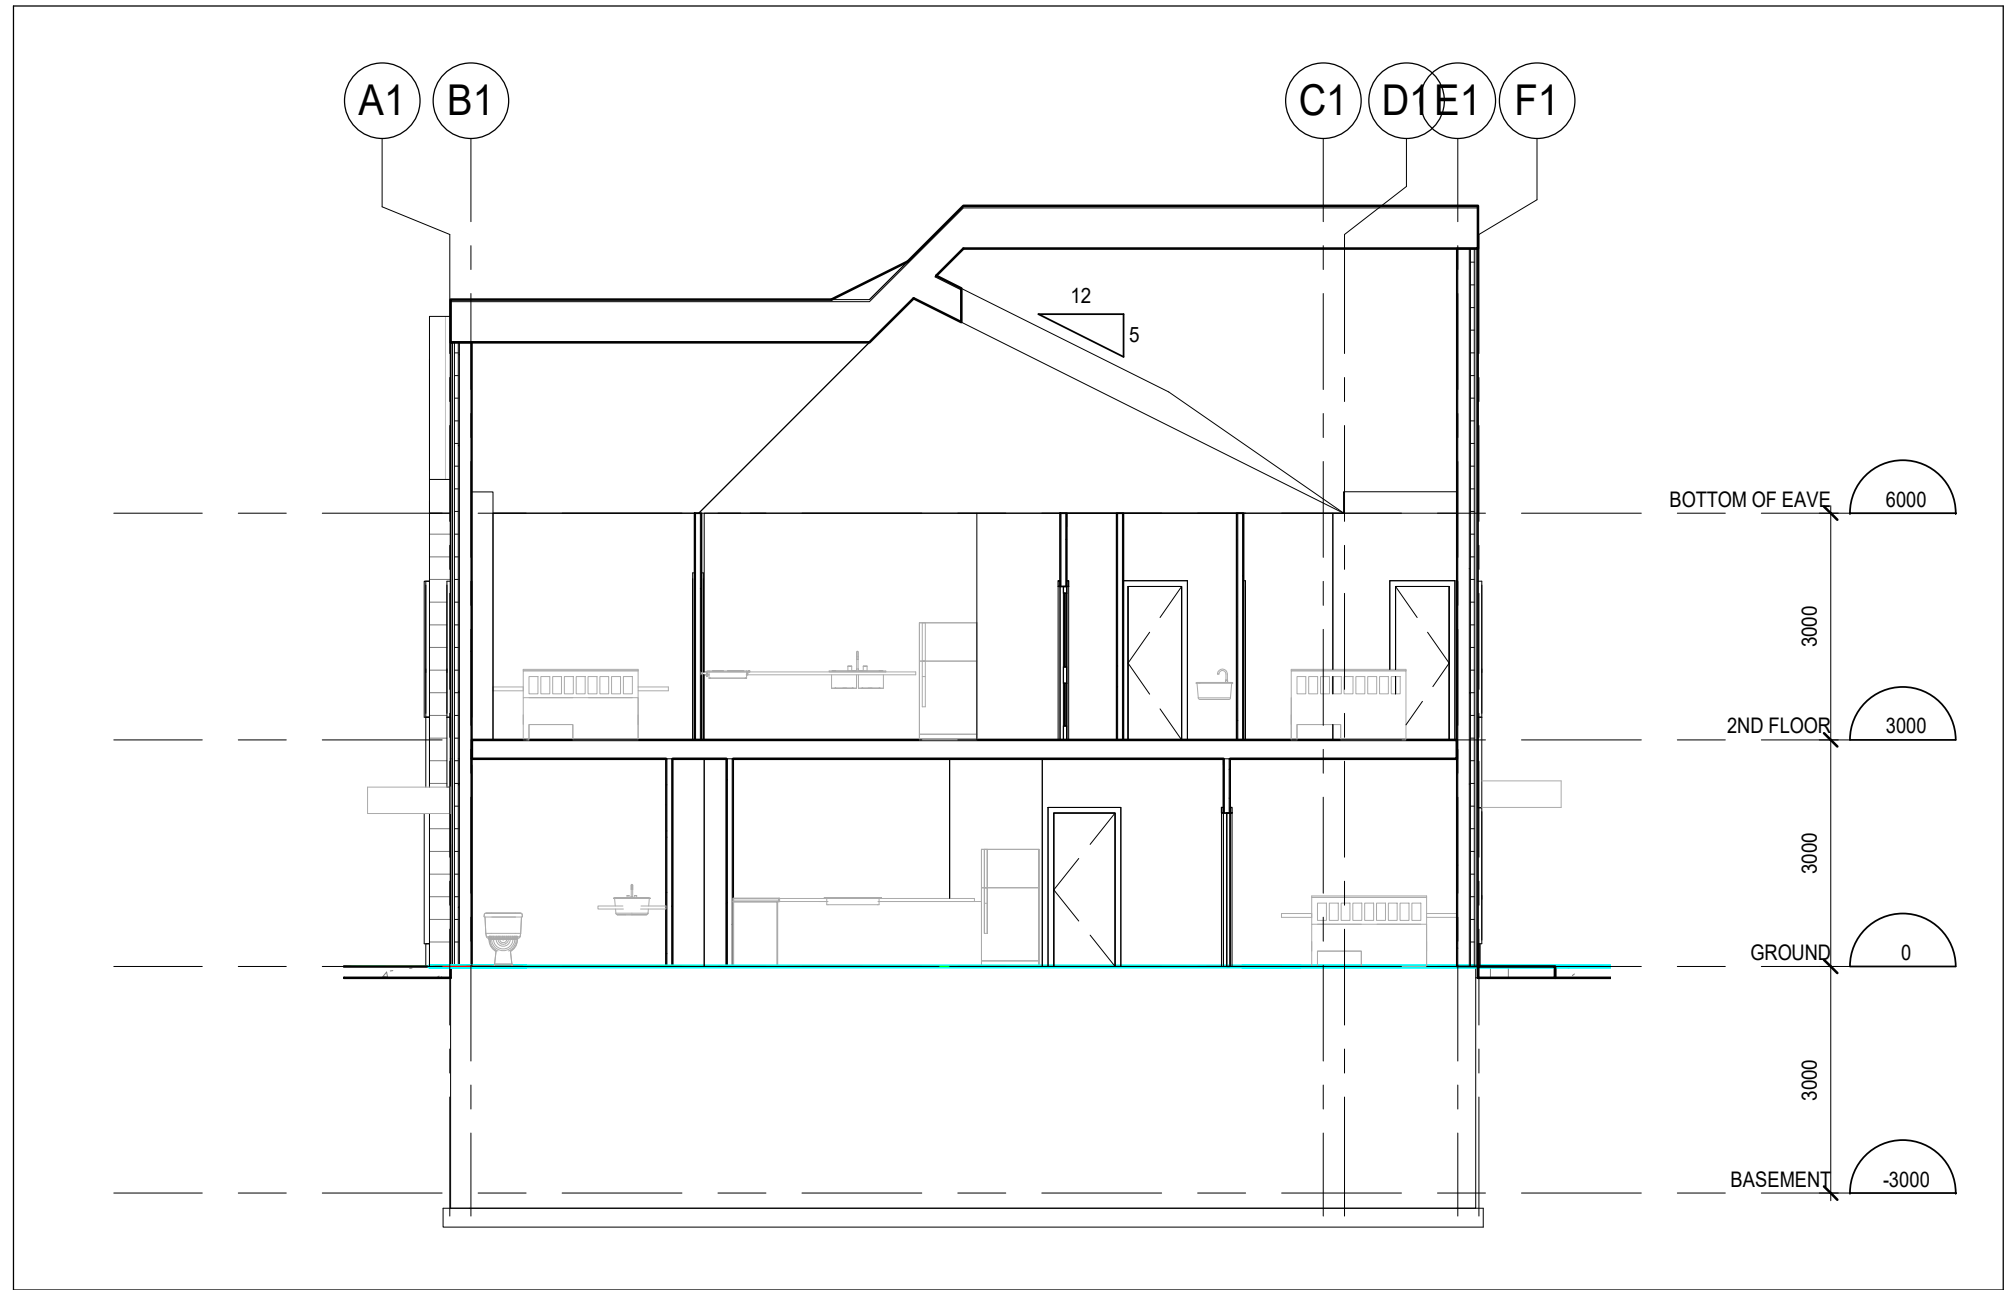

6 BUILDING SECTION
A302 1:100




3 BUILDING SECTION
A302 1:100

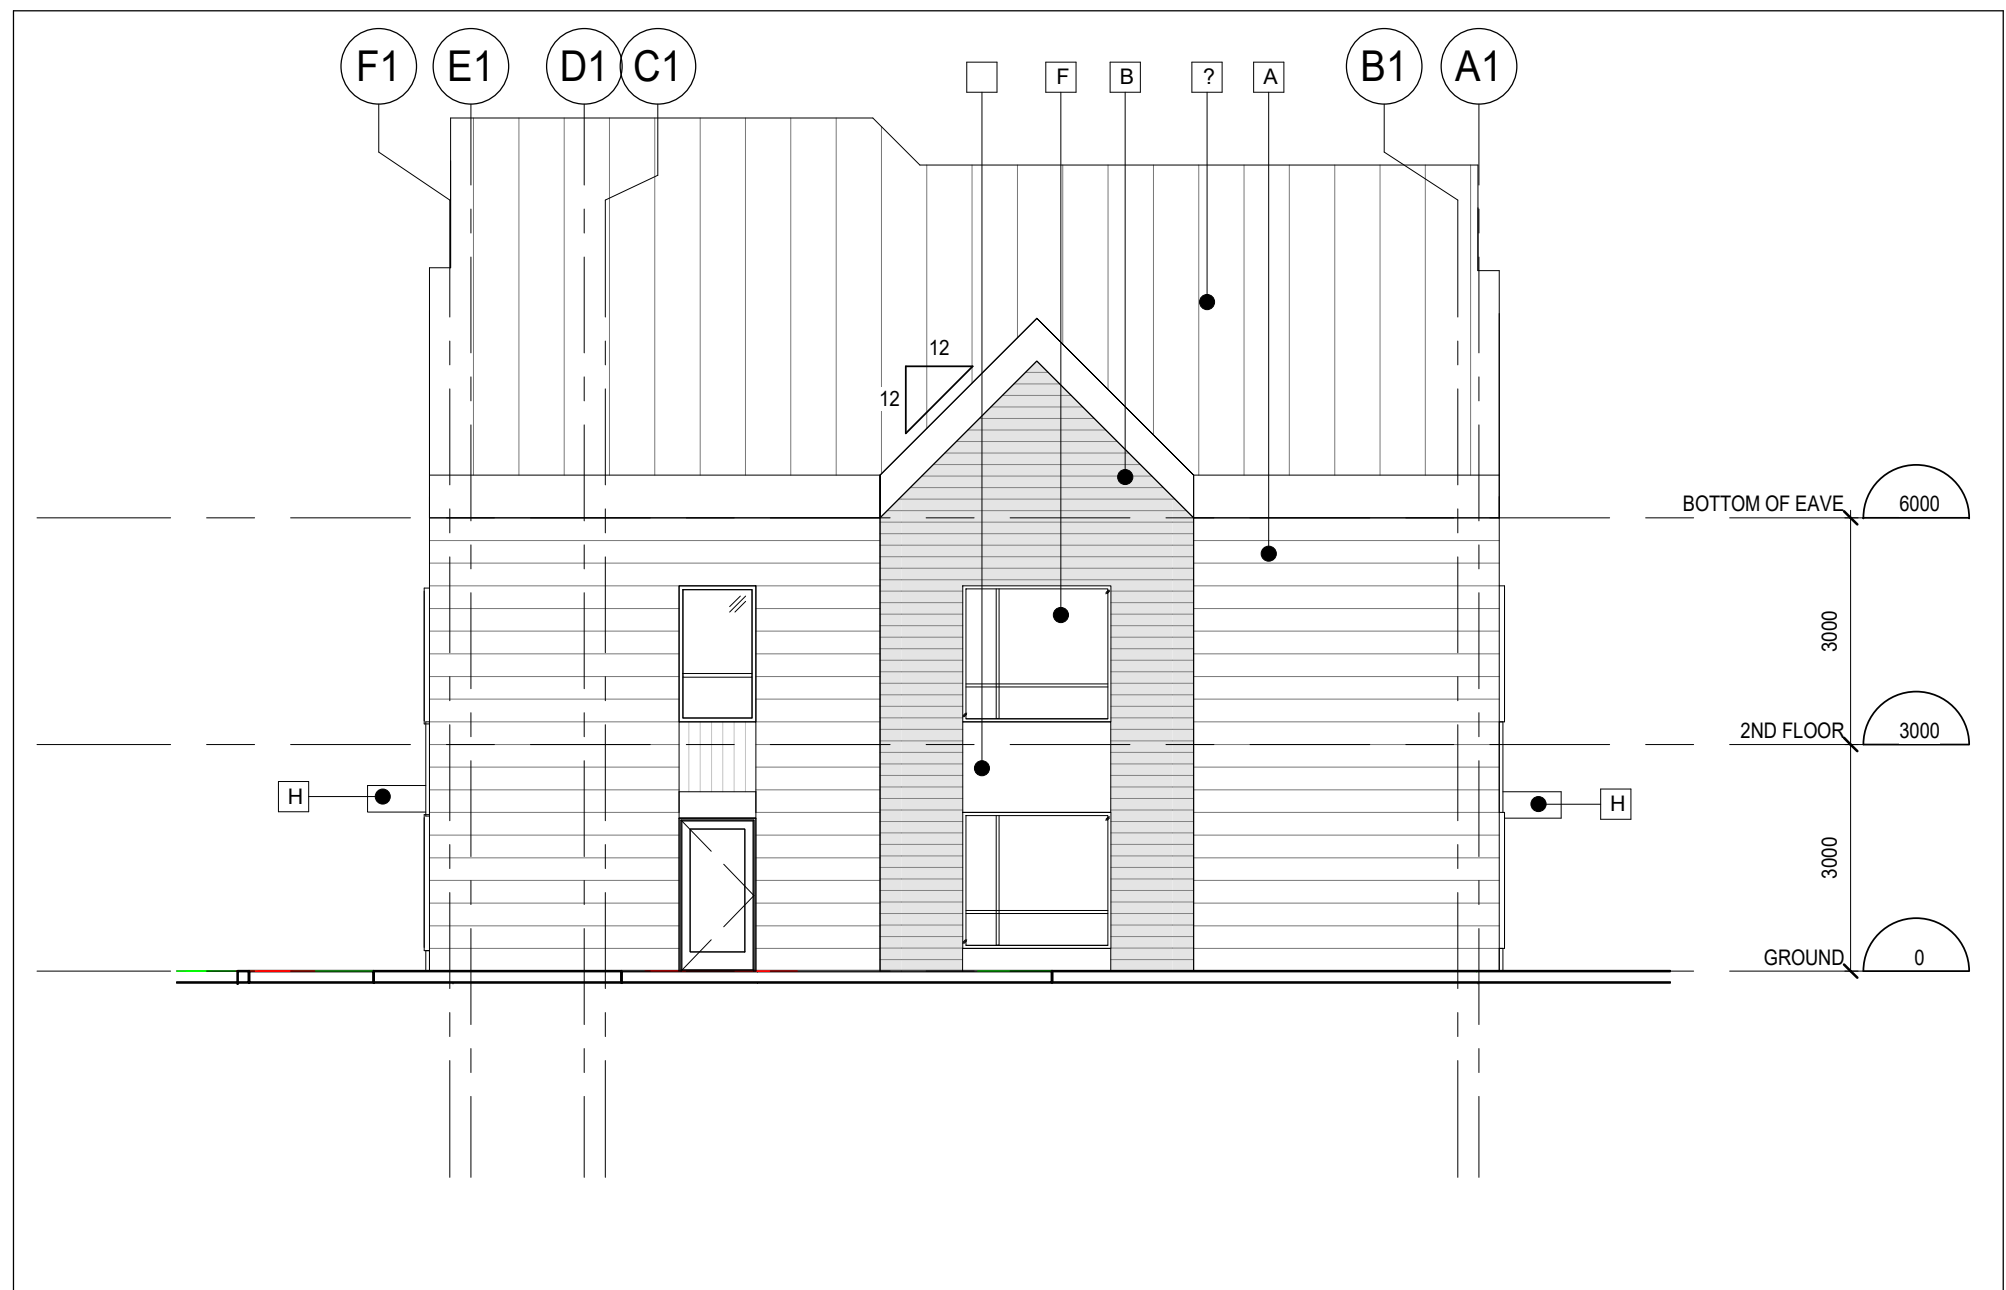

5 EAST ELEVATION
A302 1:100



2 SOUTH ELEVATION
A302 1:100

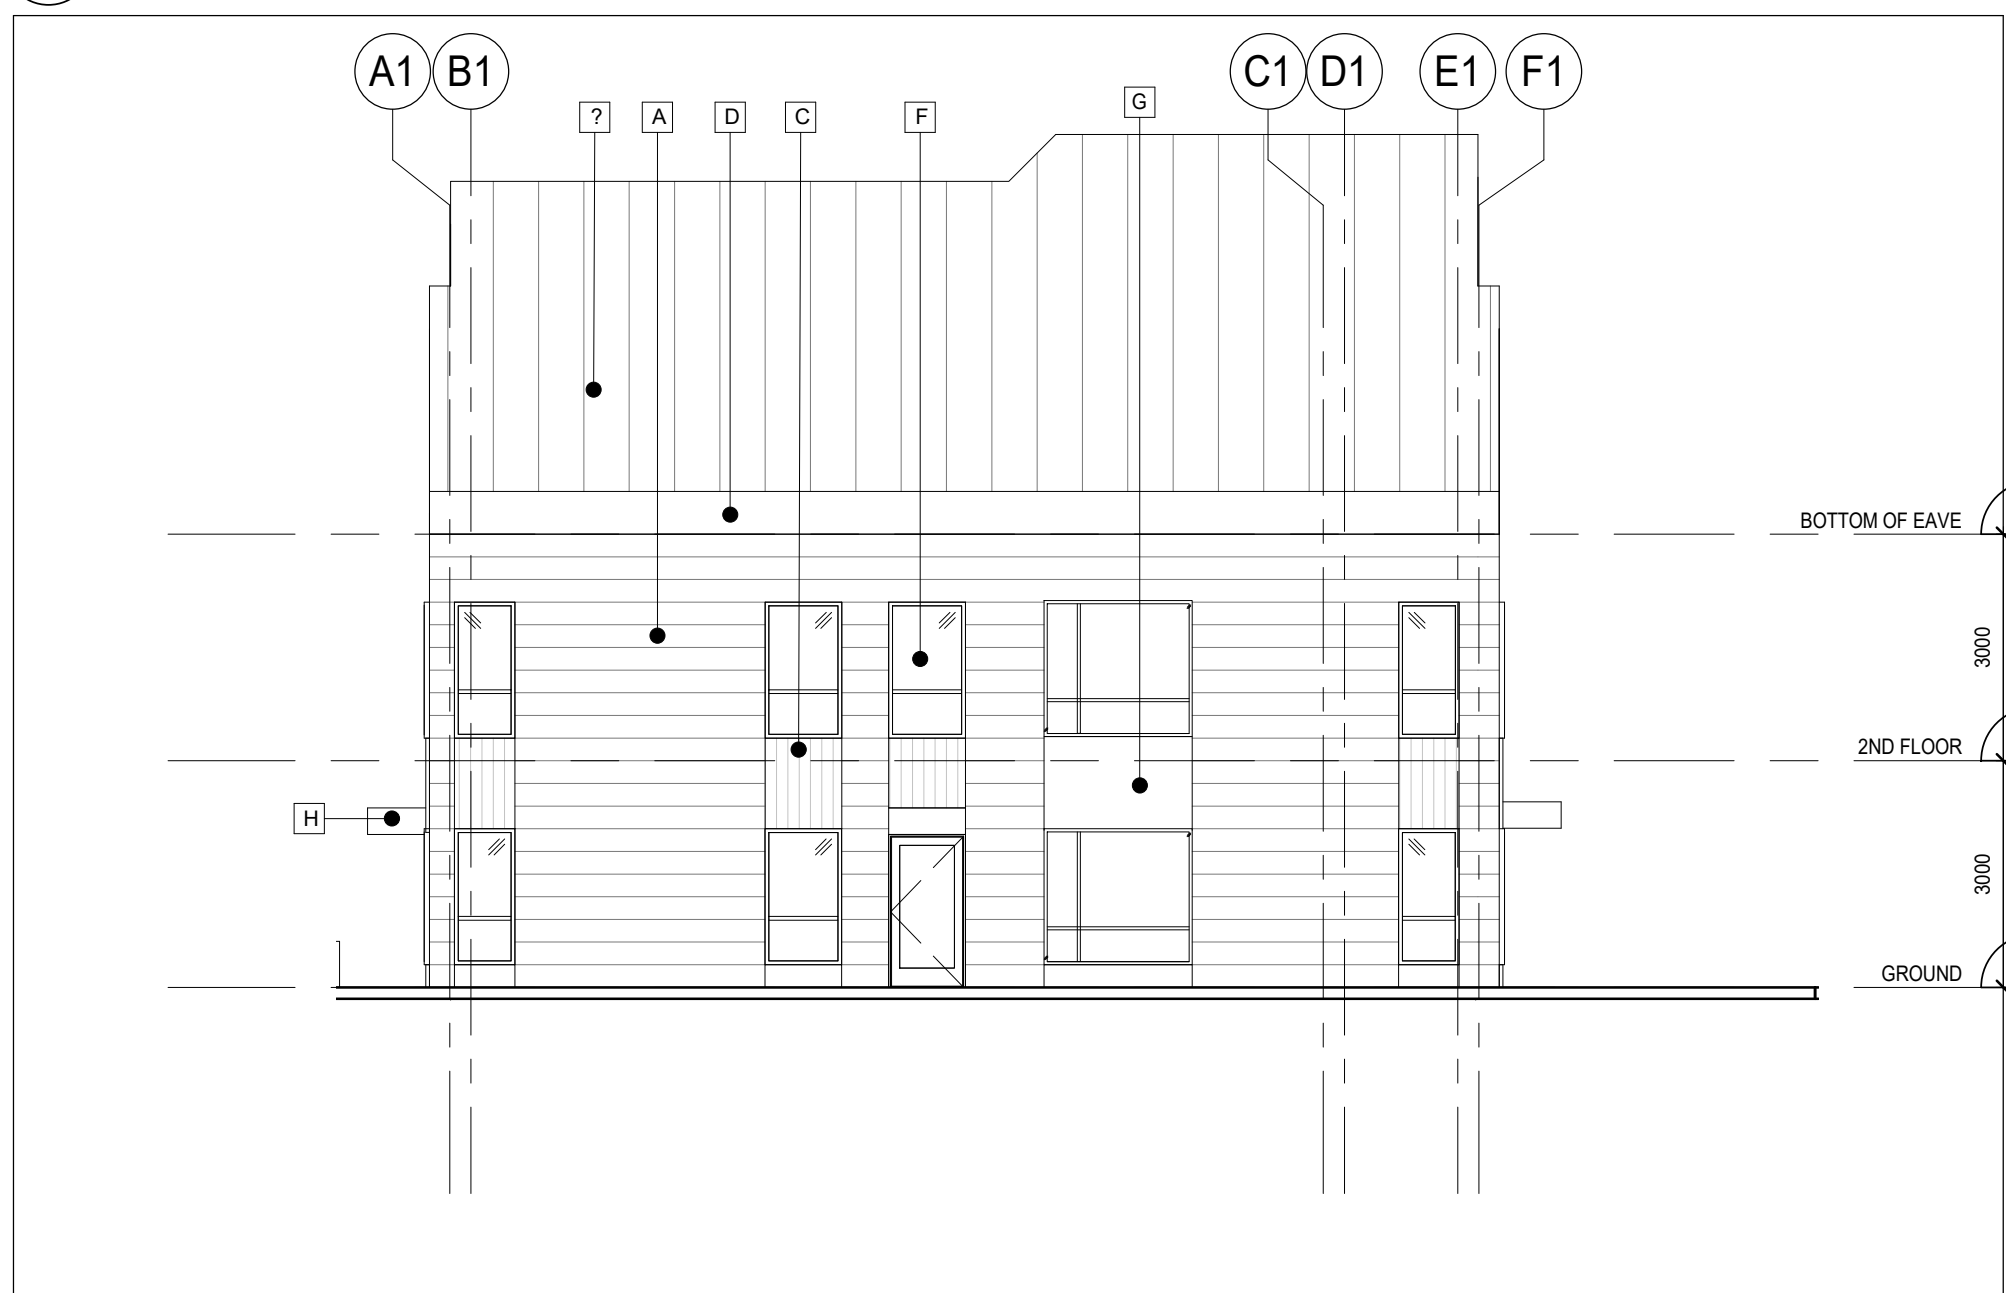

4 WEST ELEVATION
A302 1:100



1 NORTH ELEVATION
A302 1:100

DO NOT SCALE THE DRAWINGS
CHECK AND VERIFY ALL DIMENSIONS AT THE SITE.
ALL DRAWINGS, SPECIFICATIONS AND RELATED DOCUMENTS ARE THE
COPYRIGHT PROPERTY OF THE CONSULTANT AND MUST BE RETURNED
UPON REQUEST. REPRODUCTION OF DRAWINGS IN PART OR WHOLE
WITHOUT THE PERMISSION OF THE CONSULTANT IS FORBIDDEN.
DRAWINGS ARE NOT TO BE USED FOR CONSTRUCTION UNTIL SIGNED
AND SEALED BY THE CONSULTANT.

NO.	ISSUES	DATE	BY
1	ISSUED FOR REZONING	20/06/30	BBA
2	ISSUED FOR SPA	20/12/07	BBA

MATERIAL LEGEND:

- A - HARDBOARD SIDING (WHITE)
- B - HARDBOARD SIDING (GREY/BLUE)
- C - ALUMINUM SIDING
- D - PREFIN. METAL FACIA
- E - METAL ROOF
- F - GLAZING
- G - SPANDREL PANEL
- H - ALUMINUM BOARD CANOPY

NO.	REVISIONS	DATE	BY

PROJECT:
**ELGIN PARK
REDEVELOPMENT
PROJECT**
265 - 327 ELGIN STREET
COBOURG, ONTARIO
NORTHUMBERLAND COUNTY

DRAWING:
**BUILDING 2 ELEVATIONS
& SECTIONS**



BARRY BRYAN
ASSOCIATES


Architects
Engineers
Project Managers

201-250 Water Street
Whitby Ontario L1N 0G5
Tel: (905) 666-5252
Fax: (905) 666-5256
e-mail: bba@bba-archeng.com


DESIGN BY: BBA	DOC. CONTROL: DATE
DRAWN BY: NV	% COMPLETE:
CHECKED BY: NS	INITIAL:

DATE: 11/02/20
SCALE: As indicated
FILE:


PROJECT NO: 19284	DRAWING NO: A302
-----------------------------	----------------------------

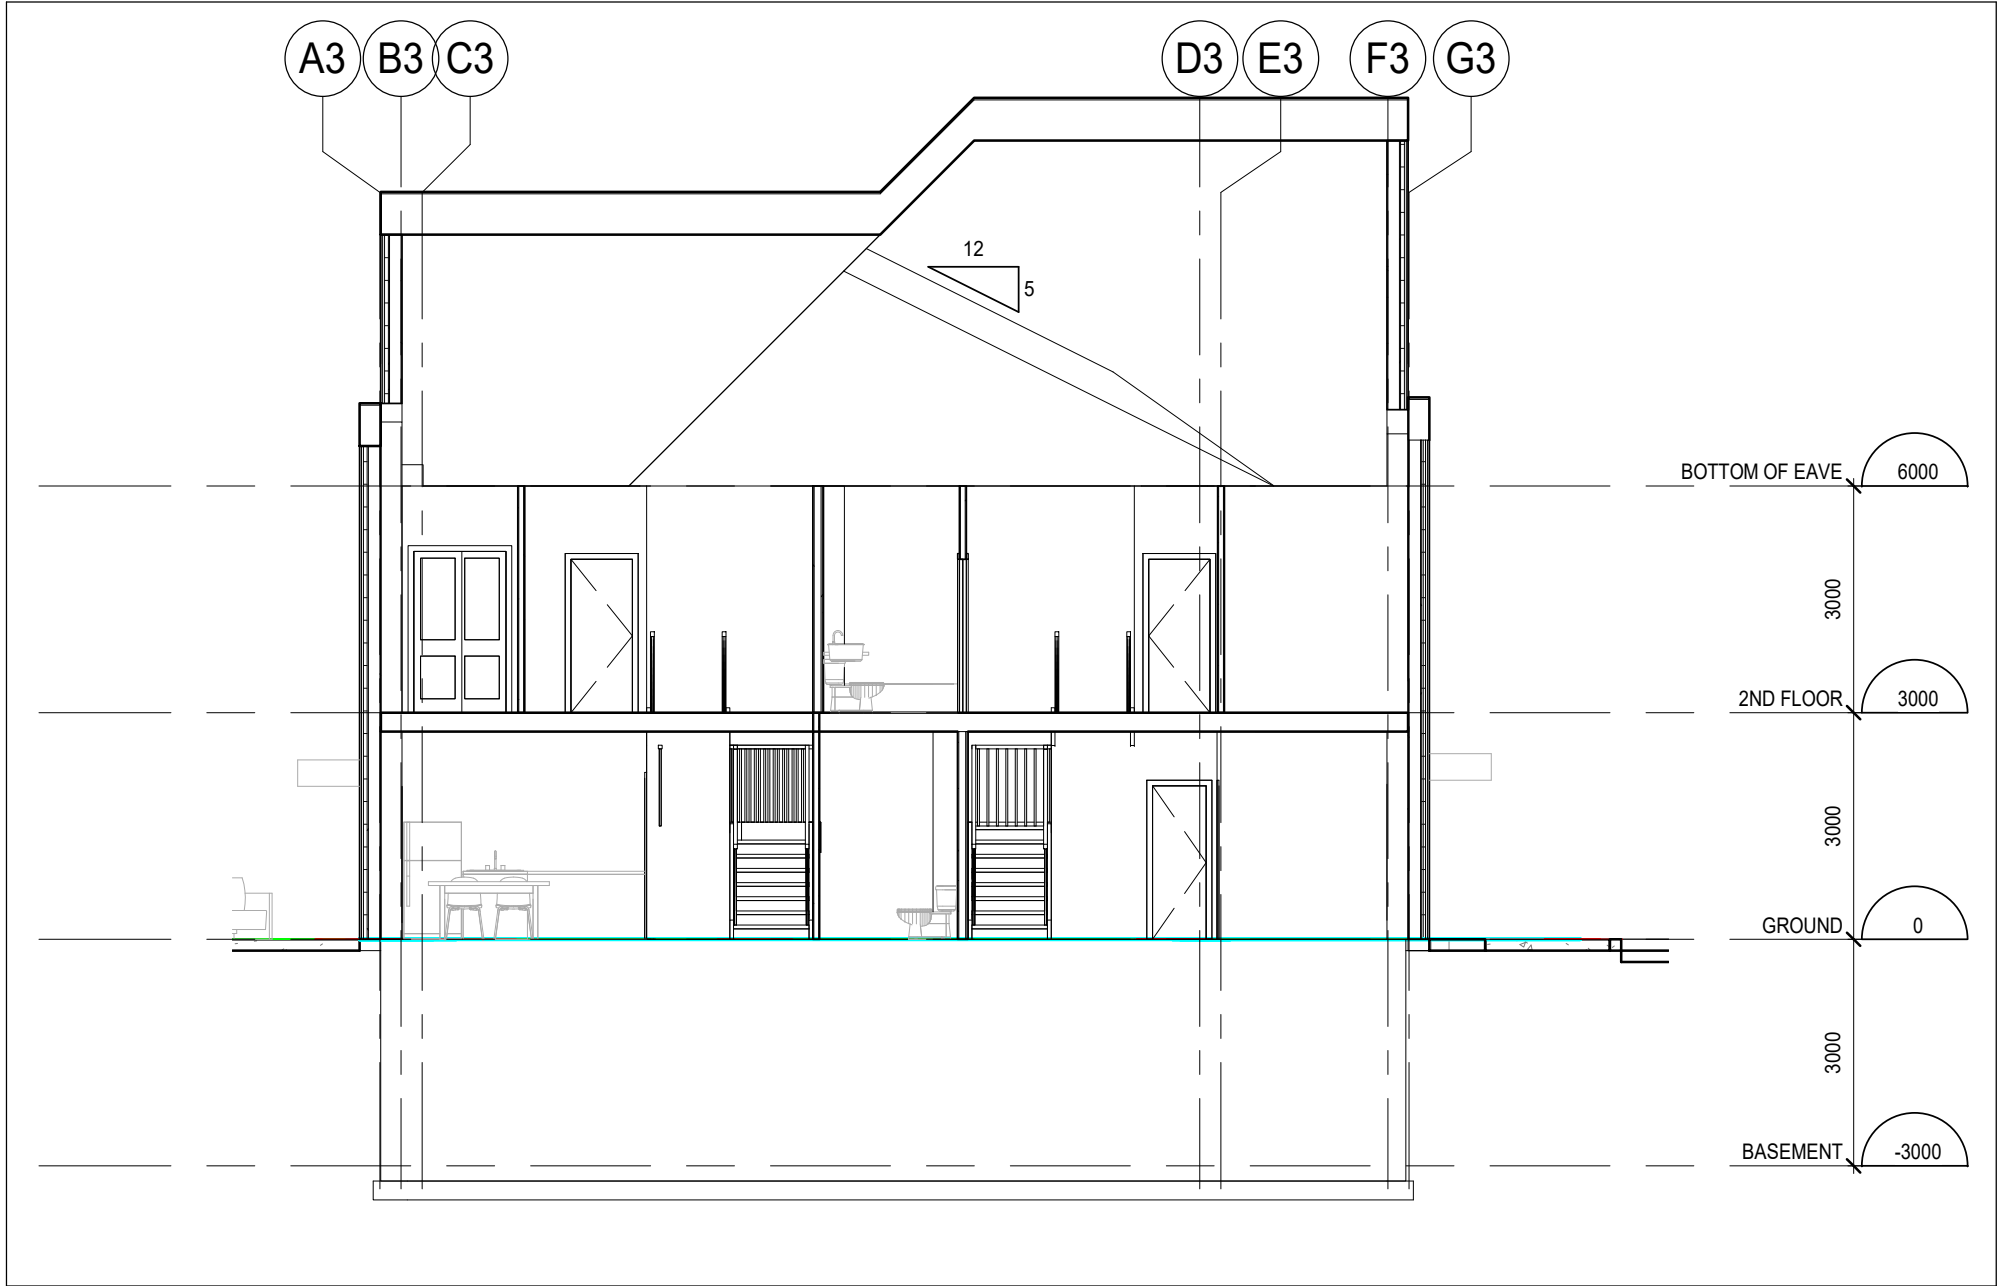

6 BUILDING SECTION
A303 1:100

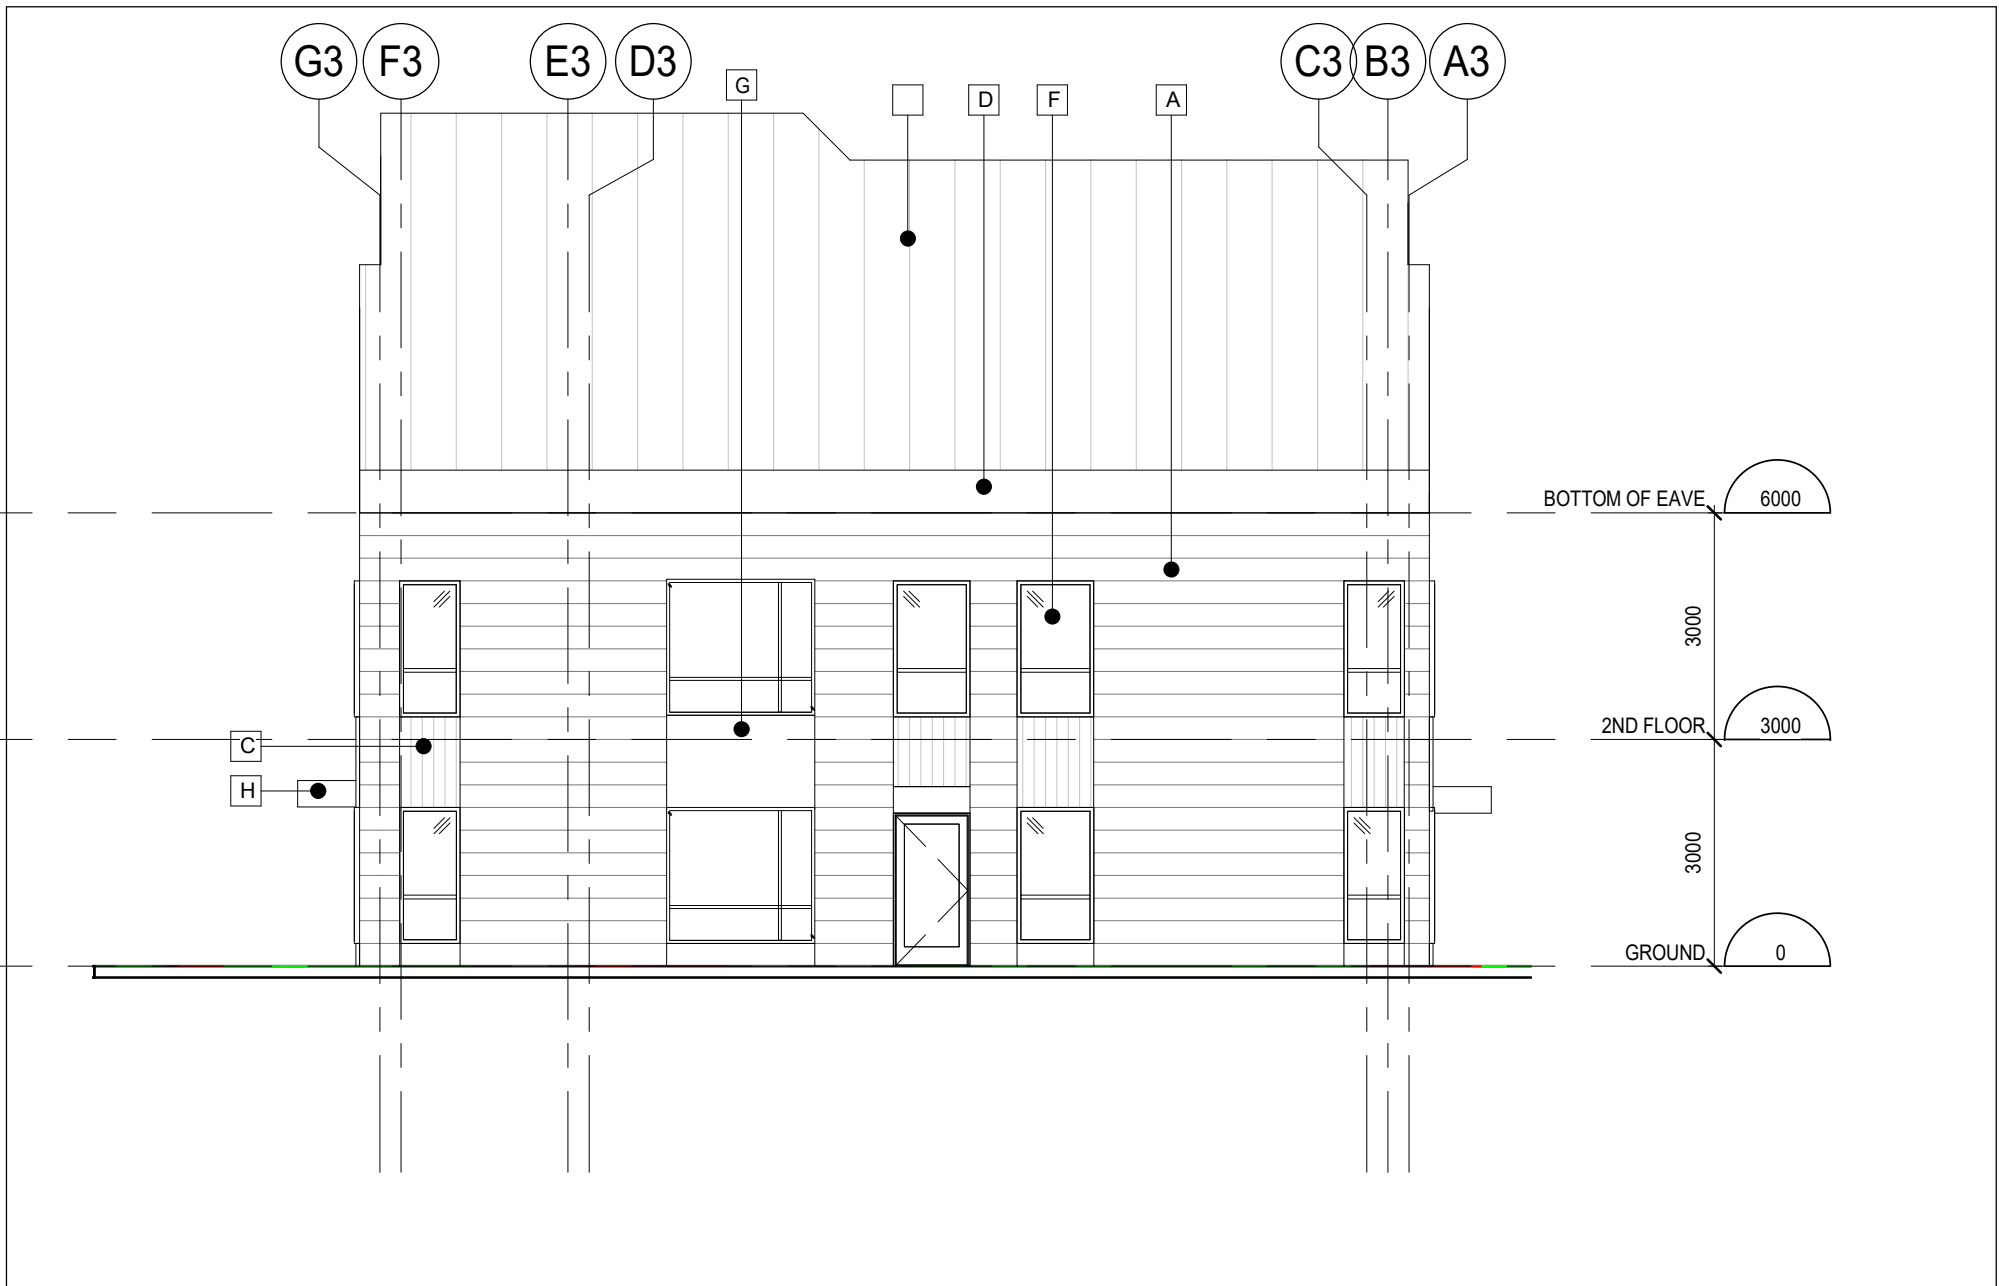

5 EAST ELEVATION
A303 1:100

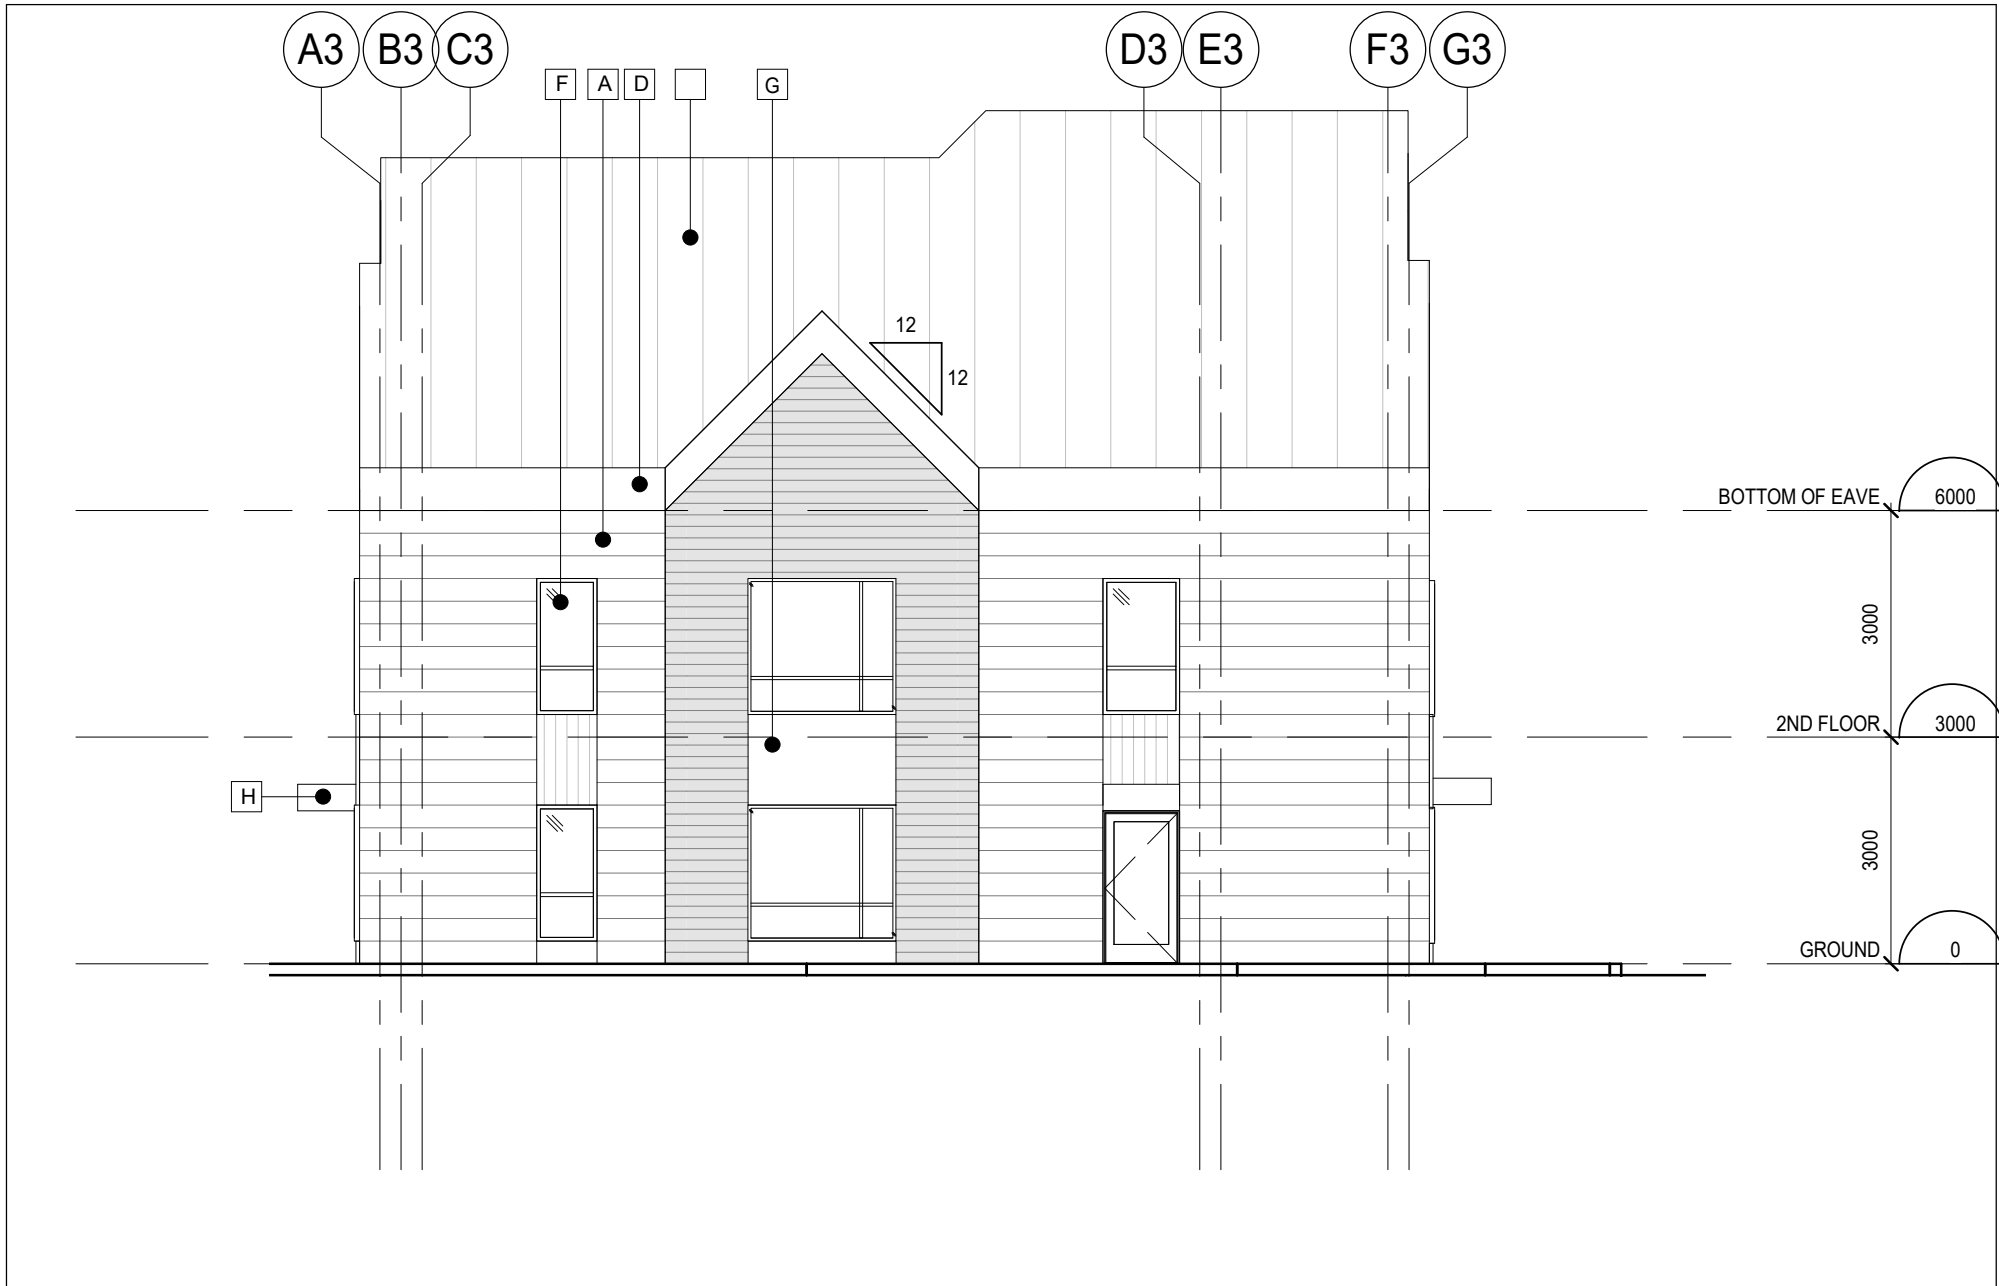

4 WEST ELEVATION
A303 1:100



3 BUILDING SECTION
A303 1:100



2 SOUTH ELEVATION
A303 1:100



1 NORTH ELEVATION
A303 1:100

DO NOT SCALE THE DRAWINGS
CHECK AND VERIFY ALL DIMENSIONS AT THE SITE.
ALL DRAWINGS, SPECIFICATIONS AND RELATED DOCUMENTS ARE THE
COPYRIGHT PROPERTY OF THE CONSULTANT AND MUST BE RETURNED
UPON REQUEST. REPRODUCTION OF DRAWINGS IN PART OR WHOLE
WITHOUT THE PERMISSION OF THE CONSULTANT IS FORBIDDEN.
DRAWINGS ARE NOT TO BE USED FOR CONSTRUCTION UNTIL SIGNED
AND SEALED BY THE CONSULTANT.

NO.	ISSUES	DATE	BY
1	ISSUED FOR REZONING	20/06/30	BBA
2	ISSUED FOR SPA	20/12/07	BBA

MATERIAL LEGEND:

- A - HARDBOARD SIDING (WHITE)
- B - HARDBOARD SIDING (GREY/BLUE)
- C - ALUMINUM SIDING
- D - PREFIN. METAL FACIA
- E - METAL ROOF
- F - GLAZING
- G - SPANDREL PANEL
- H - ALUMINUM BOARD CANOPY

NO.	REVISIONS	DATE	BY
-----	-----------	------	----

PROJECT:

**ELGIN PARK
REDEVELOPMENT
PROJECT**

265 - 327 ELGIN STREET
COBOURG, ONTARIO
NORTHUMBERLAND COUNTY

DRAWING:

**BUILDING 3 ELEVATIONS
& SECTIONS**



**BARRY BRYAN
ASSOCIATES**

*Architects
Engineers
Project Managers*

201-250 Water Street
Whitby Ontario L1N 0G5
Tel: (905) 666-5252
Fax: (905) 666-5256
e-mail: bba@bba-archeng.com

DESIGN BY: BBA	DATE: 11/02/20
DRAWN BY: NV	SCALE: As indicated
CHECKED BY: NS	FILE:

% COMPLETE:	INITIAL:
-------------	----------

PROJECT NO:

19284

DRAWING NO:


A303



6 BUILDING SECTION
1:100




3 BUILDING SECTION
1:100

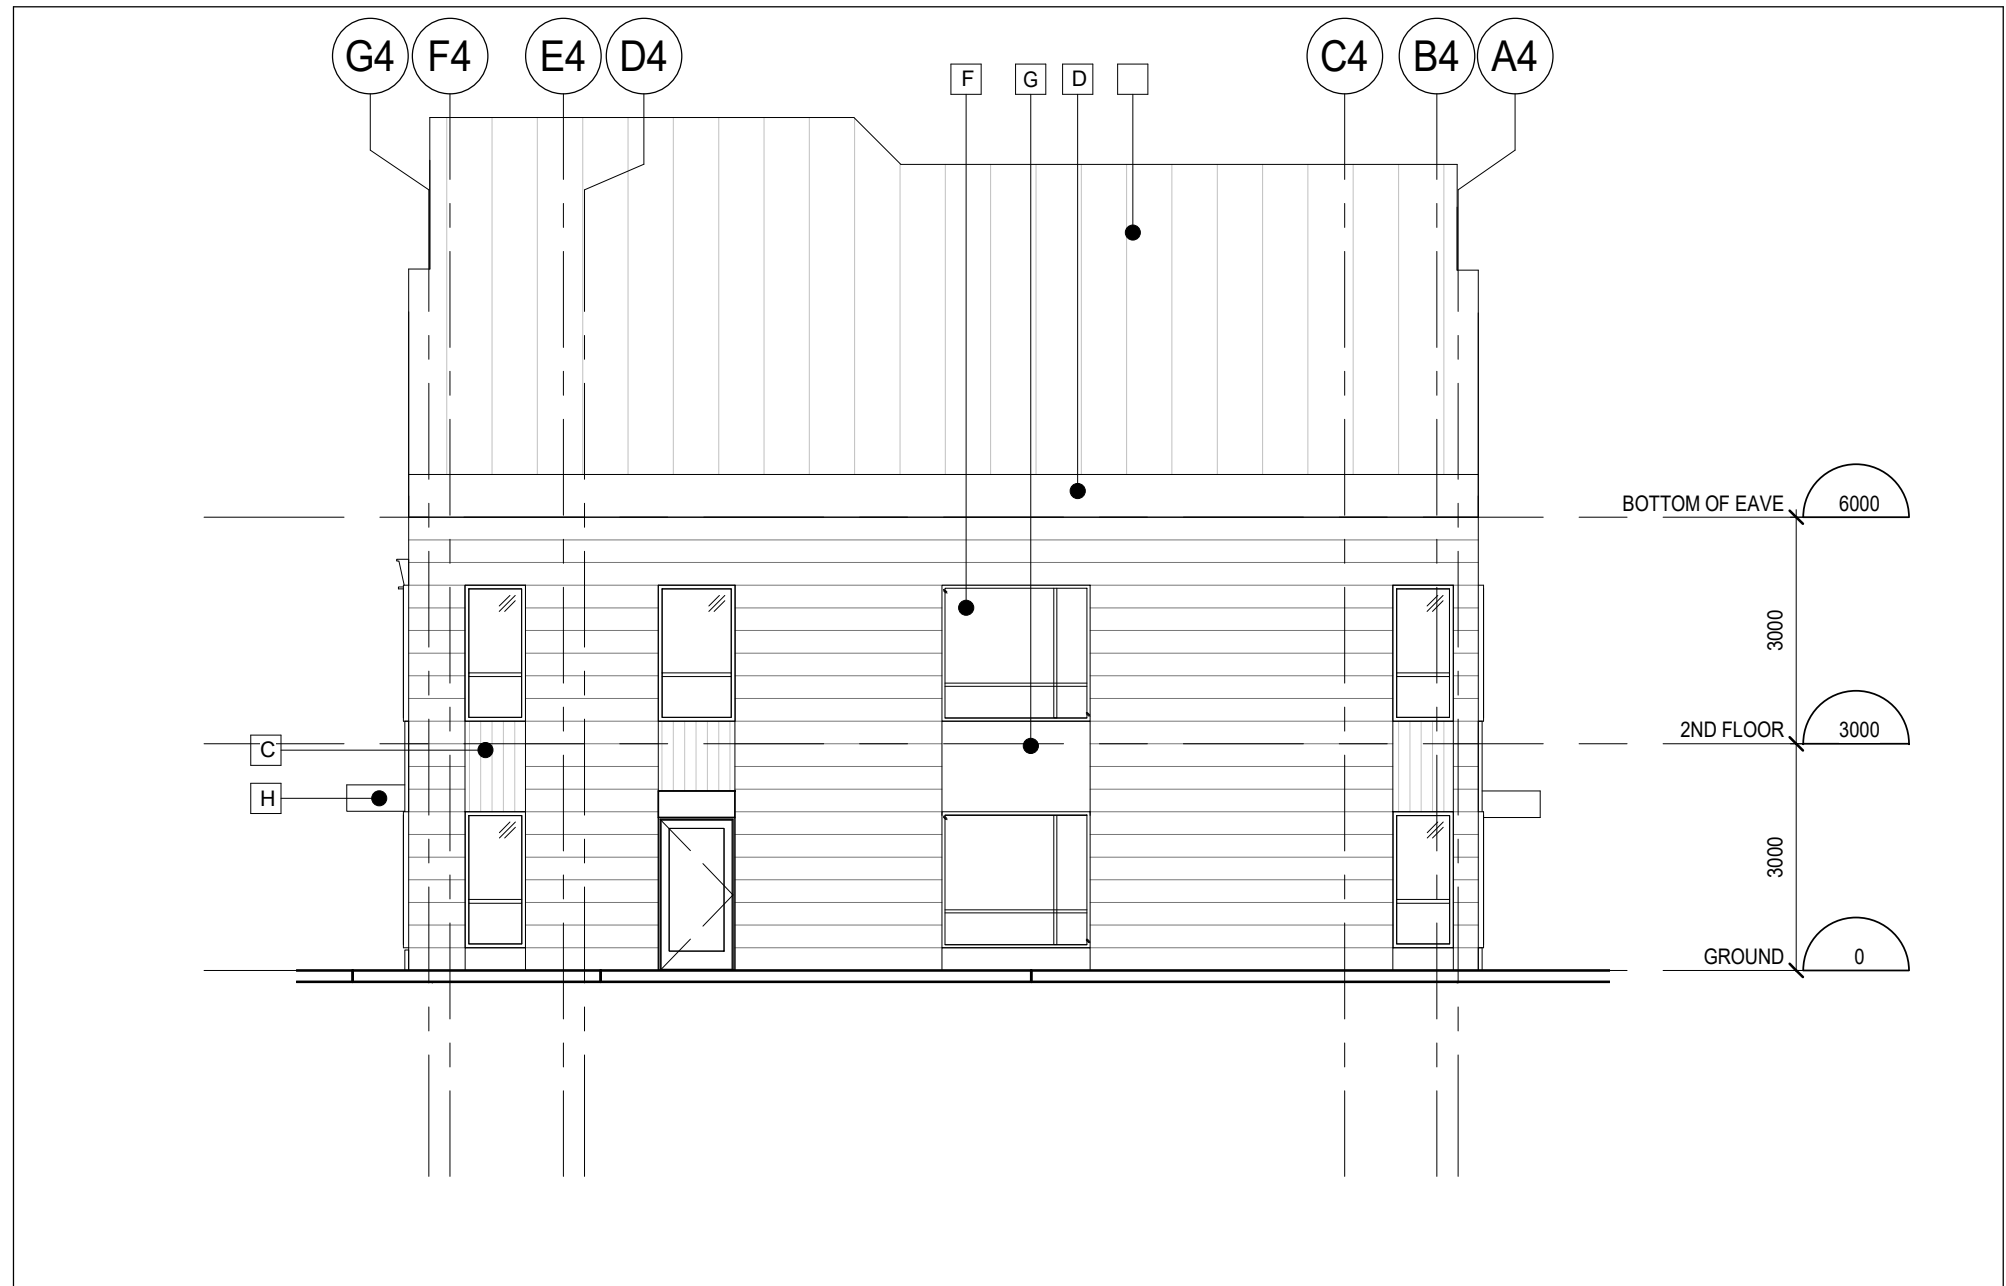

5 EAST ELEVATION
1:100



2 SOUTH ELEVATION
1:100

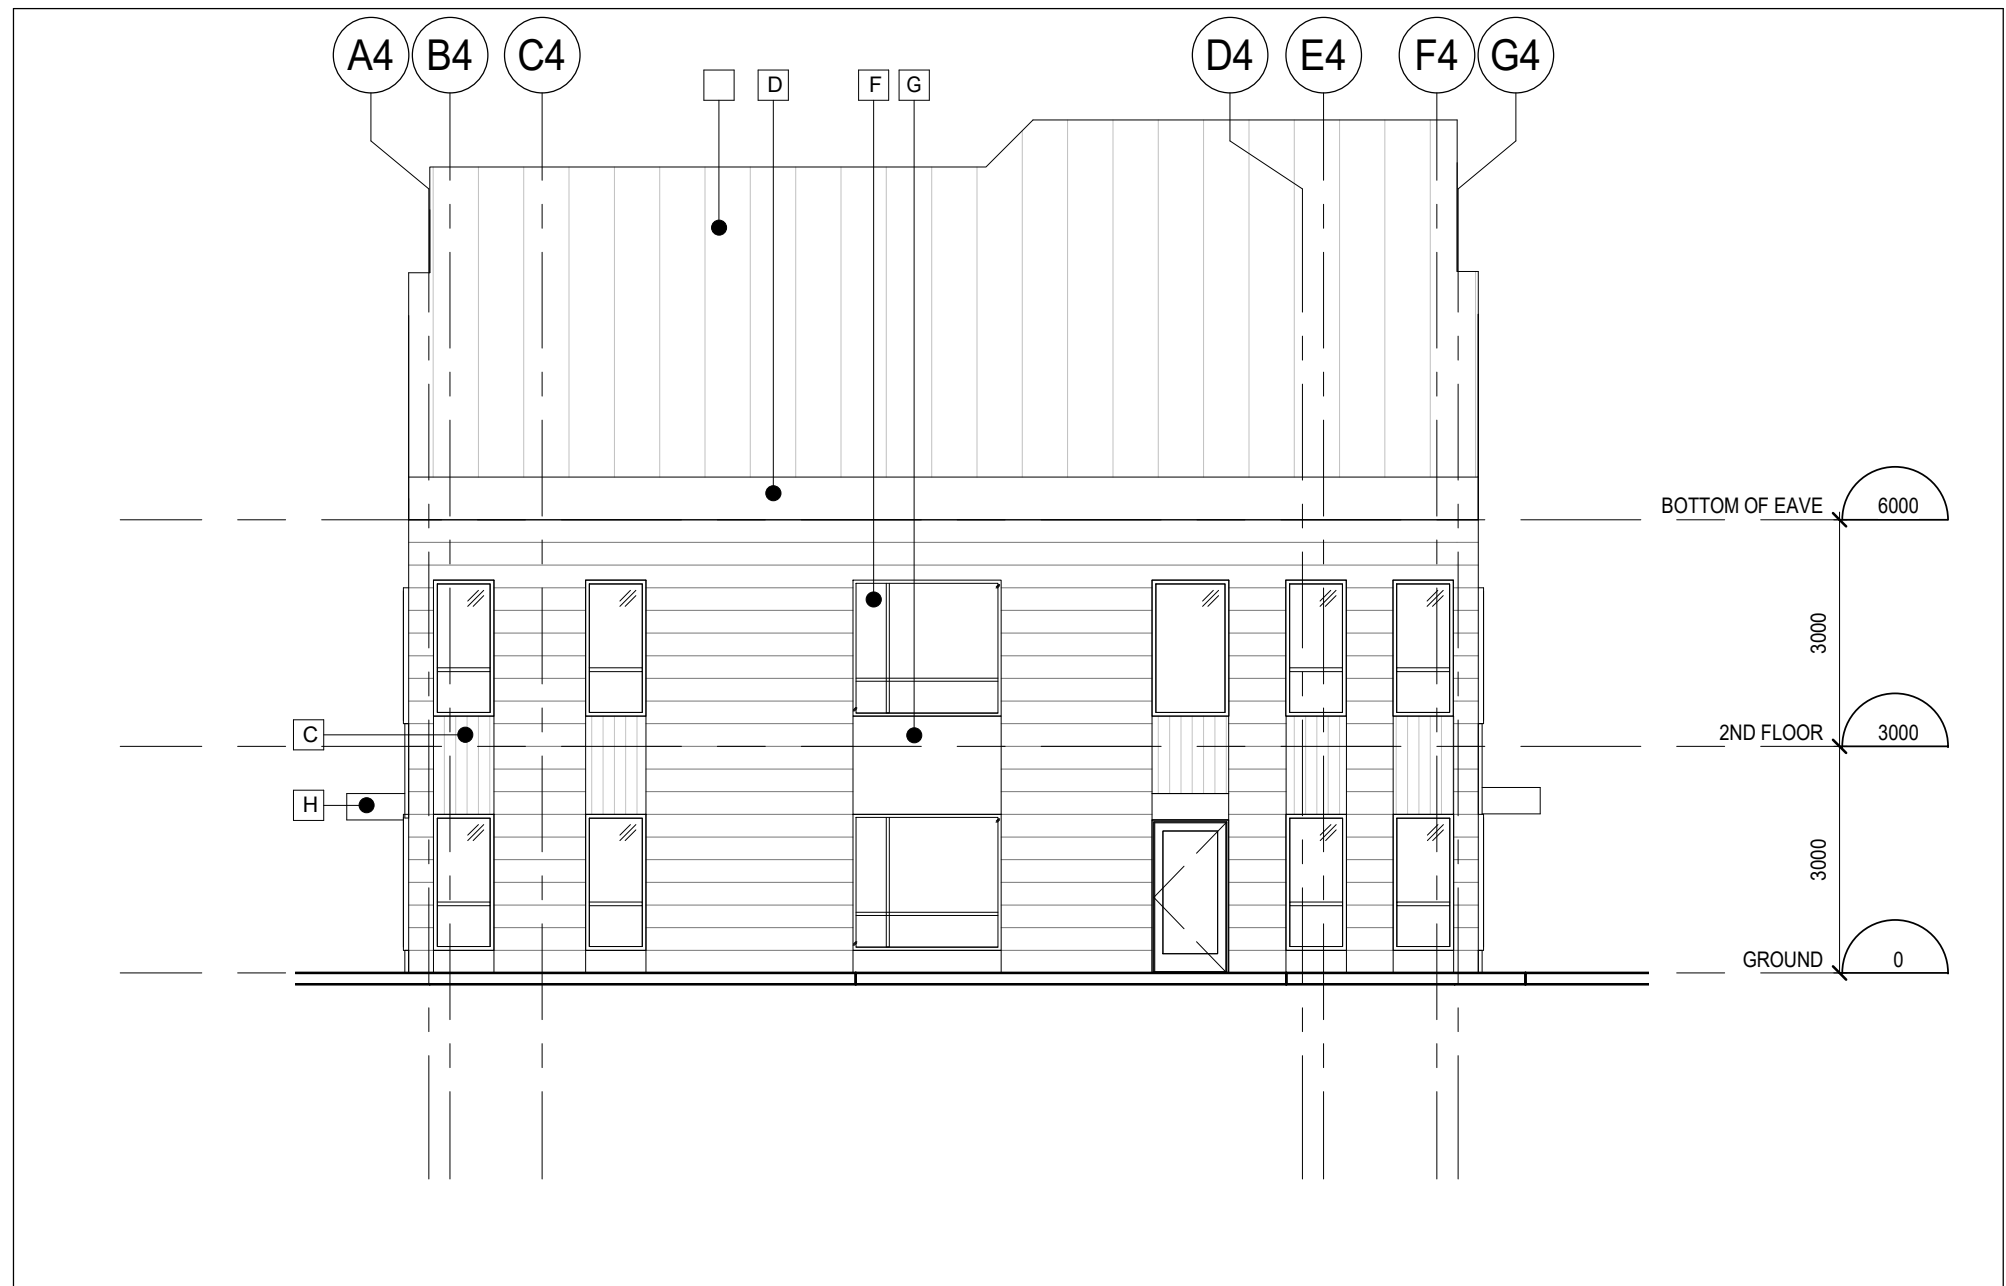

4 WEST ELEVATION
1:100



1 NORTH ELEVATION
1:100

DO NOT SCALE THE DRAWINGS
CHECK AND VERIFY ALL DIMENSIONS AT THE SITE.
ALL DRAWINGS, SPECIFICATIONS AND RELATED DOCUMENTS ARE THE
COPYRIGHT PROPERTY OF THE CONSULTANT AND MUST BE RETURNED
UPON REQUEST. REPRODUCTION OF DRAWINGS IN PART OR WHOLE
WITHOUT THE PERMISSION OF THE CONSULTANT IS FORBIDDEN.
DRAWINGS ARE NOT TO BE USED FOR CONSTRUCTION UNTIL SIGNED
AND SEALED BY THE CONSULTANT.

NO.	ISSUES	DATE	BY
1	ISSUED FOR REZONING	20/06/30	BBA
2	ISSUED FOR SPA	20/12/07	BBA

MATERIAL LEGEND:

- A - HARDBOARD SIDING (WHITE)
- B - HARDBOARD SIDING (GREY/BLUE)
- C - ALUMINUM SIDING
- D - PREFIN. METAL FACIA
- E - METAL ROOF
- F - GLAZING
- G - SPANDREL PANEL
- H - ALUMINUM BOARD CANOPY

NO.	REVISIONS	DATE	BY

PROJECT:
**ELGIN PARK
REDEVELOPMENT
PROJECT**
265 - 327 ELGIN STREET
COBOURG, ONTARIO
NORTHUMBERLAND COUNTY

DRAWING:
**BUILDING 4 ELEVATIONS
& SECTIONS**



BARRY BRYAN
ASSOCIATES


Architects
Engineers
Project Managers

201-250 Water Street
Whitby Ontario L1N 0G5
Tel: (905) 666-5252
Fax: (905) 666-5256
e-mail: bba@bba-archeng.com


DESIGN BY: BBA	DOC CONTROL: JAE
DRAWN BY: DC/DP	% COMPLETE:
CHECKED BY: DP	INITIAL:

DATE: 11/02/20
SCALE: As indicated
FILE:


PROJECT NO: 19284	DRAWING NO: A304
-----------------------------	----------------------------

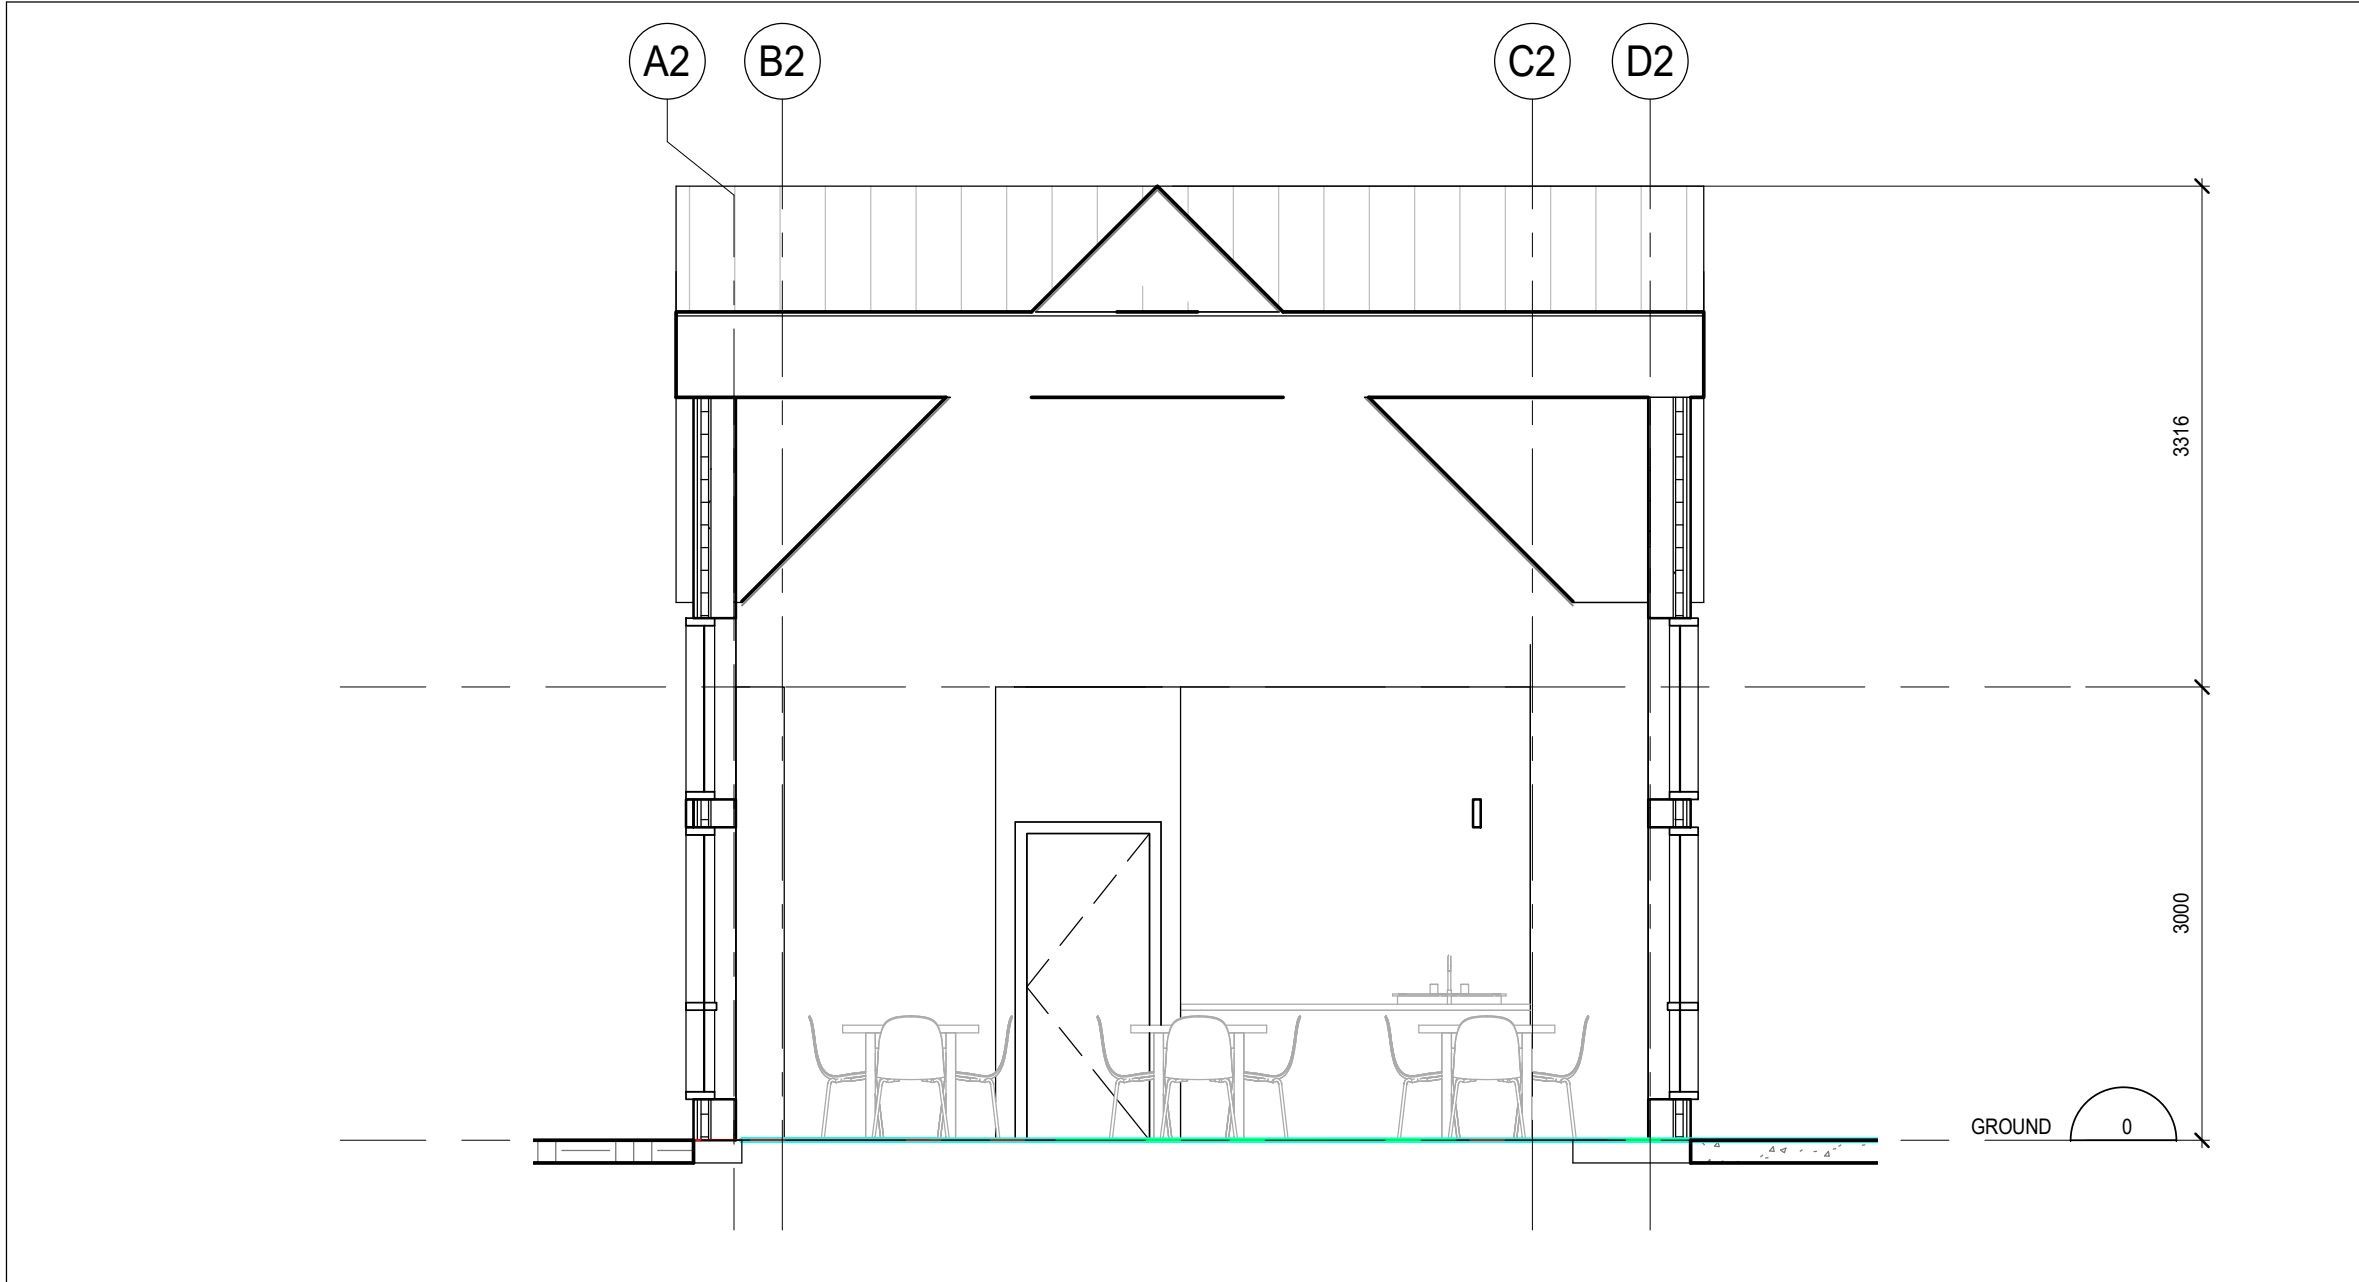


6 BUILDING SECTION
1:50

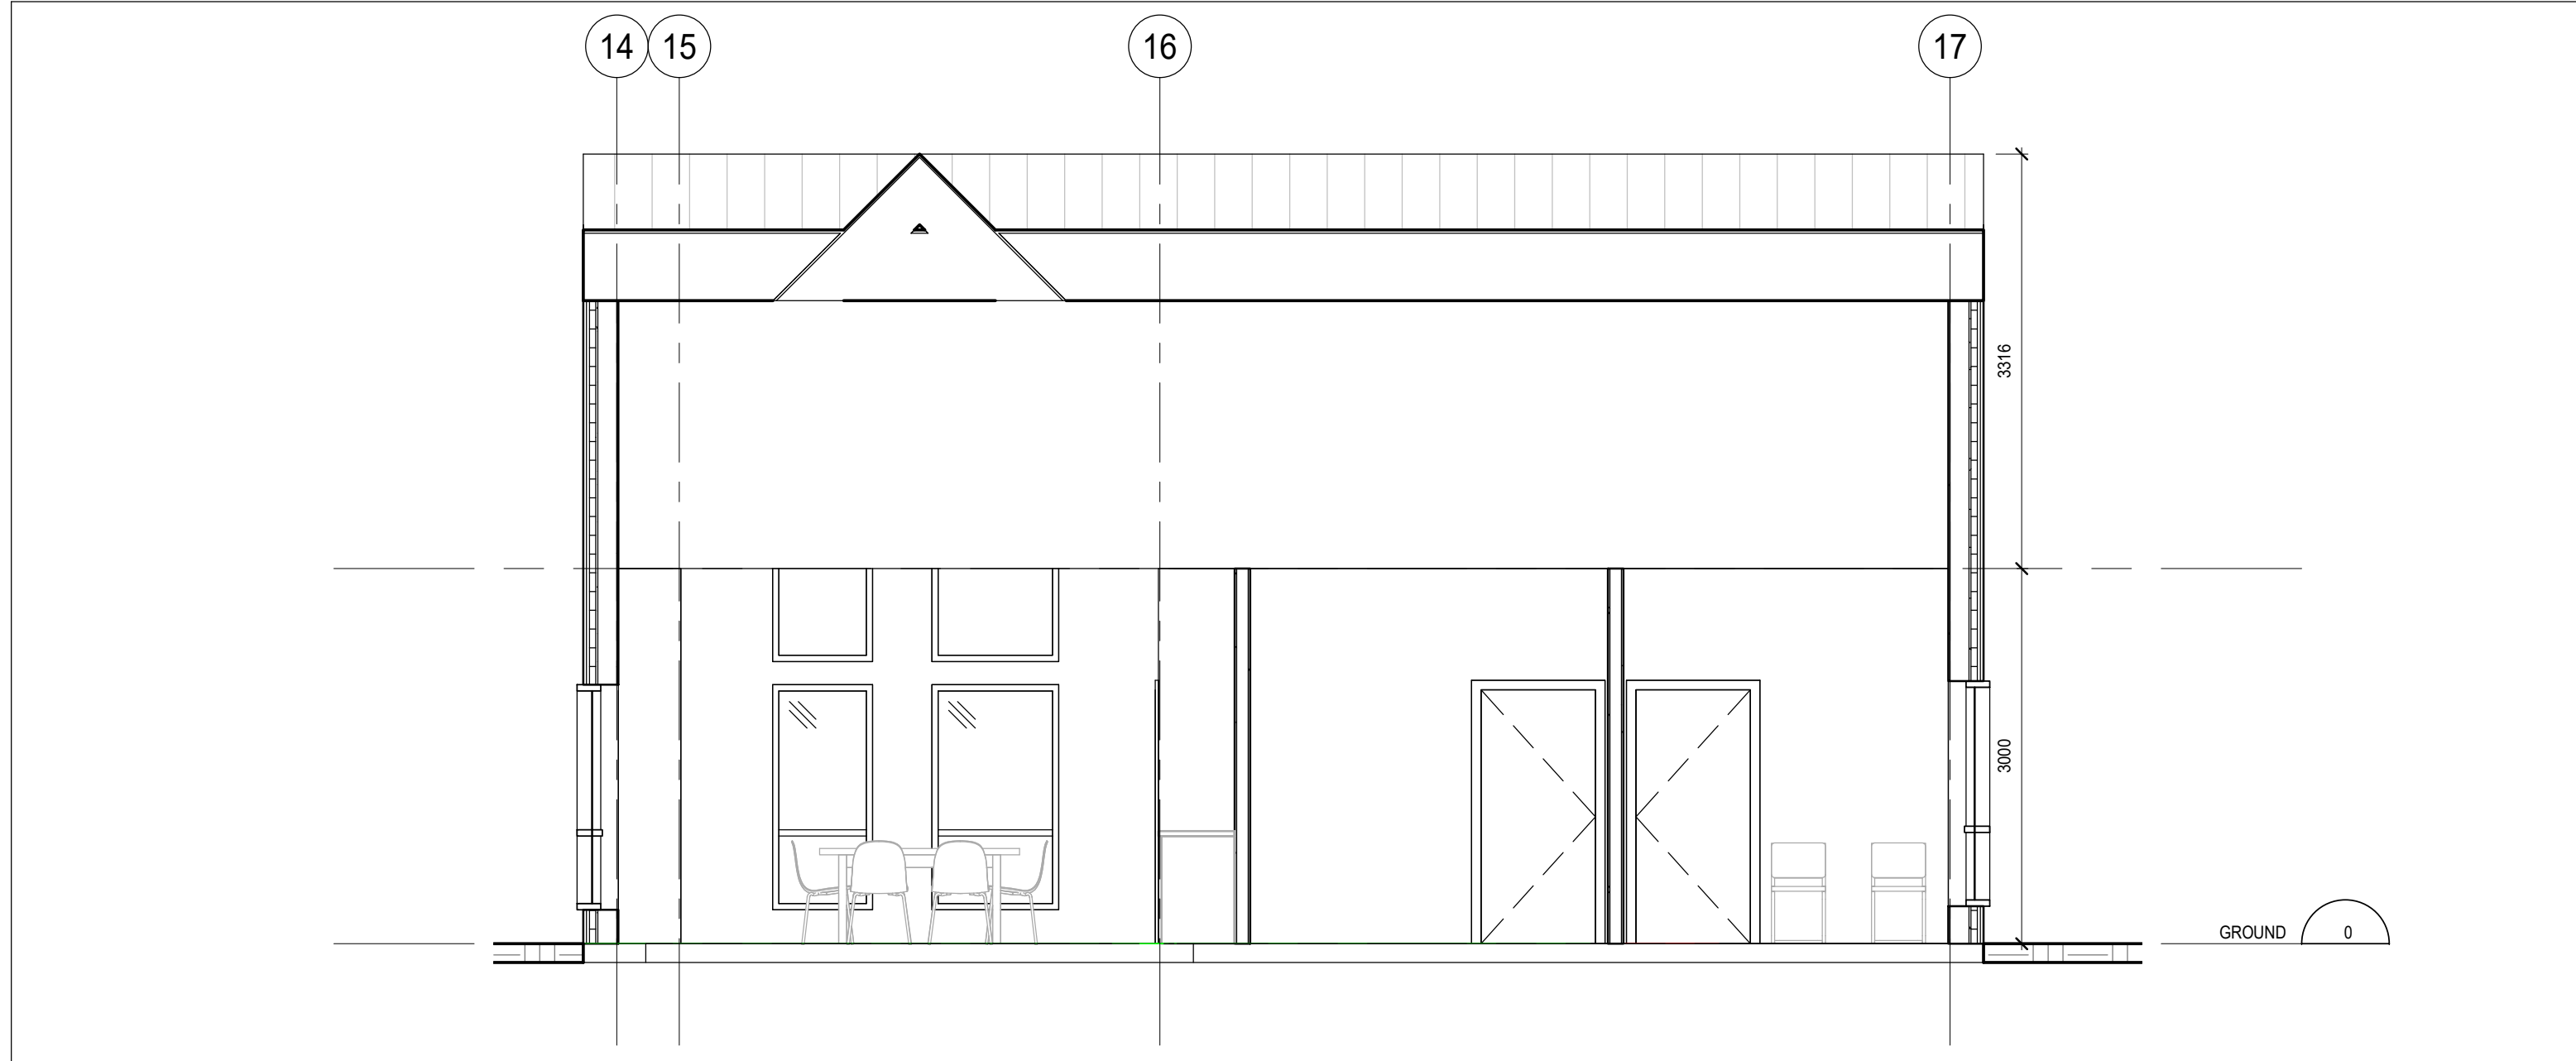


3 BUILDING SECTION
1:50

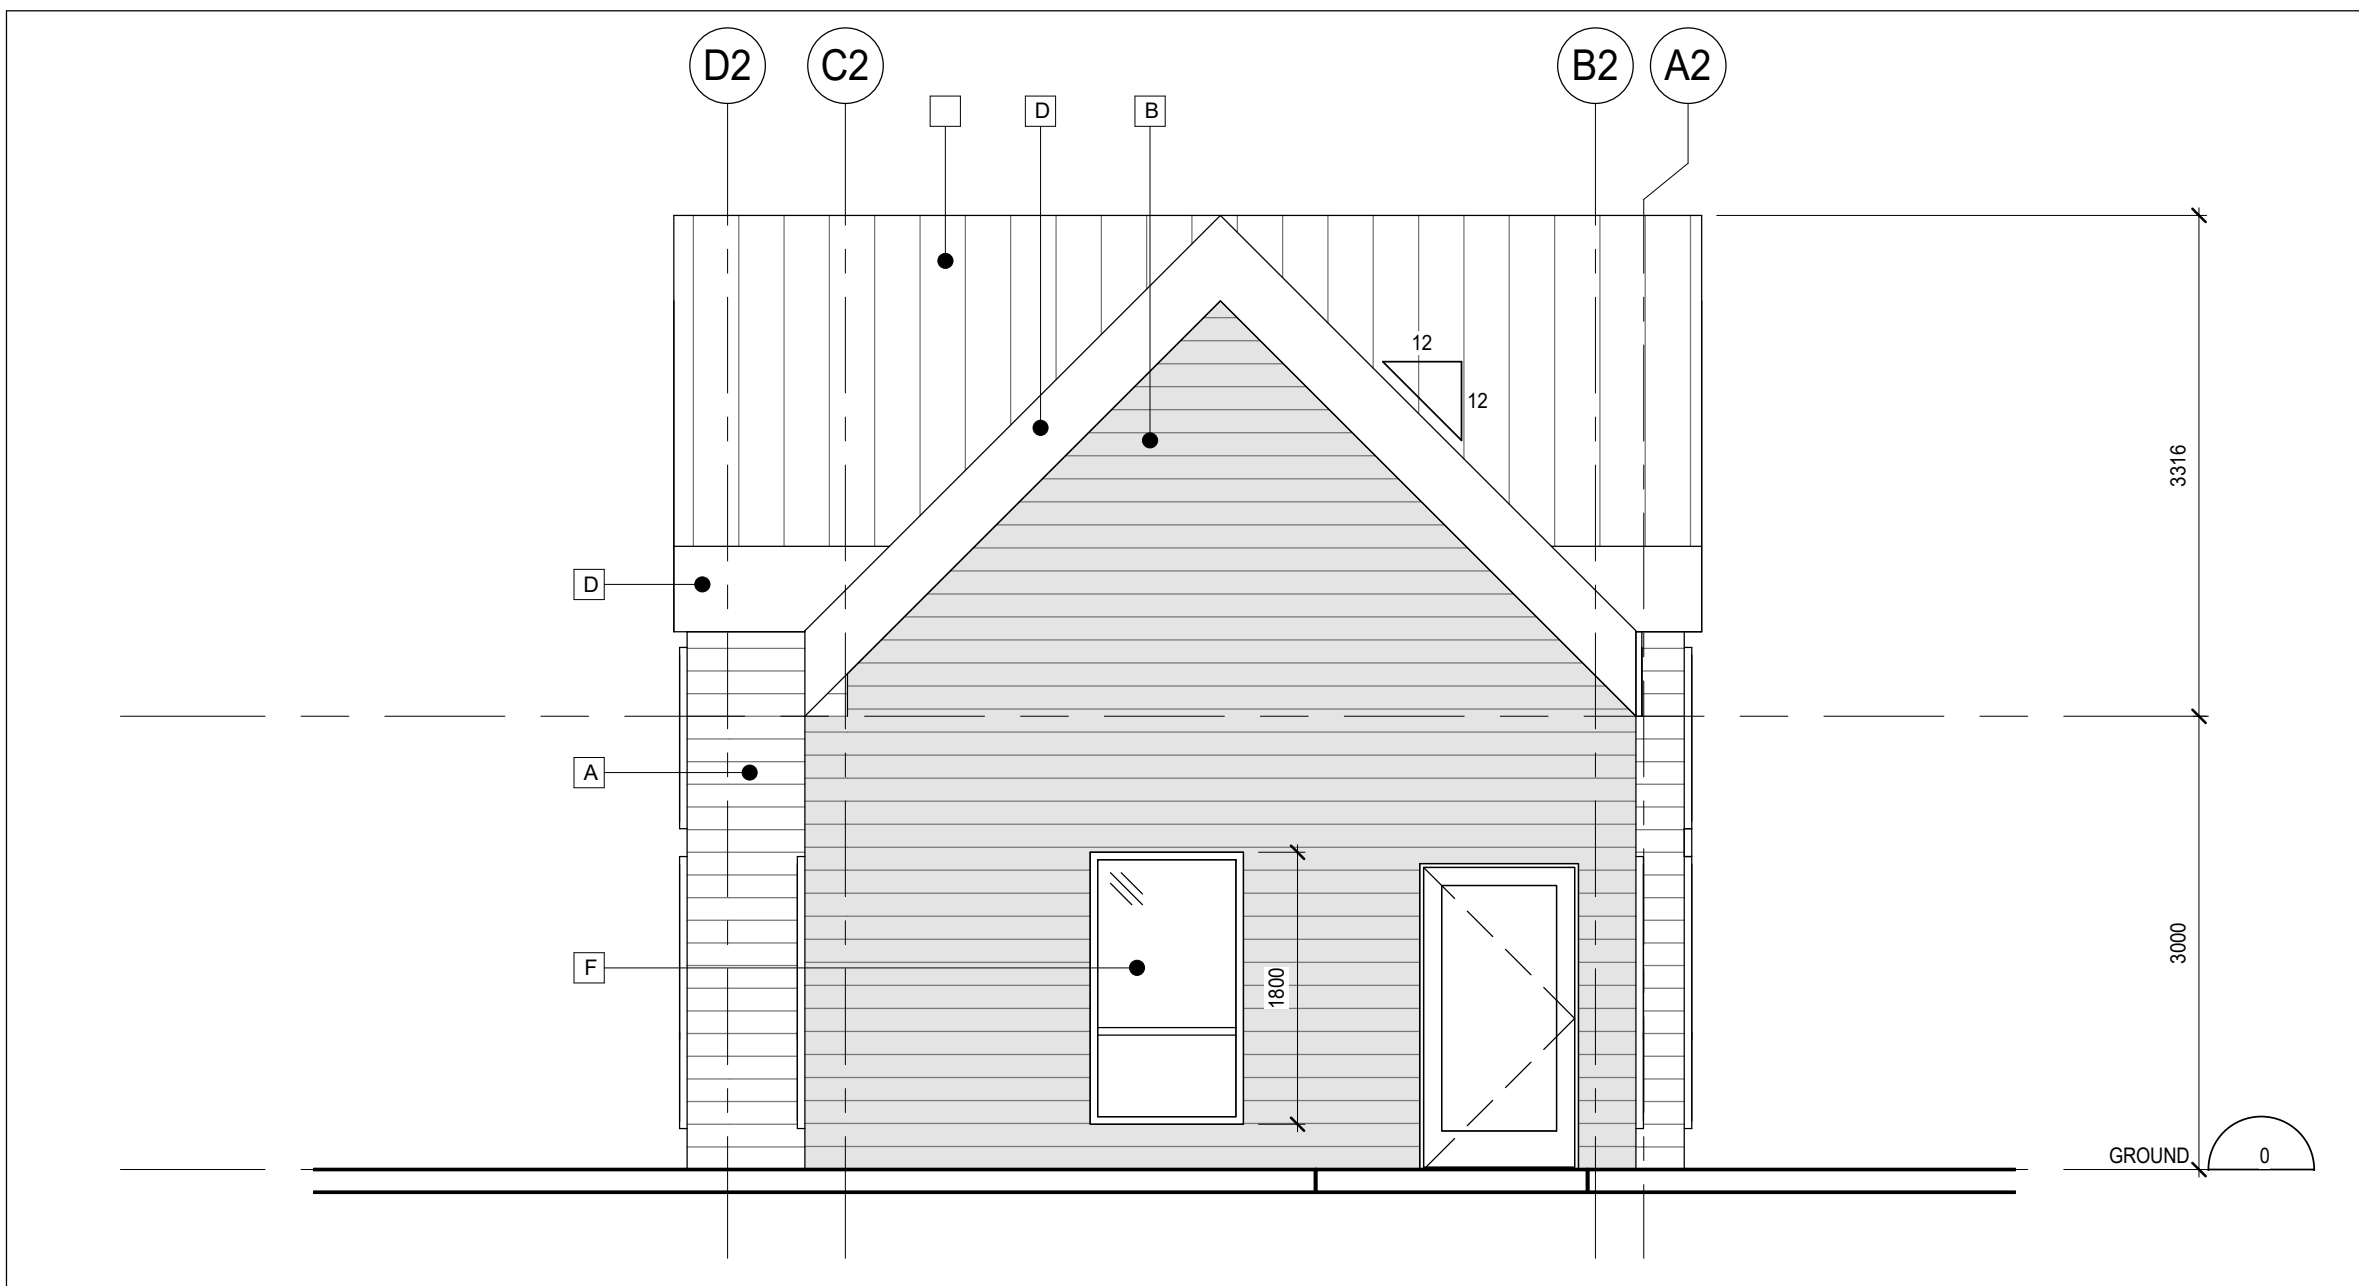


5 EAST ELEVATION
1:50

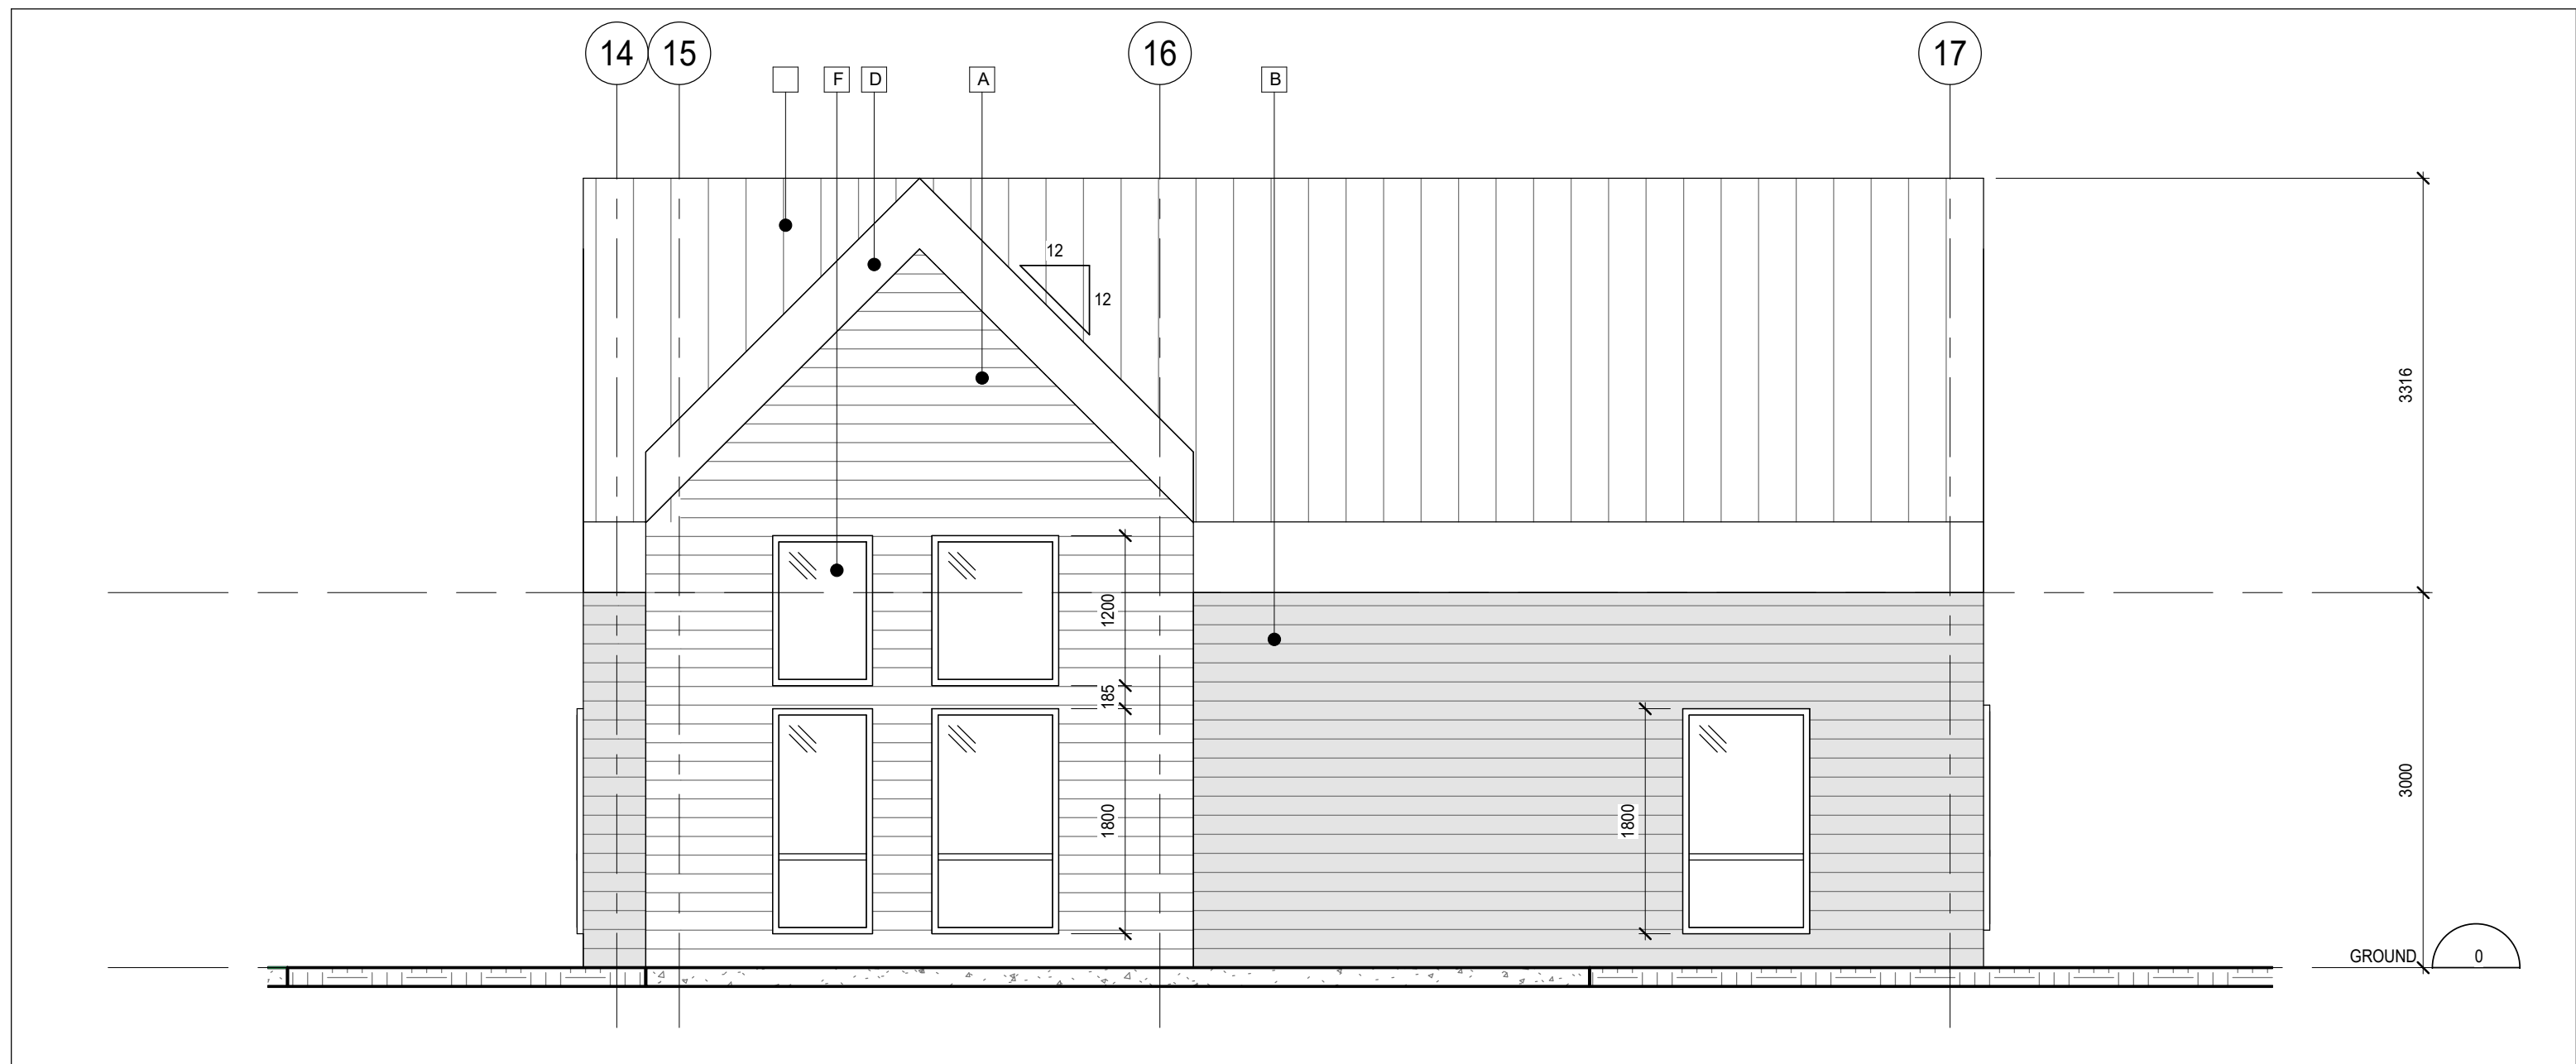

2 SOUTH ELEVATION
1:50

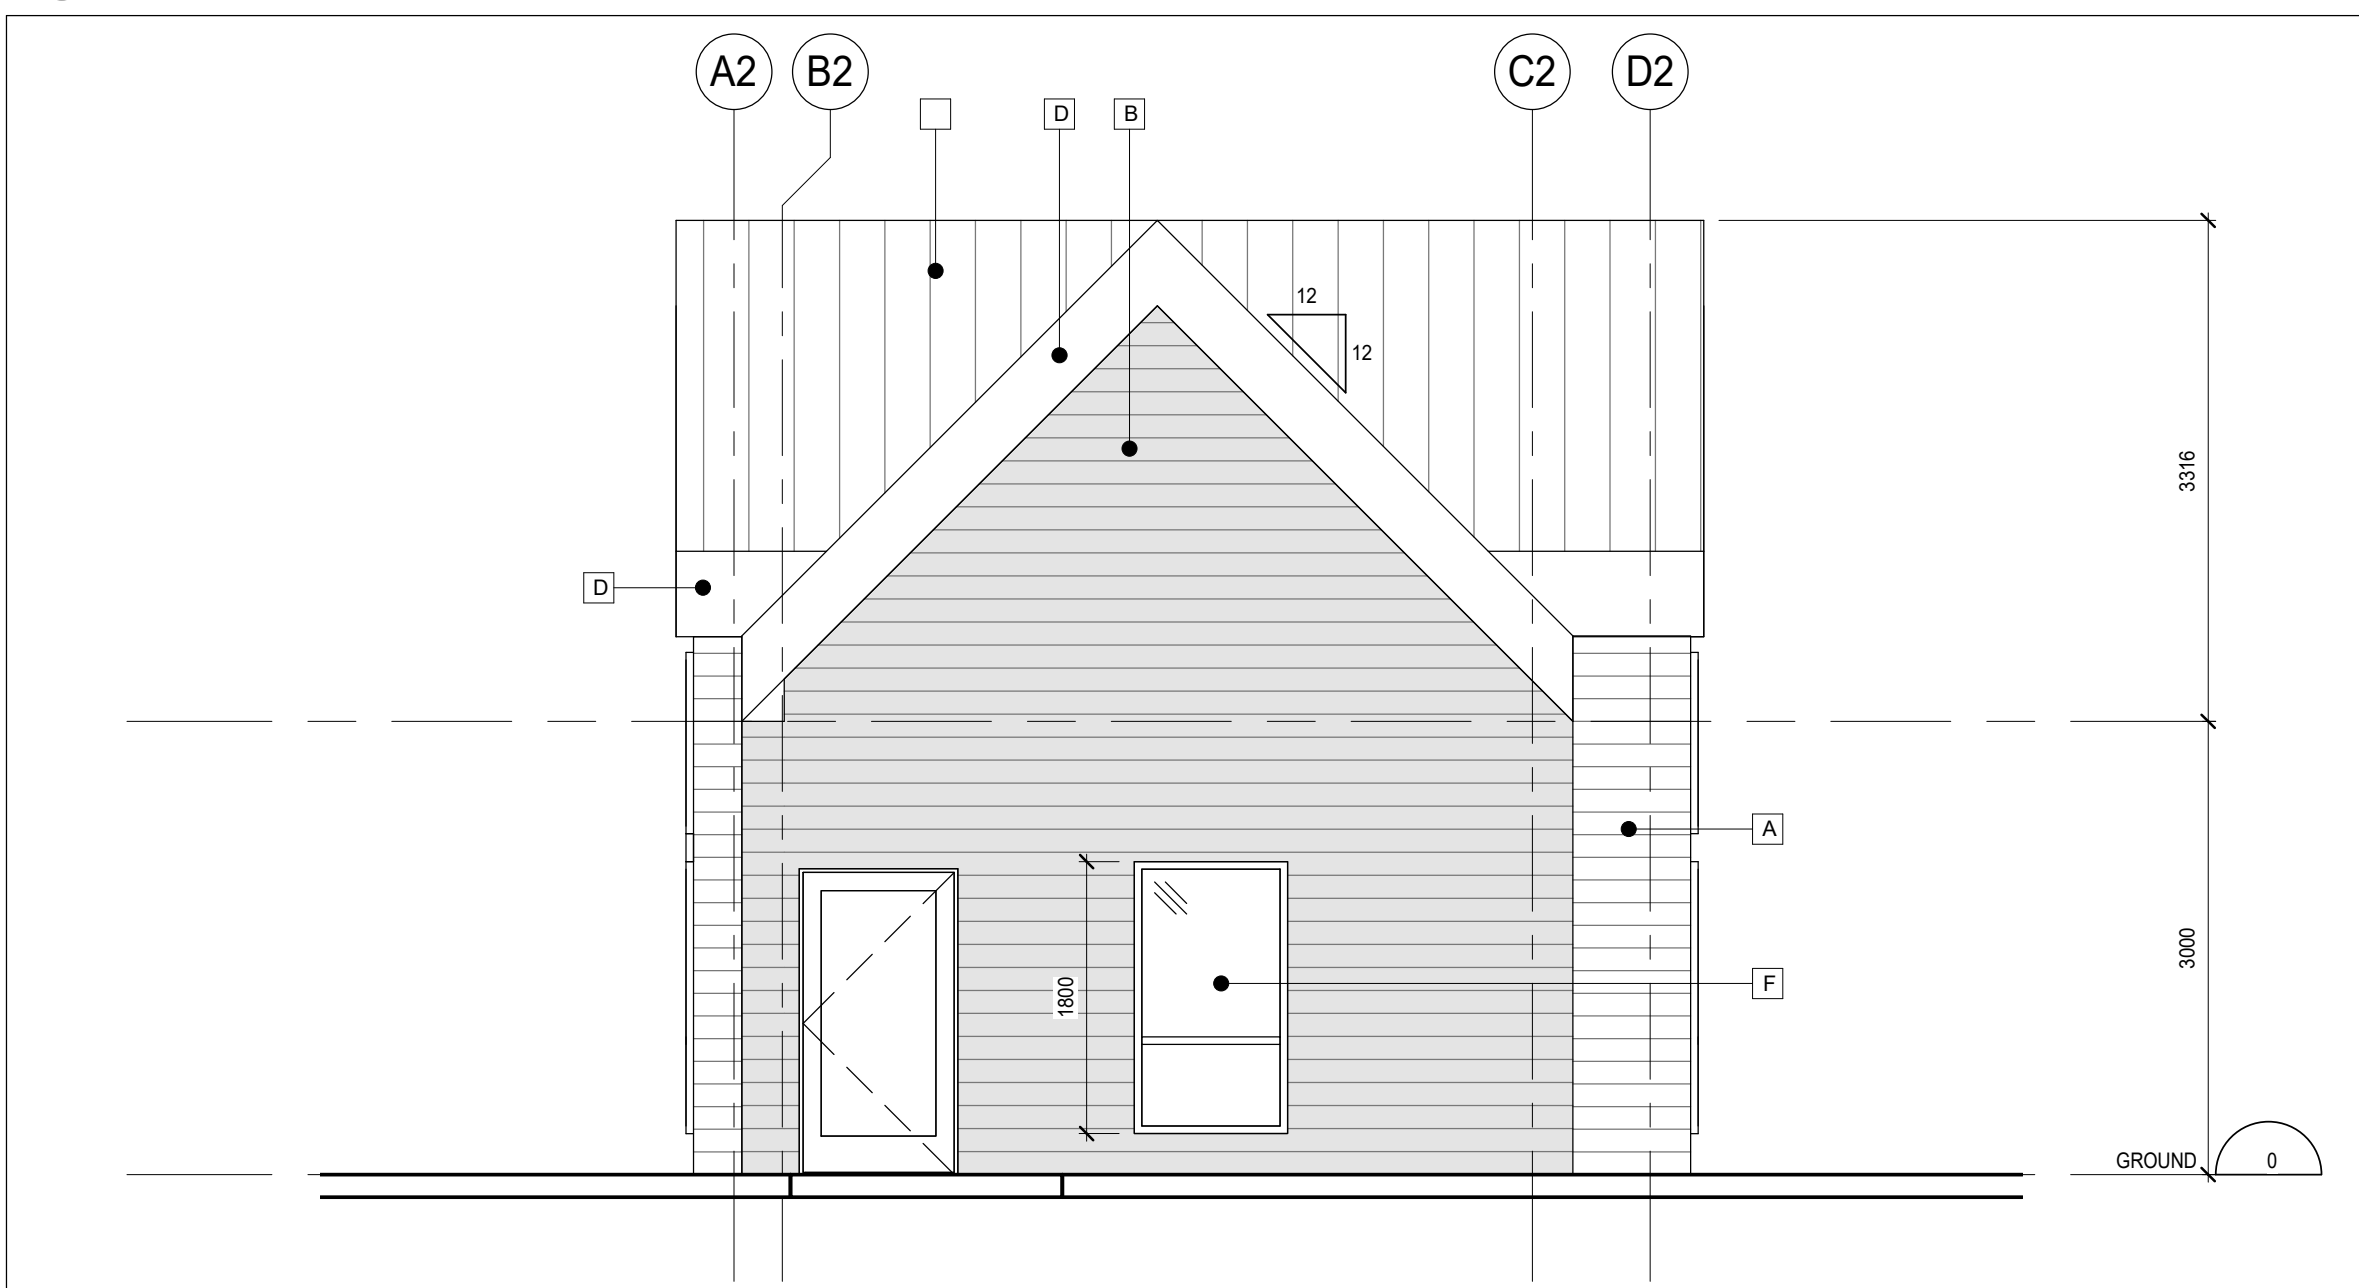

4 WEST ELEVATION
1:50

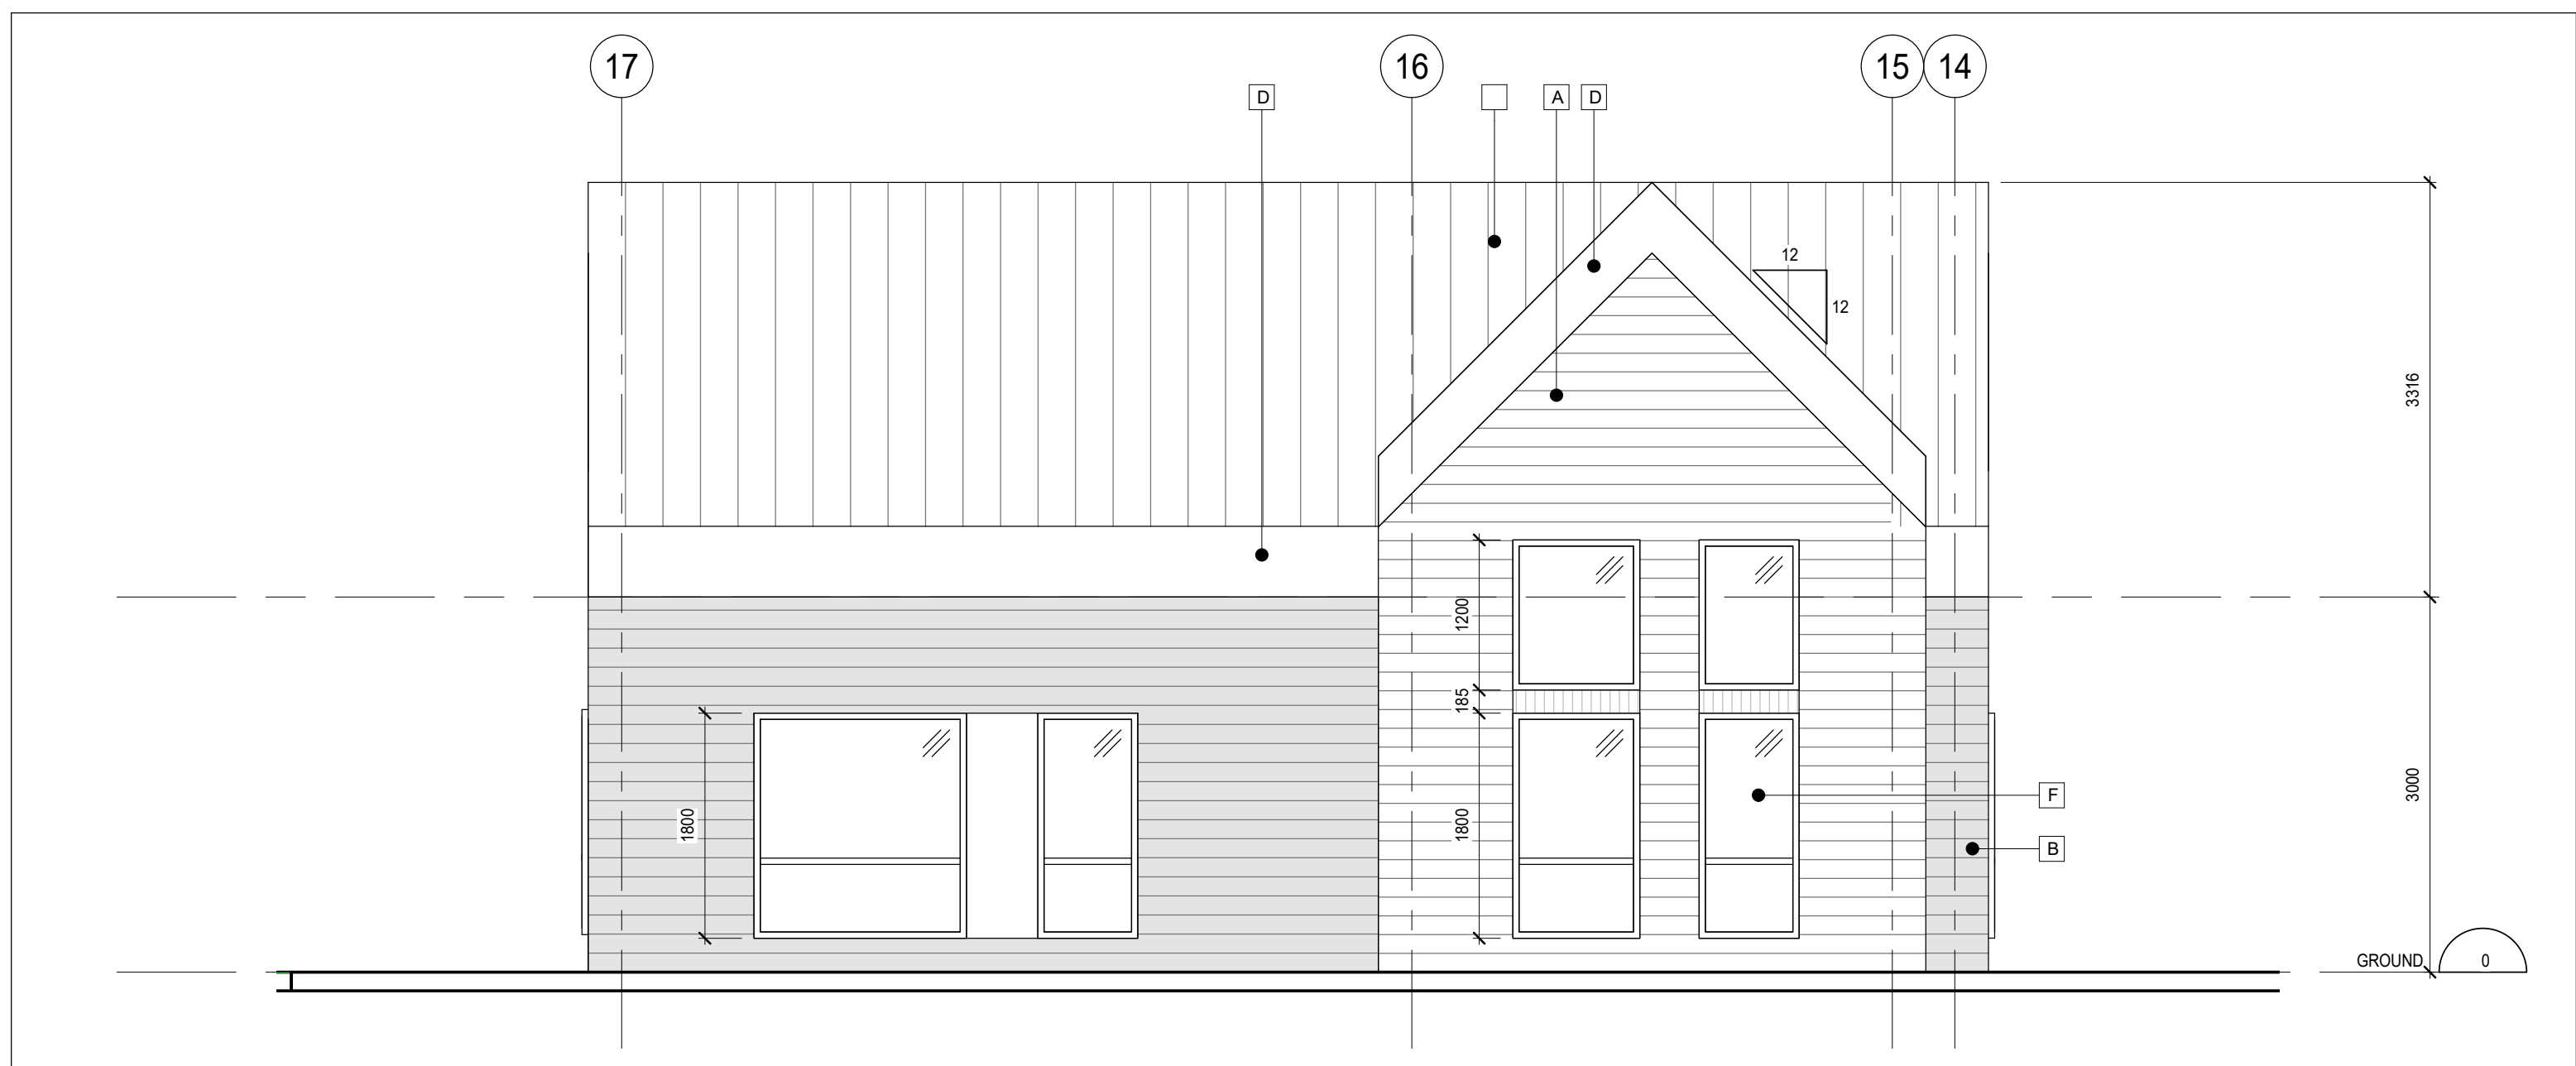

1 NORTH ELEVATION
1:50

DO NOT SCALE THE DRAWINGS
CHECK AND VERIFY ALL DIMENSIONS AT THE SITE.
ALL DRAWINGS, SPECIFICATIONS AND RELATED DOCUMENTS ARE THE
COPYRIGHT PROPERTY OF THE CONSULTANT AND MUST BE RETURNED
UPON REQUEST. REPRODUCTION OF DRAWINGS IN PART OR WHOLE
WITHOUT THE PERMISSION OF THE CONSULTANT IS FORBIDDEN.
DRAWINGS ARE NOT TO BE USED FOR CONSTRUCTION UNTIL SIGNED
AND SEALED BY THE CONSULTANT.

NO.	ISSUES	DATE	BY
1	ISSUED FOR REZONING	20/06/30	BBA
2	ISSUED FOR SPA	20/12/07	BBA

MATERIAL LEGEND:

- A - HARDBOARD SIDING (WHITE)
- B - HARDBOARD SIDING (GREY/BLUE)
- C - ALUMINUM SIDING
- D - PREFIN. METAL FACIA
- E - METAL ROOF
- F - GLAZING
- G - SPANDREL PANEL
- H - ALUMINUM BOARD CANOPY

NO.	REVISIONS	DATE	BY

PROJECT:
**ELGIN PARK
REDEVELOPMENT
PROJECT**
265 - 327 ELGIN STREET
COBOURG, ONTARIO
NORTHUMBERLAND COUNTY

DRAWING:
**BUILDING 5 ELEVATIONS
& SECTIONS**



BARRY BRYAN
ASSOCIATES

Architects
Engineers
Project Managers

201-250 Water Street
Whitby Ontario L1N 0G5
Tel: (905) 666-5252
Fax: (905) 666-5256
e-mail: bba@bba-archeng.com

DESIGN BY: BBA	DOC CONTROL: DATE
DRAWN BY: NV	% COMPLETE:
CHECKED BY: NS	INITIAL:

DATE: 11/02/20
SCALE: As indicated
FILE:

PROJECT NO: 19284	DRAWING NO: A305
-----------------------------	----------------------------